




P 6 1
ROOF DECK - STORM DRAIN LAYOUT
SCALE: 1:100 MTS

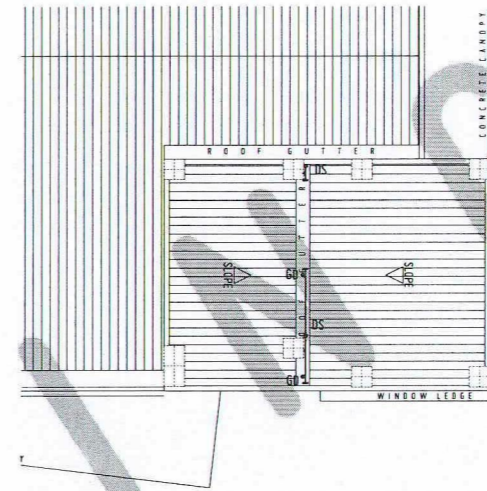

P 6 2
UPPER ROOF PLAN - STORM DRAIN LAYOUT
SCALE: 1:100 MTS

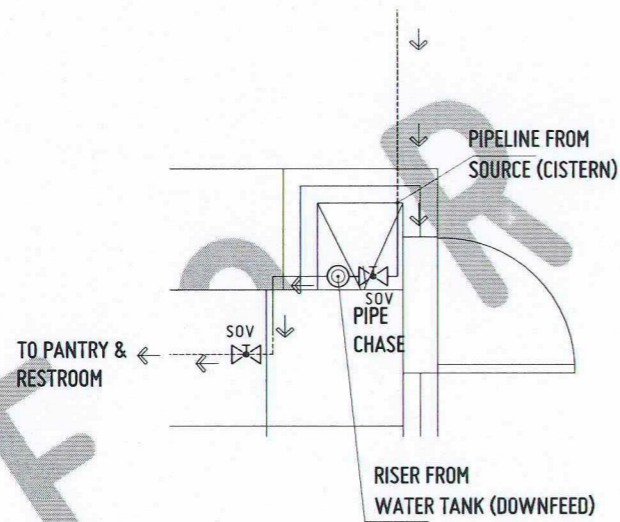

P 6 3
SPOT DETAIL W2
SCALE: 1:10 MTS

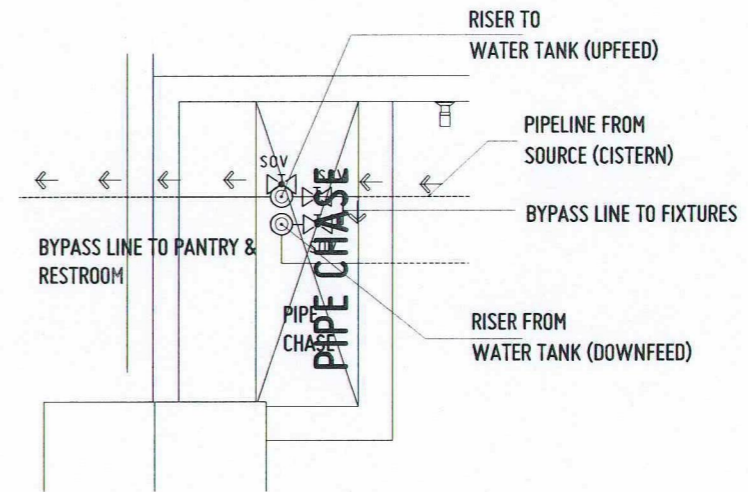

P 6 4
SPOT DETAIL W2
SCALE: 1:10 MTS



REPUBLIC OF THE PHILIPPINES
UNIVERSITY OF SCIENCE AND TECHNOLOGY OF SOUTHERN PHILIPPINES
CAGAYAN DE ORO CAMPUS
INFRASTRUCTURE PLANNING AND FACILITY DEVELOPMENT UNIT
CLARO M. RECTO AVENUE, LAPASAN, CAGAYAN DE ORO CITY 9000
TELEPHONE # (08822) 72-60-65 / (088) 856-1738 / 856-1739 | TELE FAX (088) 856-4696
WEBSITE: www.ustp.edu.ph

MASTER PLUMBER	PROJECT
	LOCATION
	OWNER

PROPOSED CONSTRUCTION OF SMART ACADEMIC BUILDING PHASE 1, JASAAN CAMPUS
USTP JASAAN CAMPUS, MISAMIS ORIENTAL
UNIVERSITY OF SCIENCE AND TECHNOLOGY OF SOUTHERN PHILIPPINES

RECOMMENDING APPROVAL: <i>Grace C. Baba</i> ENGR. GRACE C. BABA DIRECTOR, INFRASTRUCTURE PLANNING & FACILITIES DEVELOPMENT OFFICE
--


RECOMMENDING APPROVAL: <i>Erwin B. Bucio</i> ATTY. ERWIN B. BUCIO VP FOR ADMINISTRATION & LEGAL AFFAIRS
--

APPROVED BY: <i>Ambrosio B. Cultura II</i> DR. AMBROSIO B. CULTURA II RESIDENT, USTP SYSTEM
--

SHEET CONTENTS: STORM DRAIN LAYOUT: ROOF DECK AREA UPPER ROOF PLAN

DRAWN BY:
DATE DRAWN: 10.01.2025
FNT:

P6

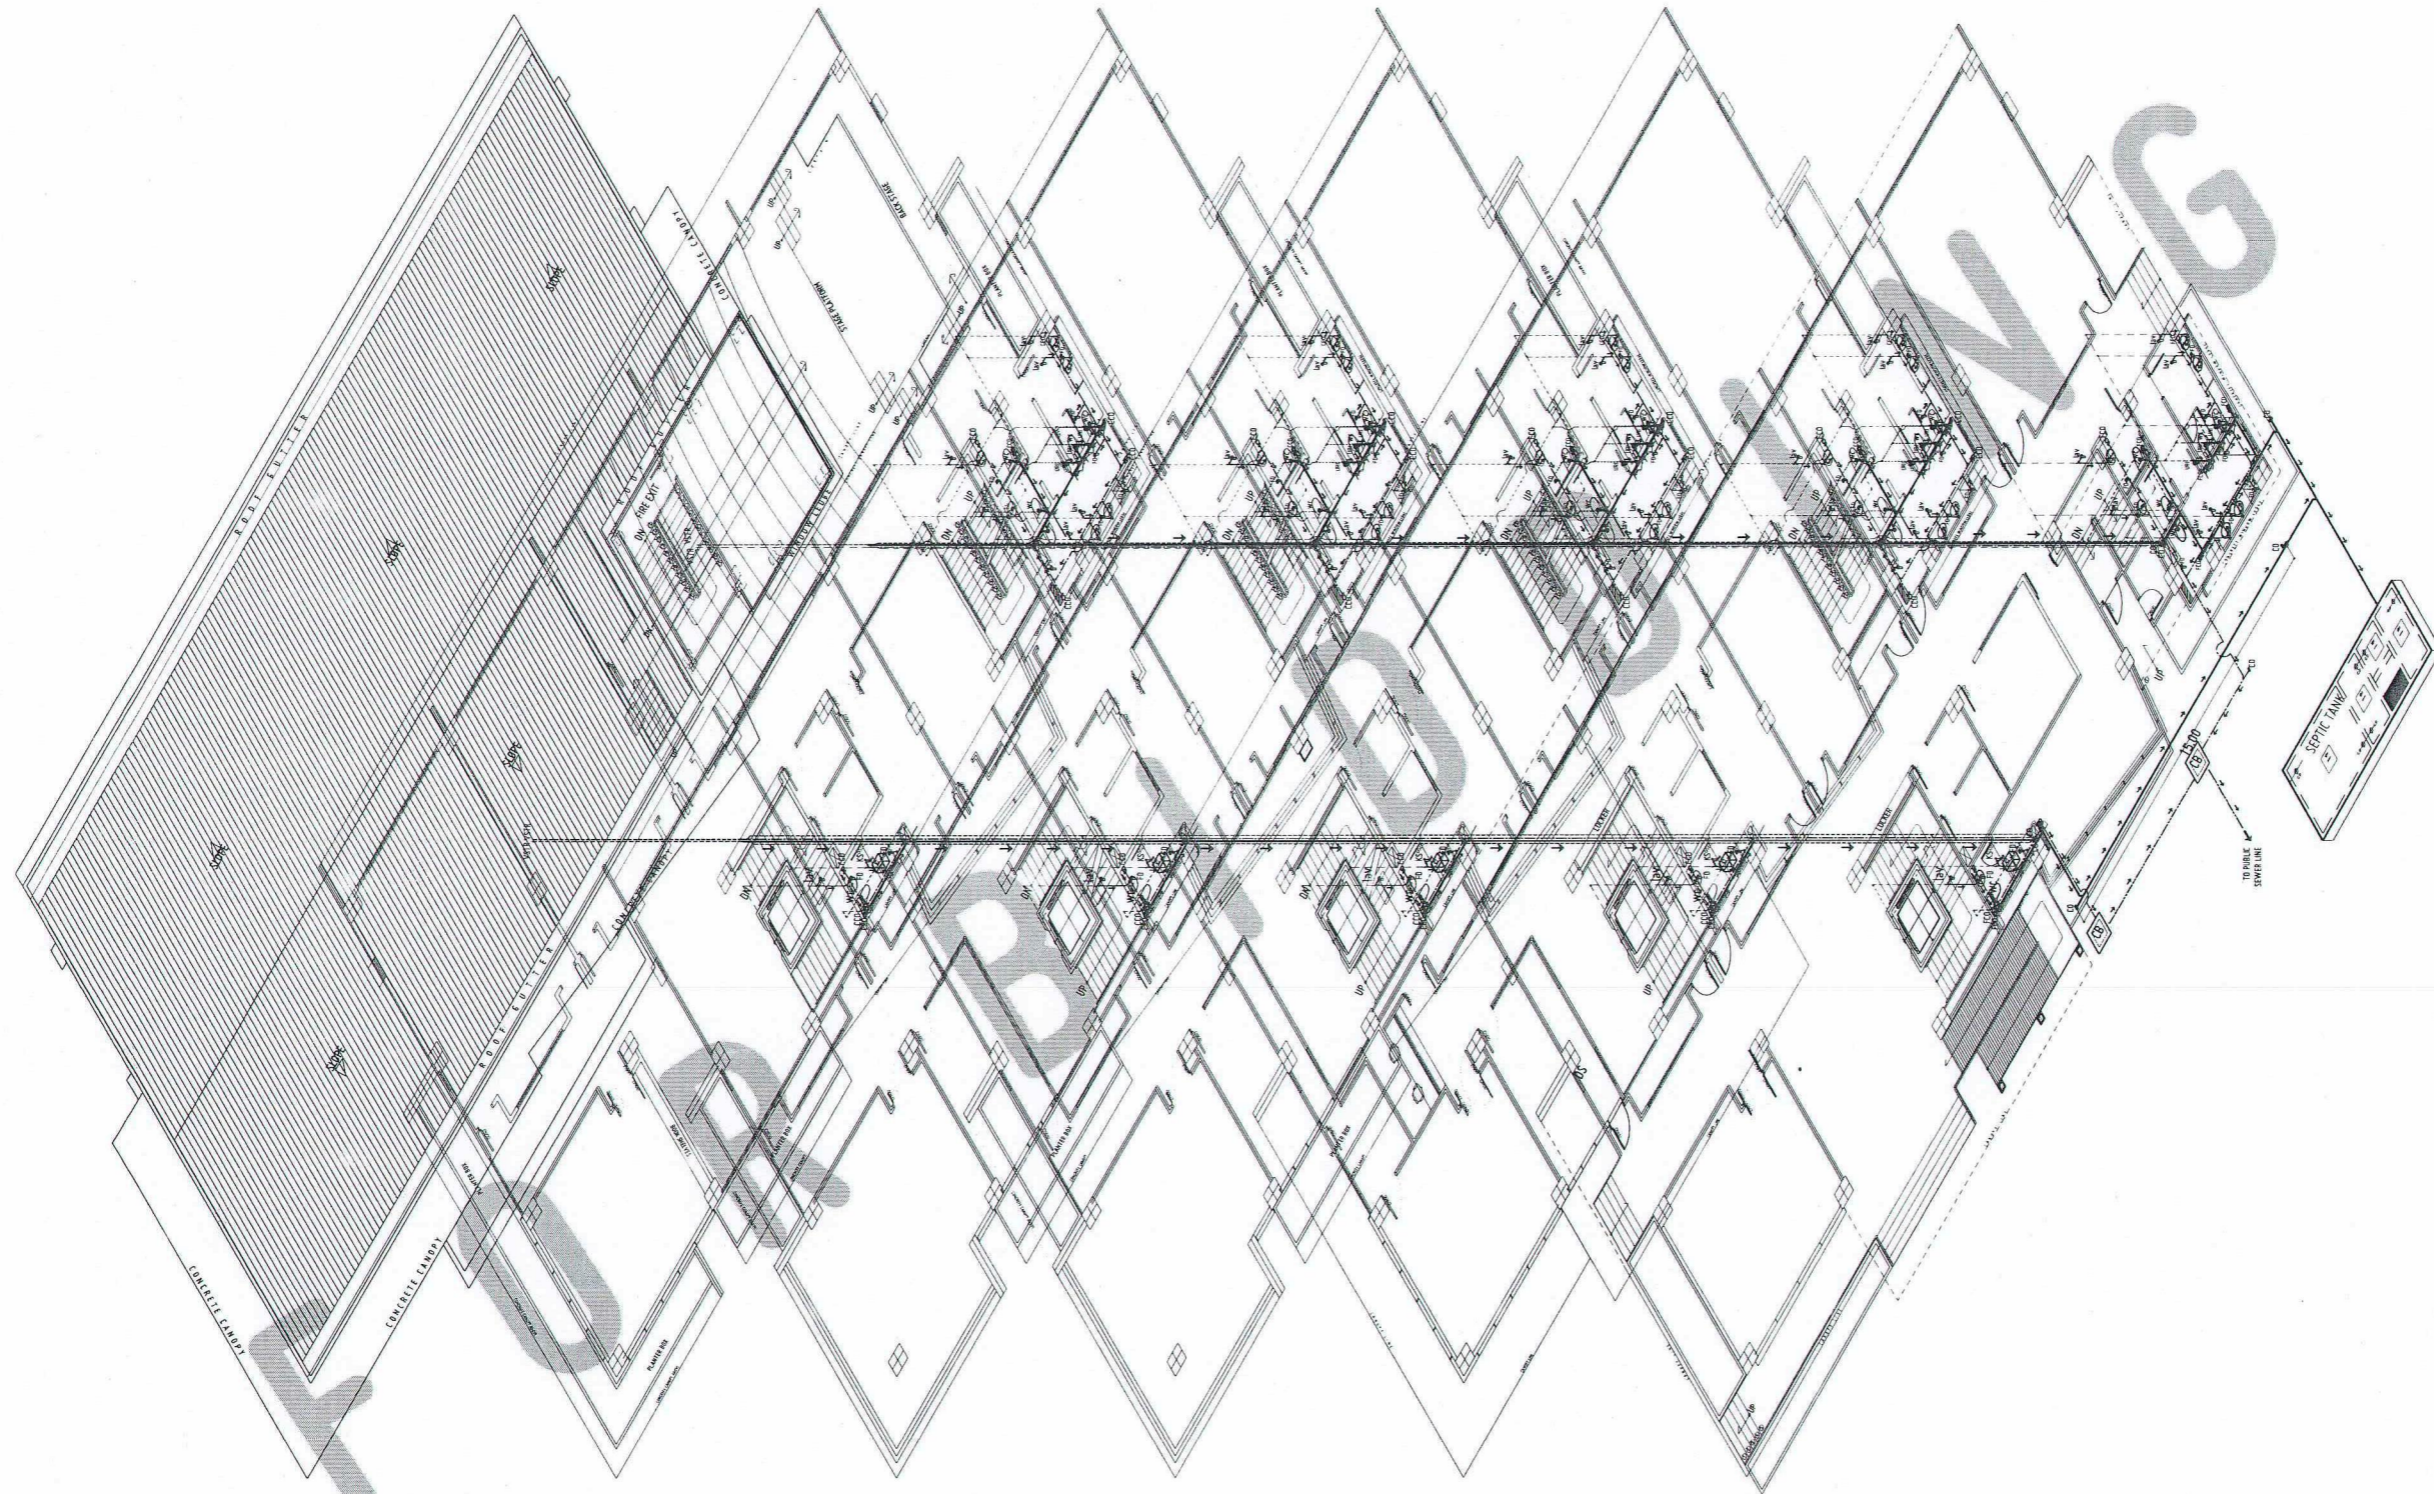

ISOMETRIC VIEW - SOIL & WASTE PIPING LAYOUT

NTS

SCALE:
P 1
7 1



REPUBLIC OF THE PHILIPPINES
UNIVERSITY OF SCIENCE AND TECHNOLOGY OF SOUTHERN PHILIPPINES
CAGAYAN DE ORO CAMPUS
INFRASTRUCTURE PLANNING AND FACILITY DEVELOPMENT UNIT
CLARO M. RECTO AVENUE, LAPASAN, CAGAYAN DE ORO CITY 9000
TELEPHONE N (08822) 72-60-65 / (088) 856-1738 / 856-1739 | TELE FAX (088) 856-4696
WEBSITE: www.ustp.edu.ph

MASTER PLUMBER

PROJECT: PROPOSED CONSTRUCTION OF SMART ACADEMIC BUILDING PHASE 1, JASAAN CAMPUS
LOCATION: USTP JASAAN CAMPUS, MISAMIS ORIENTAL
OWNER: UNIVERSITY OF SCIENCE AND TECHNOLOGY OF SOUTHERN PHILIPPINES

RECOMMENDING APPROVAL:
ENGR. GRACE C. BABA
DIRECTOR, INFRASTRUCTURE PLANNING & FACILITIES DEVELOPMENT OFFICE


RECOMMENDING APPROVAL:
ATTY. ERWIN B. BUGIO
VP FOR ADMINISTRATION & LEGAL AFFAIRS

APPROVED BY:
DR. AMBROSIO B. CULTURA II
PRESIDENT, USTP SYSTEM


SHEET CONTENTS:
ISOMETRIC VIEW:
PLUMBING SOIL & WASTE LAYOUT

DRAWN BY:
DATE DRAWN:
10.01.2025
PNT:

P7

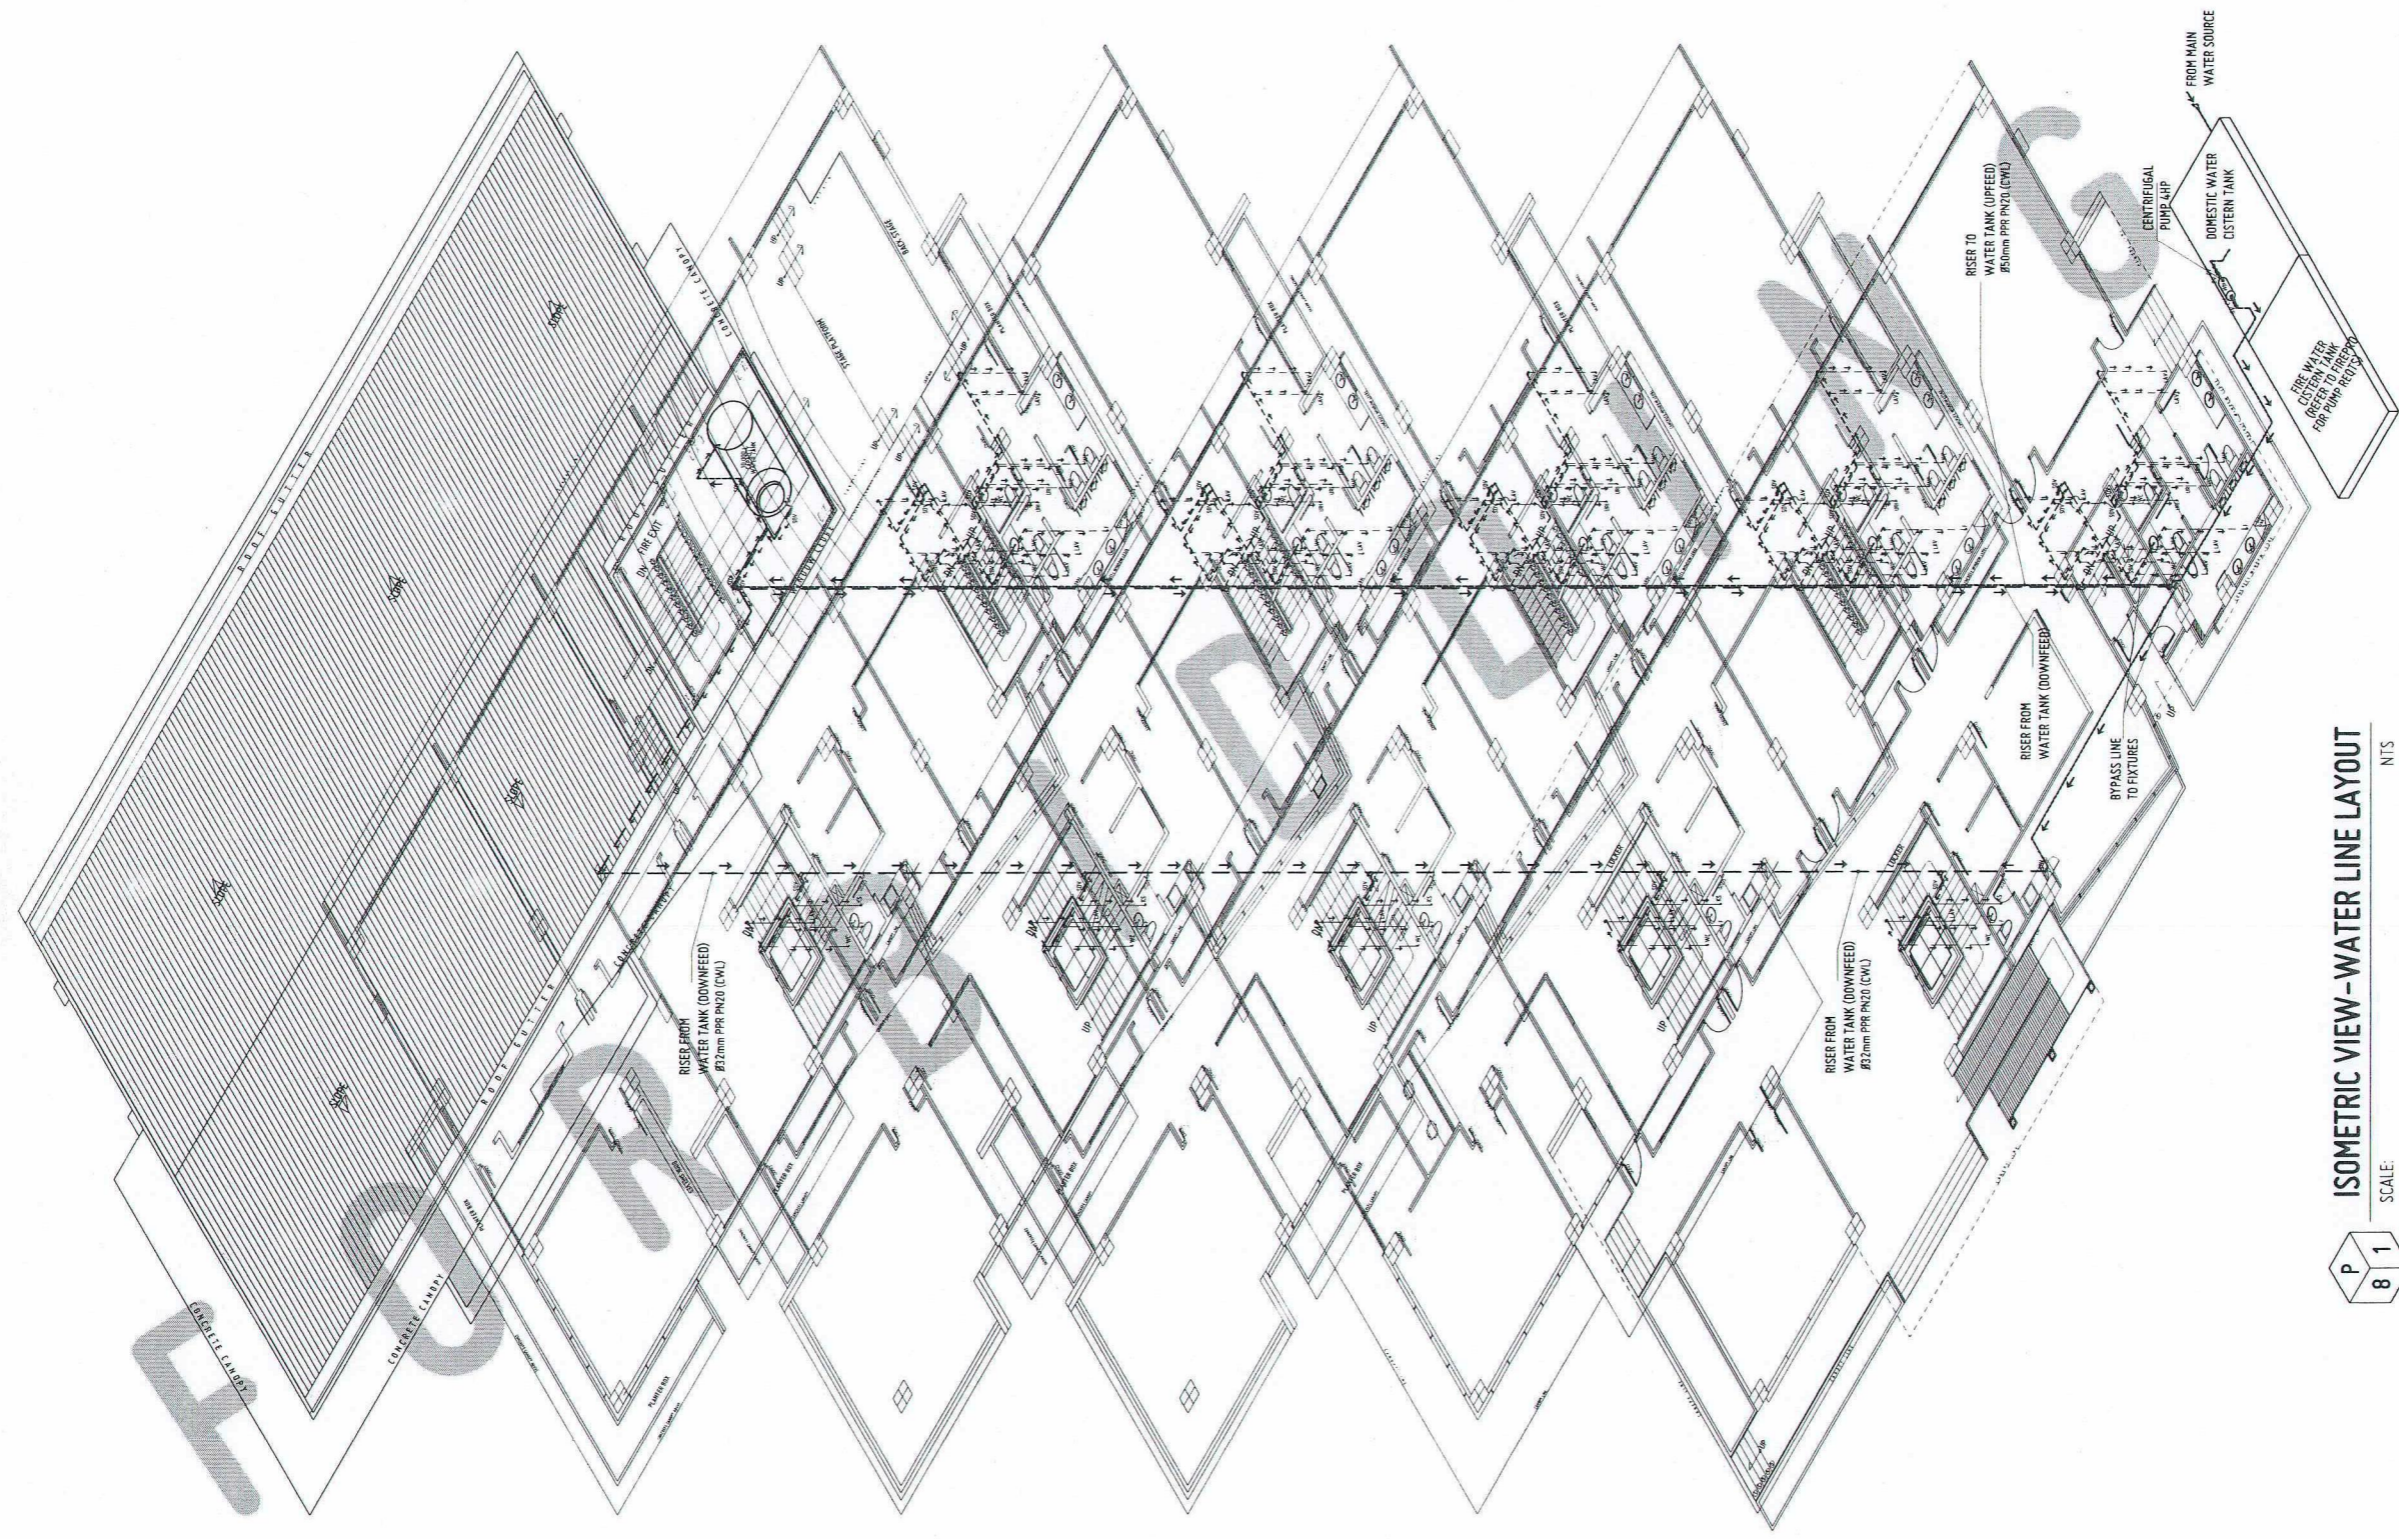

ISOMETRIC VIEW-WATER LINE LAYOUT
SCALE: 8/1
NTS

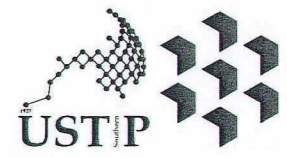

REPUBLIC OF THE PHILIPPINES
UNIVERSITY OF SCIENCE AND TECHNOLOGY OF SOUTHERN PHILIPPINES
CAGAYAN DE ORO CAMPUS
INFRASTRUCTURE PLANNING AND FACILITY DEVELOPMENT UNIT
CLARO M. RECTO AVENUE, LAPASAN, CAGAYAN DE ORO CITY 9000
TELEPHONE # (08822) 72-60-65 / (088) 856-1738 / 856-1739 | TELE FAX (088) 856-4896
WEBSITE: www.ustp.edu.ph

MASTER PLUMBER

PROJECT	PROPOSED CONSTRUCTION OF SMART ACADEMIC BUILDING PHASE 1, JASAAN CAMPUS
LOCATION	USTP JASAAN CAMPUS, MISAMIS ORIENTAL
OWNER	UNIVERSITY OF SCIENCE AND TECHNOLOGY OF SOUTHERN PHILIPPINES

RECOMMENDING APPROVAL:
[Signature]
ENGR. GRACE C. BABA
DIRECTOR, INFRASTRUCTURE PLANNING & FACILITIES DEVELOPMENT OFFICE


RECOMMENDING APPROVAL:
[Signature]
ATTY. ERWIN B. BUCIO
VP FOR ADMINISTRATION & LEGAL AFFAIRS

APPROVED BY:
[Signature]
DR. AMBROSIO B. CULTURA II
PRESIDENT, USTP SYSTEM

SHEET CONTENTS:
ISOMETRIC VIEW:
WATER LINE LAYOUT

DRAWN BY:	
DATE DRAWN:	10.01.2025
FWT:	

P8

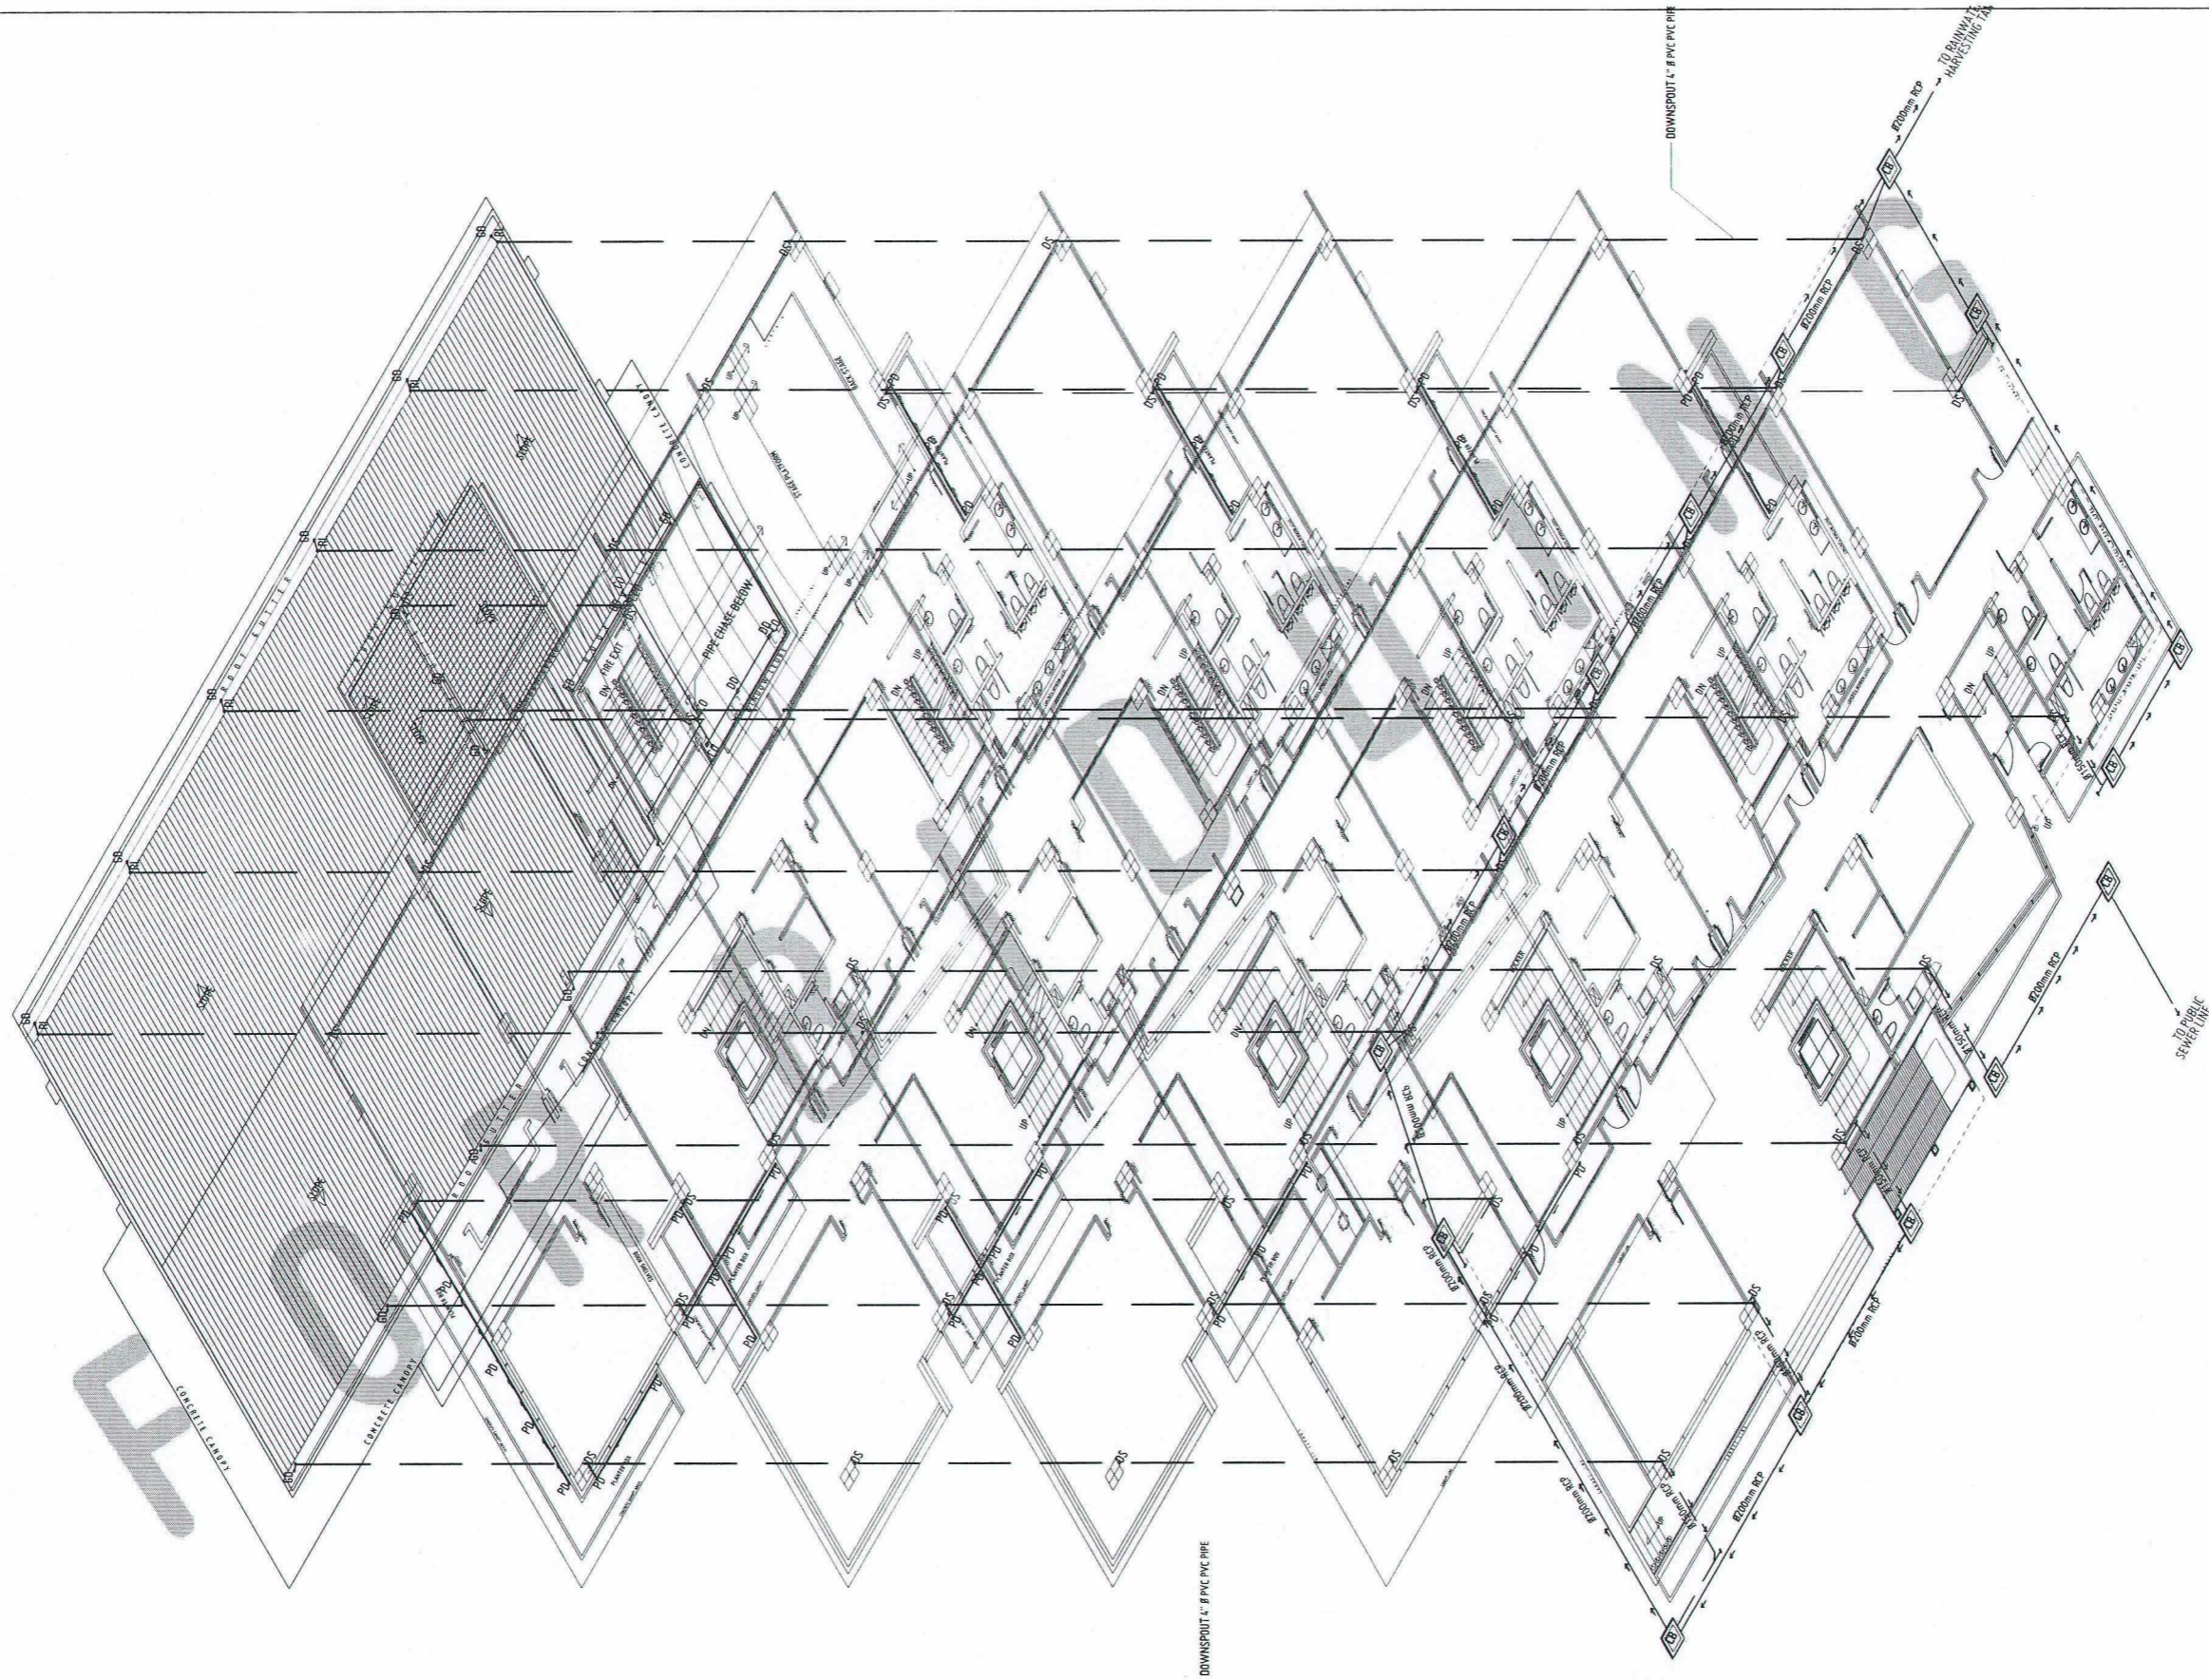

ISOMETRIC VIEW - STORM DRAIN LAYOUT
SCALE: 1/8" = 1'-0"
NTS



REPUBLIC OF THE PHILIPPINES
UNIVERSITY OF SCIENCE AND TECHNOLOGY OF SOUTHERN PHILIPPINES
CAGAYAN DE ORO CAMPUS
INFRASTRUCTURE PLANNING AND FACILITY DEVELOPMENT UNIT
CLARO M. RECTO AVENUE, LAPASAN, CAGAYAN DE ORO CITY 9000
TELEPHONE # (08822) 72-60-85 / (088) 856-1738 / 856-1739 | TELE FAX (088) 856-4896
WEBSITE: www.ustip.edu.ph

MASTER PLUMBER

PROJECT	PROPOSED CONSTRUCTION OF SMART ACADEMIC BUILDING PHASE 1, JASAAN CAMPUS
LOCATION	USTP JASAAN CAMPUS, MISAMIS ORIENTAL
OWNER	UNIVERSITY OF SCIENCE AND TECHNOLOGY OF SOUTHERN PHILIPPINES

RECOMMENDING APPROVAL:
Grace C. Baba
ENGR. GRACE C. BABA
DIRECTOR, INFRASTRUCTURE PLANNING & FACILITIES DEVELOPMENT OFFICE


RECOMMENDING APPROVAL:
Erwin B. Bucis
ATTY. ERWIN B. BUCIS
VP FOR ADMINISTRATION & LEGAL AFFAIRS

APPROVED BY:
Dr. Ambrosio B. Cultura II
DR. AMBROSIO B. CULTURA II
PRESIDENT, USTP SYSTEM


SHEET CONTENTS:
ISOMETRIC VIEW:
STORM DRAIN LAYOUT

DRAWN BY:	
DATE DRAWN:	10.01.2025
INT.	


P9

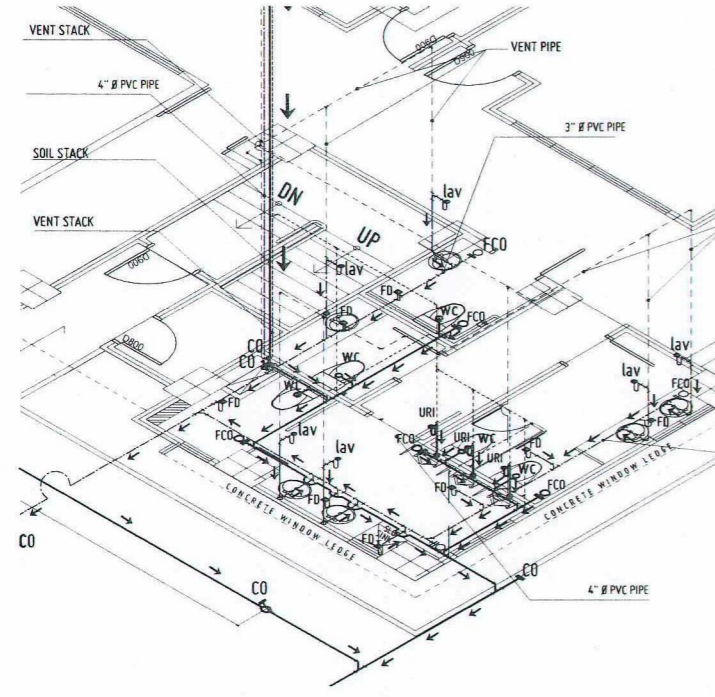


P 10 1
BLOWUP - SOIL & WASTE ISOMETRIC VIEW
ZONE 1 GROUND FLOOR - PUBLIC TOILETS
SCALE: NTS

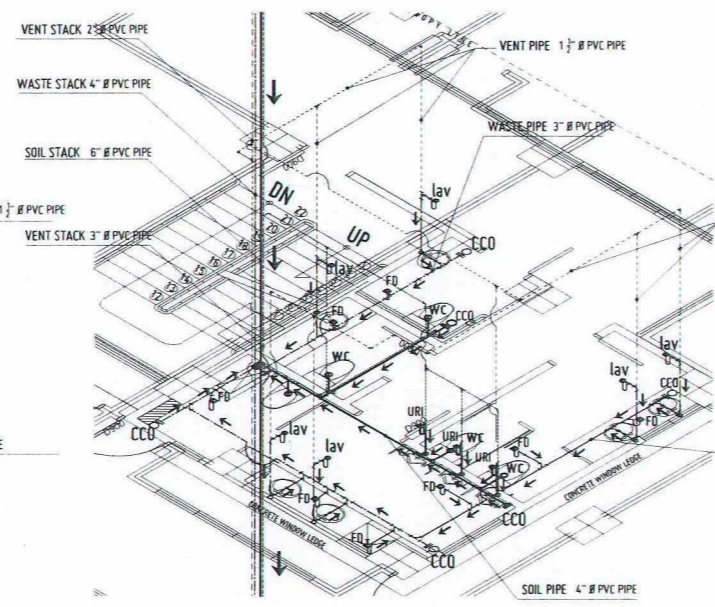


P 10 2
TYPICAL BLOWUP - SOIL & WASTE ISOMETRIC VIEW
ZONE 1 2ND FLR TO 5TH FLR - PUBLIC TOILETS
SCALE: NTS

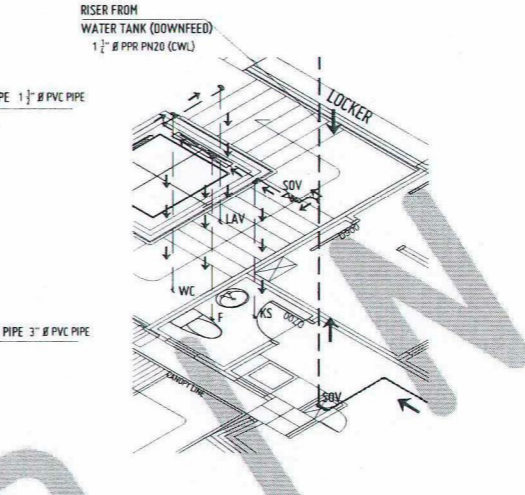


P 10 5
BLOWUP - WATERLINE ISOMETRIC VIEW
ZONE 2 GROUND FLOOR - OFFICE TOILET
SCALE: NTS

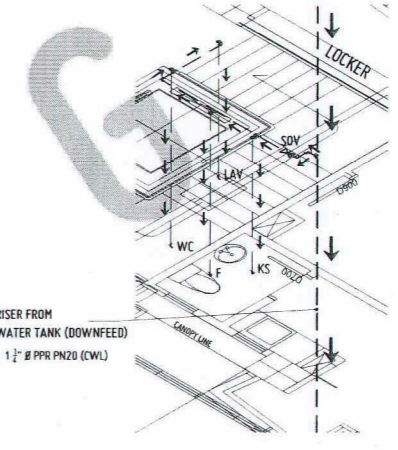


P 10 6
TYPICAL BLOWUP - WATERLINE ISOMETRIC VIEW
ZONE 2 2ND FLR TO 5TH FLR - OFFICE TOILETS
SCALE: NTS

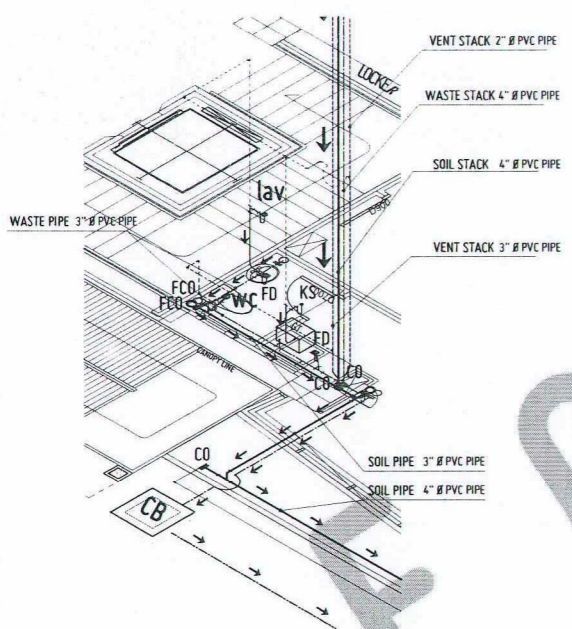


P 10 3
BLOWUP - SOIL & WASTE ISOMETRIC VIEW
ZONE 2 GROUND FLOOR - OFFICE TOILET
SCALE: NTS

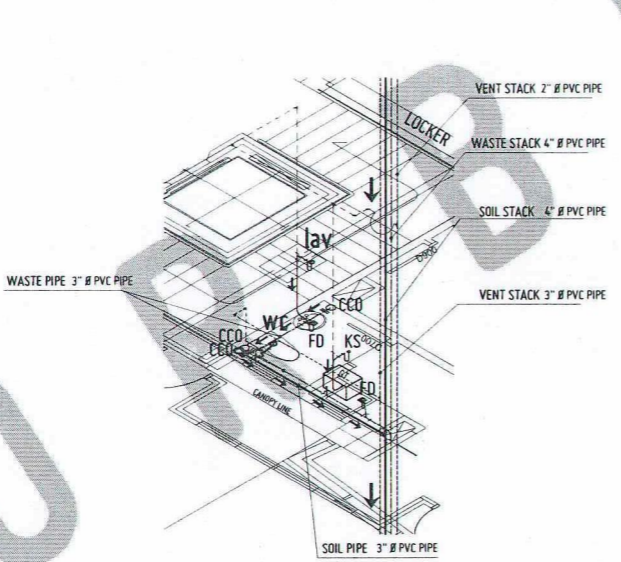

P 10 4
TYPICAL BLOWUP - SOIL & WASTE ISOMETRIC VIEW
ZONE 2 2ND FLR TO 5TH FLR - OFFICE TOILETS
SCALE: NTS

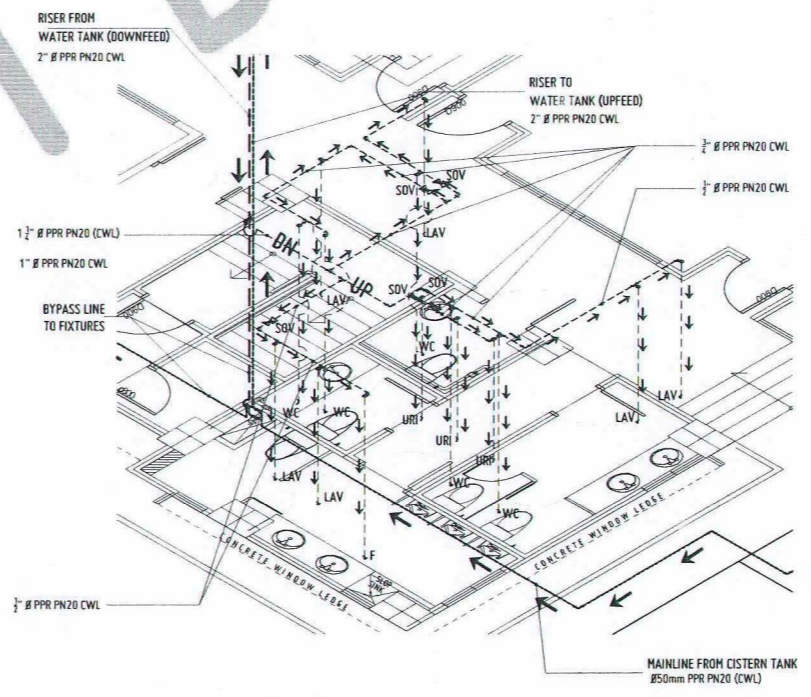

P 10 7
BLOWUP - WATERLINE ISOMETRIC VIEW
ZONE 1 GROUND FLOOR - PUBLIC TOILETS
SCALE: NTS

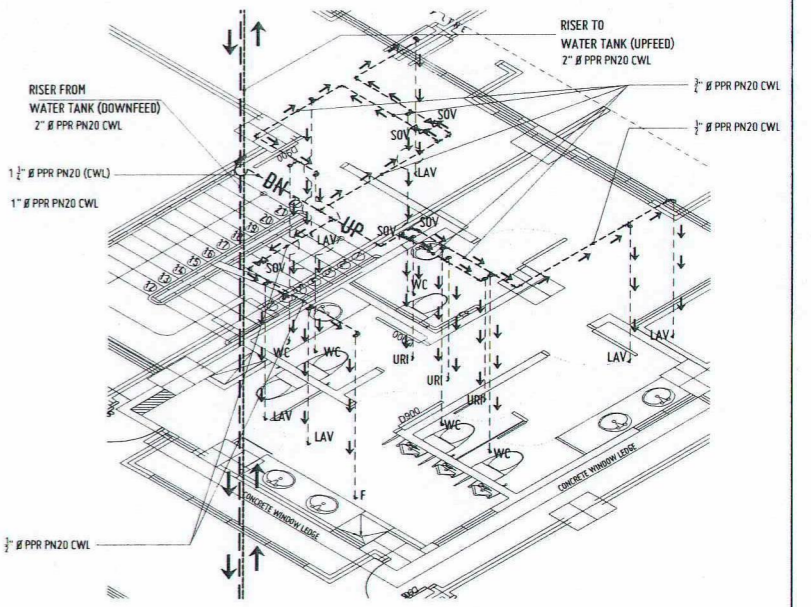

P 10 8
TYPICAL BLOWUP - WATERLINE ISOMETRIC VIEW
ZONE 1 2ND FLR TO 5TH FLR - PUBLIC TOILETS
SCALE: NTS



REPUBLIC OF THE PHILIPPINES
UNIVERSITY OF SCIENCE AND TECHNOLOGY OF SOUTHERN PHILIPPINES
CAGAYAN DE ORO CAMPUS
INFRASTRUCTURE PLANNING AND FACILITY DEVELOPMENT UNIT
CLARDO M. RECTO AVENUE, LAPASAN, CAGAYAN DE ORO CITY 9000
TELEPHONE # (08822) 72-60-65 / (088) 856-1738 / 856-1735 | TELE FAX (088) 856-4656
WEBSITE: www.ustp.edu.ph

MASTER PLUMBER

PROJECT	PROPOSED CONSTRUCTION OF SMART ACADEMIC BUILDING PHASE 1, JASAAN CAMPUS
LOCATION	USTP JASAAN CAMPUS, MISAHIS ORIENTAL
OWNER	UNIVERSITY OF SCIENCE AND TECHNOLOGY OF SOUTHERN PHILIPPINES

RECOMMENDING APPROVAL:
Grace C. Baba
ENGR. GRACE C. BABA
DIRECTOR, INFRASTRUCTURE PLANNING & FACILITIES DEVELOPMENT OFFICE


RECOMMENDING APPROVAL:
Erwin B. Bulco
ATTY. ERWIN B. BULCO
VP FOR ADMINISTRATION & LEGAL AFFAIRS

APPROVED BY:
Dr. Ambrosio B. Cultura II
DR. AMBROSIO B. CULTURA II
PRESIDENT, USTP SYSTEM


SHEET CONTENTS:
BLOWUP ISOMETRIC DETAILS:
-SOIL & WASTE LAYOUT-
-ZONE 1 & 2 GROUND FLOOR
-ZONE 1 & 2 TYPICAL - 3RD TO 5TH
-WATERLINE LAYOUT-
-ZONE 1 & 2 GROUND FLOOR
-ZONE 1 & 2 TYPICAL - 3RD TO 5TH

DRAWN BY:	
DATE DRAWN:	10.01.2025
FWT:	

P10

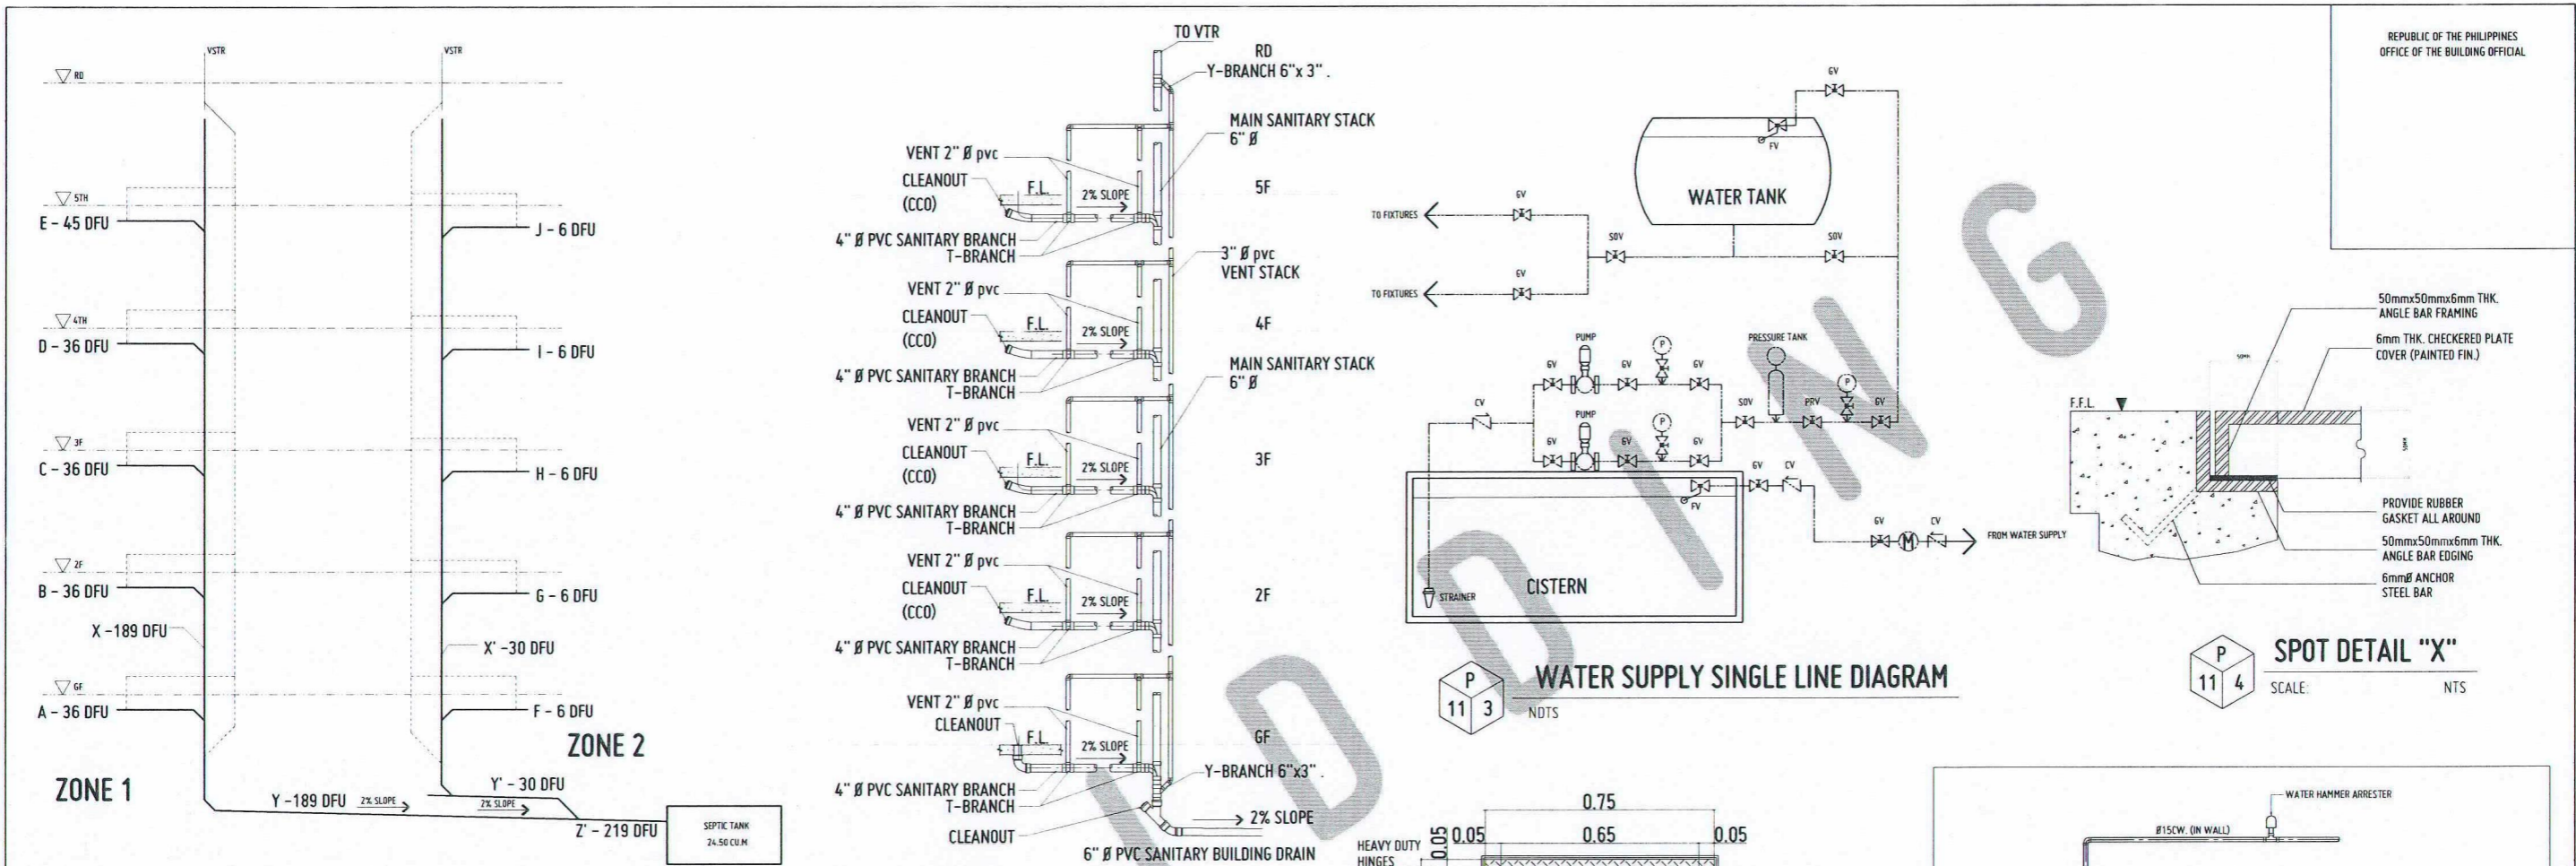


P 11 3 WATER SUPPLY SINGLE LINE DIAGRAM
SCALE: NTS


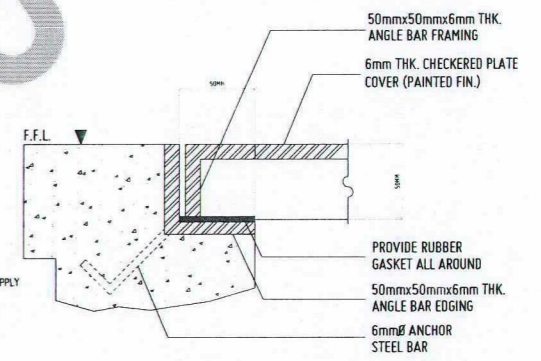


P 11 4 SPOT DETAIL "X"
SCALE: NTS


P 11 1 DRAINAGE LINE RISER DIAGRAM
SCALE: NOT DRAWN TO SCALE

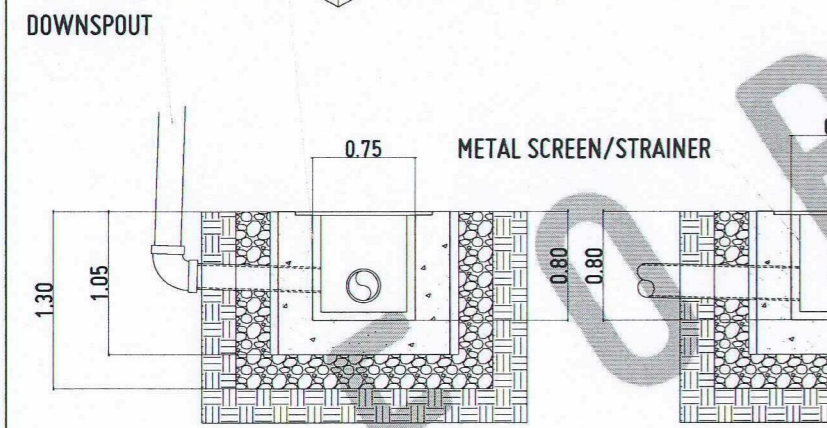

P 11 2 PLUMBING PIPING LINE DIAGRAM
SCALE: NTS

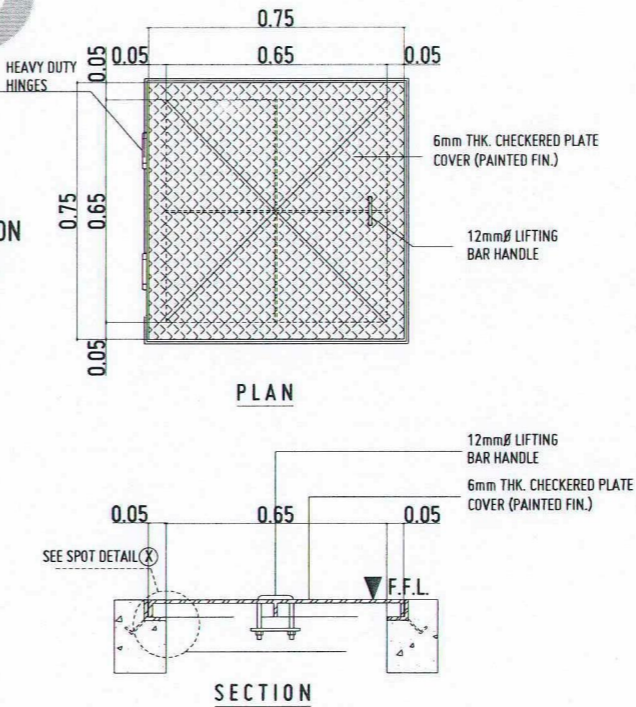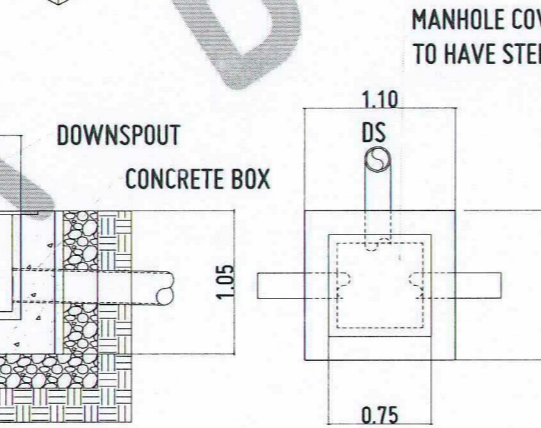

P 11 6 METAL MANHOLE COVER DETAIL
SCALE: 1:10 MTS

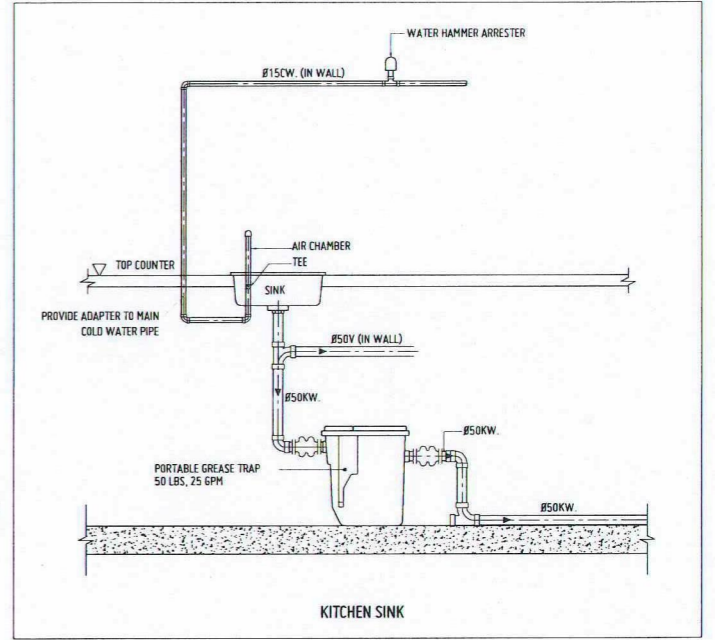

P 11 5 PORTABLE GREASE TRAP CONNECTION
SCALE: 1:10 MTS

P 11 7 CATCH BASIN DETAIL
SCALE: 1:25 MTS



REPUBLIC OF THE PHILIPPINES
UNIVERSITY OF SCIENCE AND TECHNOLOGY OF SOUTHERN PHILIPPINES
CAGAYAN DE ORO CAMPUS
INFRASTRUCTURE PLANNING AND FACILITY DEVELOPMENT UNIT
CLARO M. RECTO AVENUE, LAPASAN, CAGAYAN DE ORO CITY 9000
TELEPHONE # (08822) 72-60-65 / (088) 856-1738 / 856-1739 | TELE FAX (088) 856-4896
WEBSITE: www.ustp.edu.ph

MASTER PLUMBER
PROJECT
LOCATION
OWNER

PROPOSED CONSTRUCTION OF SMART ACADEMIC BUILDING
PHASE 1, JASAAN CAMPUS
USTP JASAAN CAMPUS, MISAMIS ORIENTAL
UNIVERSITY OF SCIENCE AND TECHNOLOGY OF SOUTHERN PHILIPPINES

RECOMMENDING APPROVAL:
ENGR. GRACE C. BABA
DIRECTOR, INFRASTRUCTURE PLANNING & FACILITIES DEVELOPMENT OFFICE

RECOMMENDING APPROVAL:
ATTY. ERWIN B. BUELO
VP FOR ADMINISTRATION & LEGAL AFFAIRS

APPROVED BY:
DR. AMBROSIO B. CULTURA II
PRESIDENT, USTP SYSTEM

SHEET CONTENTS:	DRAWN BY:
PLUMBING WASTE DIAGRAM	DATE DRAWN:
WATER SUPPLY SINGLE LINE DIAGRAM	10.01.2025
METALLIC MANHOLE COVER DETAIL	FNT:
SPOT DETAIL "X"	
CATCH BASIN DETAILS	
GREASE TRAP DETAILS	
PORTABLE GREASE TRAP CONNECTION	

P11


GENERAL NOTES & SPECIFICATIONS:

1. ALL PLUMBING WORKS SHOULD BE UNDER THE DIRECT SUPERVISION OF A LICENSED MASTER PLUMBER.
2. ALL PLUMBING INSTALLATION SHOULD BE GOVERNED BY THE NATIONAL PLUMBING CODE OF THE PHILIPPINES AND EXISTING CITY OR LOCAL ORDINANCES.
3. NO SEPTIC VAULT SHALL BE INSTALLED WITHIN OR INSIDE THE BUILDING.
4. TANK MUST BE BUILT WATER TIGHT OF CONCRETE, STONE OR C.H.B..
5. BOTH COMPARTMENTS ARE PROVIDED WITH MANHOLE AND TIGHT COVER FOR CLEANING AND REPAIRS.
6. INLET AND OUTLET ARE SUBMERGED AND ARRANGED IN SUCH A WAY THAT NIETHER SLUDGE NOR SCUM BE UNDULY DISTURBED. BOTTOM OF THE TANK SHOULD HAVE A SLOPE OF 1:10 TOWARDS THE MANHOLE IN THE CENTER TO FACILITATE CLEANING.
7. NOT LESS THAN 0.20M. OF AIRSPACE SHOULD BE LEFT BETWEEN THE TOP OF THE SEWAGE AND THE UNDER PART OF THE TANK.

Plumbing Symbol

	Corner Bathtub		Urinal (Trough-Type)
	Recessed Bathtub		Drinking Fountain (Recessed)
	Sitz Bath		Drinking Fountain (Semi-Recessed)
	Bidet		Drinking Fountain (Projecting-Type)
	Shower Stall		Hot Water Tank
	Shower Head		Water Heater
	Overhead Gang Shower		Meter
	Pedestal Lavatory		Hose Rack
	Wall Lavatory		Hose Bibb
	Corner Lavatory		Gas Outlet
	Handicapped Lavatory		Vacuum Outlet
	Dental Lavatory		Drain
	Standard Kitchen Sink		Grease Separator
	Kitchen Sink, R & L Drain Board		Oil Separator
	Kitchen Sink, L H Drain Board		Cleanout
	Combination Sink & Dishwasher		Garage Drain
	Combination Sink & Laundry Tray		Floor Drain with Backwater Valve
	Service Sink		Roof Sump
	Wash Sink (Wall-Type)		Shut-off Valve
	Wash Sink		Riser
	Laundry Tray (Single)		Gate Valve
	Laundry Tray (Double)		Check Valve
	Water Closet (Tank-Type)		Hose Bibb
	Water Closet (Integral Tank)		VS / VTW 3" PVC Pipe Series 1000
	Water Closet (Flush Valve, Floor Outlet)		SP 4" PVC Pipe Series 1000
	Water Closet (Flush Valve, Wall-Hung)		Grease Trap
	Urinal (Wall-Hung)		Catch Basin
	Urinal (Stall)		
			VS Vent Stack
			SS Soil Stack
			WS Waste Stack
			SV Septic Vault
			FD Floor Drain
			GD Gutter Drain
			DD Deck Drain
			WC Deck Drain
			lav Lavatory
			uri Urinal
			ks Kitchen Sink
			cco Ceiling Cleanout
			fco Floor Cleanout
			co Cleanout


REPUBLIC OF THE PHILIPPINES
OFFICE OF THE BUILDING OFFICIAL

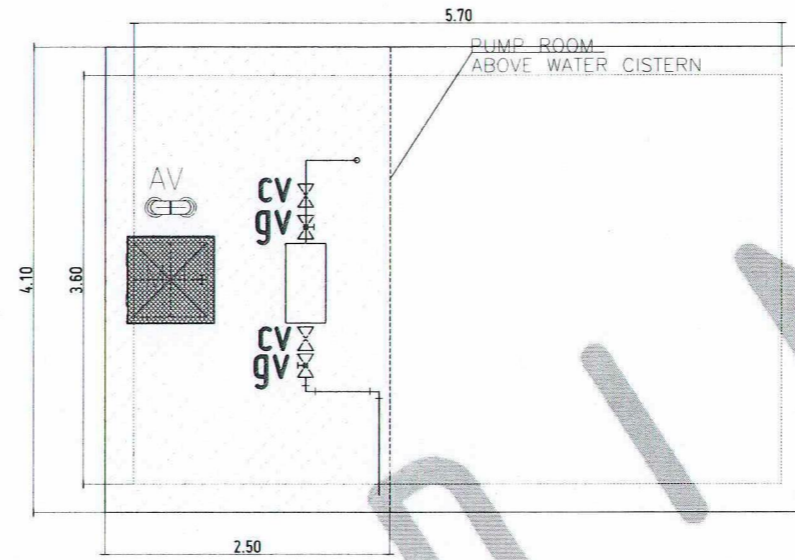

PLAN

20MM# VERTICAL BARS
SPACING @ 0.15 MTS O.C.

16MM# HORIZONTAL BARS
SPACING @ 0.15 MTS O.C.

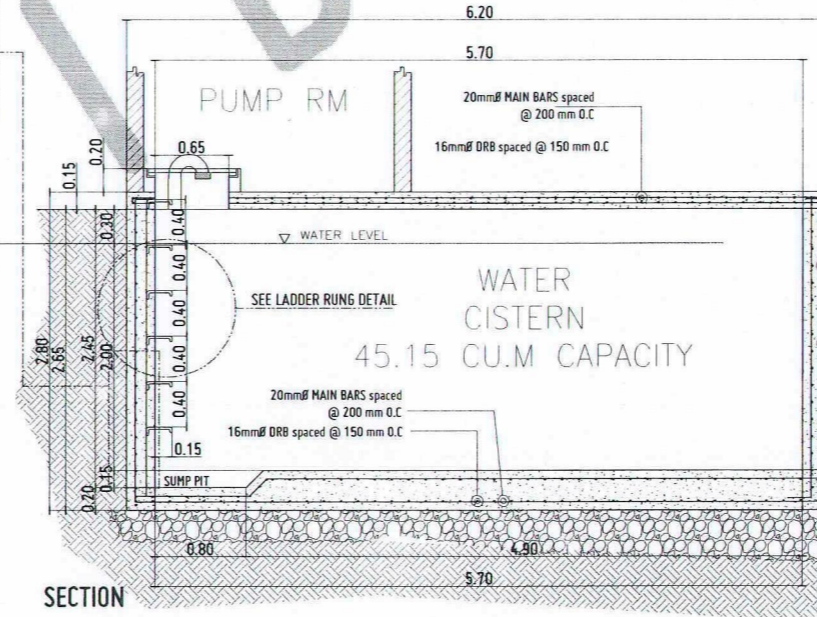


SECTION

P
12
3

WATER CISTERN DETAIL


SCALE: 1:30 MTS

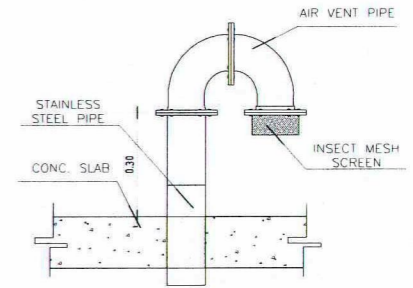

P
12
4

AIR VENT PIPE DETAIL


SCALE: 1:10 MTS

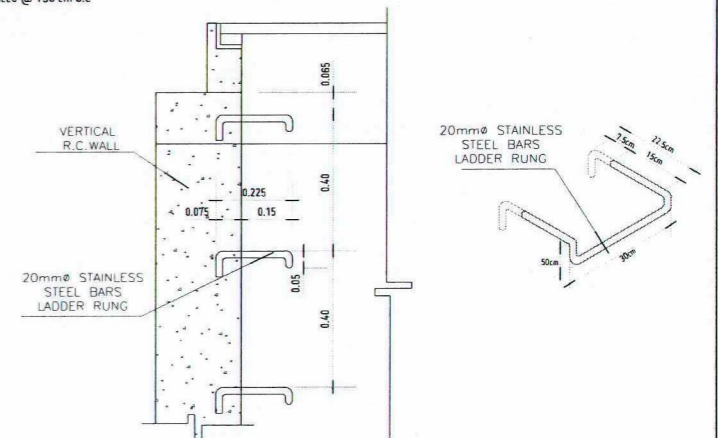

P
12
5

LADDER RUNG DETAIL


SCALE: 1:10 MTS

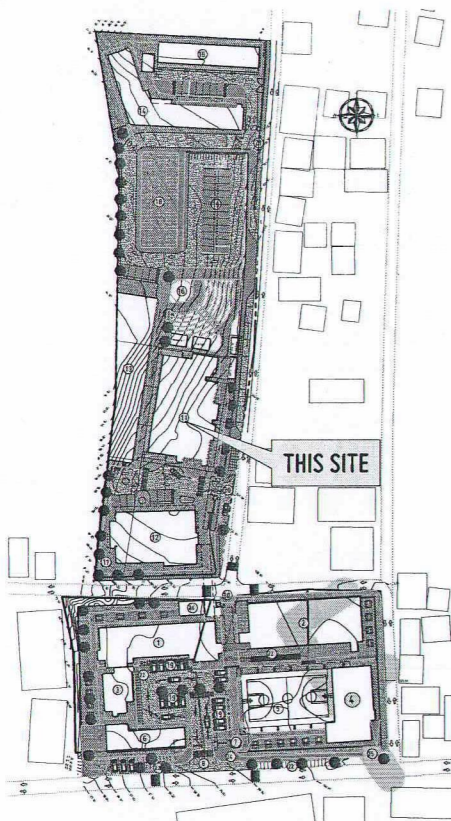

P
12
2

LOCATION PLAN

SCALE: 1:1500 MTS

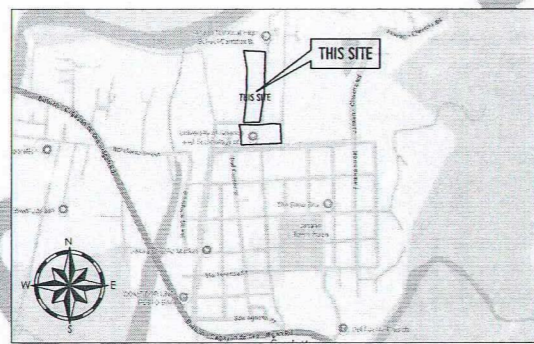

P
12
1

VICINITY MAP

SCALE: NTS



REPUBLIC OF THE PHILIPPINES
UNIVERSITY OF SCIENCE AND TECHNOLOGY OF SOUTHERN PHILIPPINES
CAGAYAN DE ORO CAMPUS
INFRASTRUCTURE PLANNING AND FACILITY DEVELOPMENT UNIT
CLARO M. RECTO AVENUE, LAPASAN, CAGAYAN DE ORO CITY 9000
TELEPHONE N (08822) 72-60-65 / (088) 856-1738 / 856-1739 | TELE FAX (088) 856-4496
WEBSITE: www.ustp.edu.ph

MASTER PLUMBER

PROJECT
LOCATION
OWNER

PROPOSED CONSTRUCTION OF SMART ACADEMIC BUILDING
PHASE 1, JASAAN CAMPUS
USTP JASAAN CAMPUS, HISAMIS ORIENTAL
UNIVERSITY OF SCIENCE AND TECHNOLOGY OF SOUTHERN PHILIPPINES

RECOMMENDING APPROVAL:

ENGR. GRACE C. BABA

RECOMMENDING APPROVAL:

ATTY. ERWIN B. BUCIO

APPROVED BY:

DR. AMBROSIO B. CULTURA II

SHEET CONTENTS:

VICINITY MAP
LOCATION PLAN
WATER CISTERN DETAILS
AIRVENT DETAILS
LADDER RUNG DETAILS




DRAWN BY:

DATE DRAWN:

10.01.2025

PN:


P12

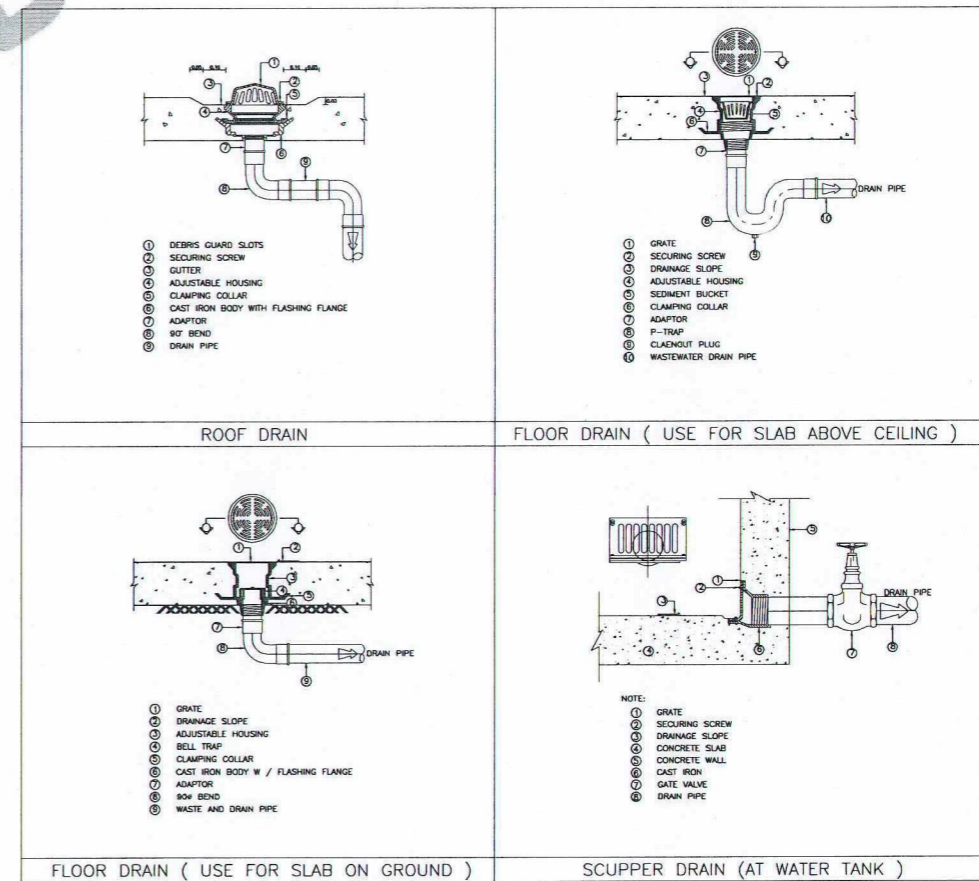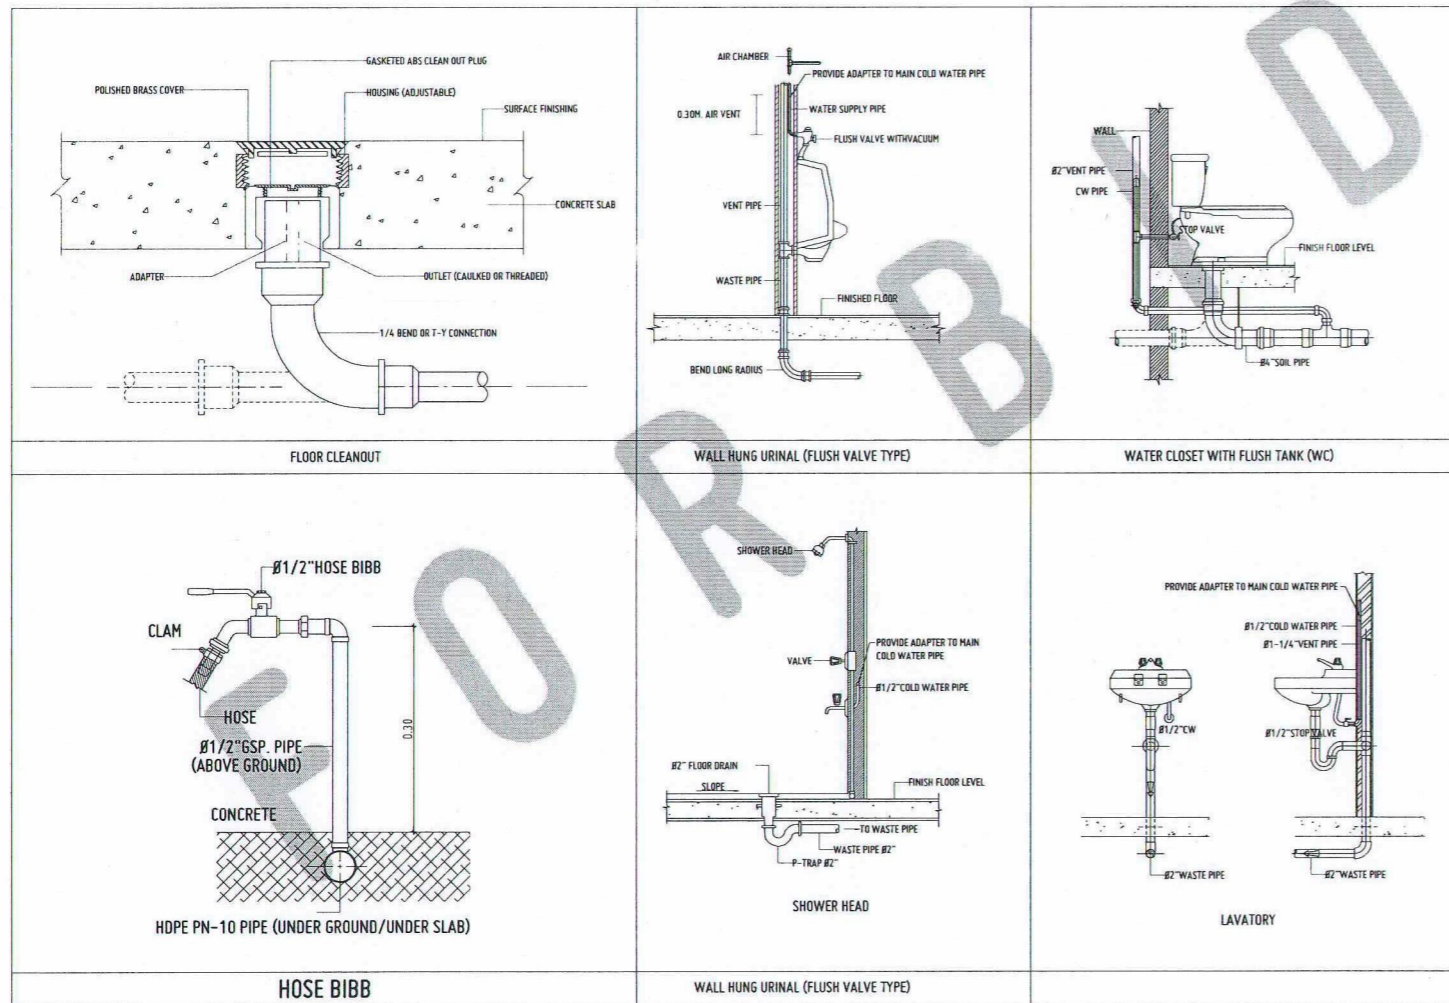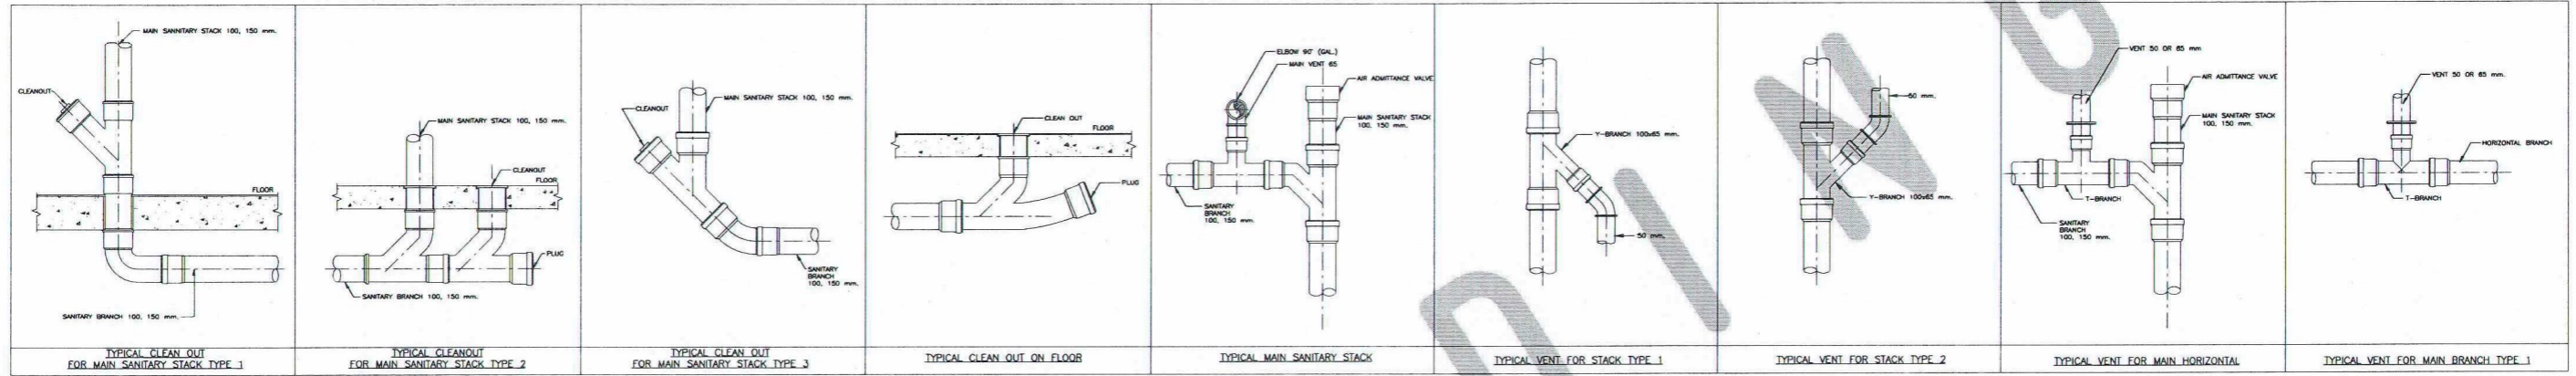

P
14
1

TOILET INSTALLATIONS & CONNECTION DETAILS

SCALE: NTS

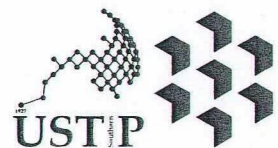

REPUBLIC OF THE PHILIPPINES
UNIVERSITY OF SCIENCE AND TECHNOLOGY OF SOUTHERN PHILIPPINES
CAGAYAN DE ORO CAMPUS
INFRASTRUCTURE PLANNING AND FACILITY DEVELOPMENT UNIT
CLARO M. RECTO AVENUE, LAPASAN, CAGAYAN DE ORO CITY 9000
TELEPHONE # (08822) 72-60-65 / (088) 856-1738 / 856-1739 | TELE FAX (088) 856-4856
WEBSITE: www.ustp.edu.ph

MASTER PLUMBER
PROJECT
LOCATION
OWNER

PROPOSED CONSTRUCTION OF SMART ACADEMIC BUILDING
PHASE 1, JASAAN CAMPUS
USTP JASAAN CAMPUS, MISAMIS ORIENTAL
UNIVERSITY OF SCIENCE AND TECHNOLOGY OF SOUTHERN PHILIPPINES

RECOMMENDING APPROVAL:
ENGR. GRACE C. BABA
DIRECTOR, INFRASTRUCTURE PLANNING & FACILITIES DEVELOPMENT OFFICE


RECOMMENDING APPROVAL:
ATTY. ERWIN B. BUCIO
VP FOR ADMINISTRATION & LEGAL AFFAIRS

APPROVED BY:
DR. AMBRASIO B. CULTURA II
PRESIDENT, USTP SYSTEM

SHEET CONTENTS:
TOILET INSTALLATIONS & CONNECTION DETAILS

DRAWN BY:
DATE DRAWN:
10.01.2025
FNT:


P14

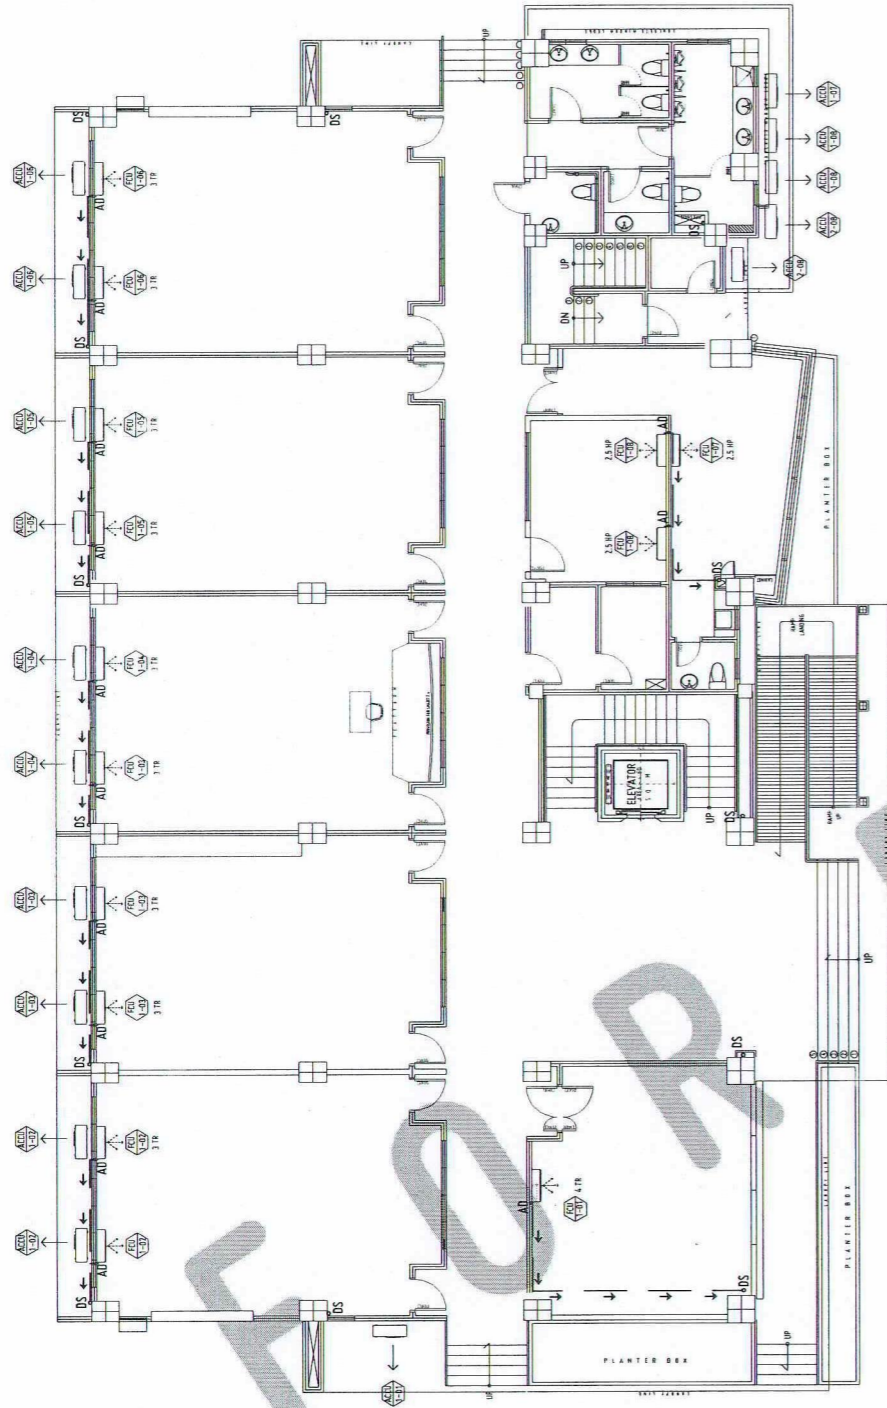

AIRCON DRAIN LAYOUT PLAN

GROUND FLOOR
SCALE: 1:100 MTS

- LEGEND:**
- 3/4" Ø PVC AIRCON DRAIN PIPE
 - DS DOWNSPOUT
 - AD AIRCON DRAIN LOCATION

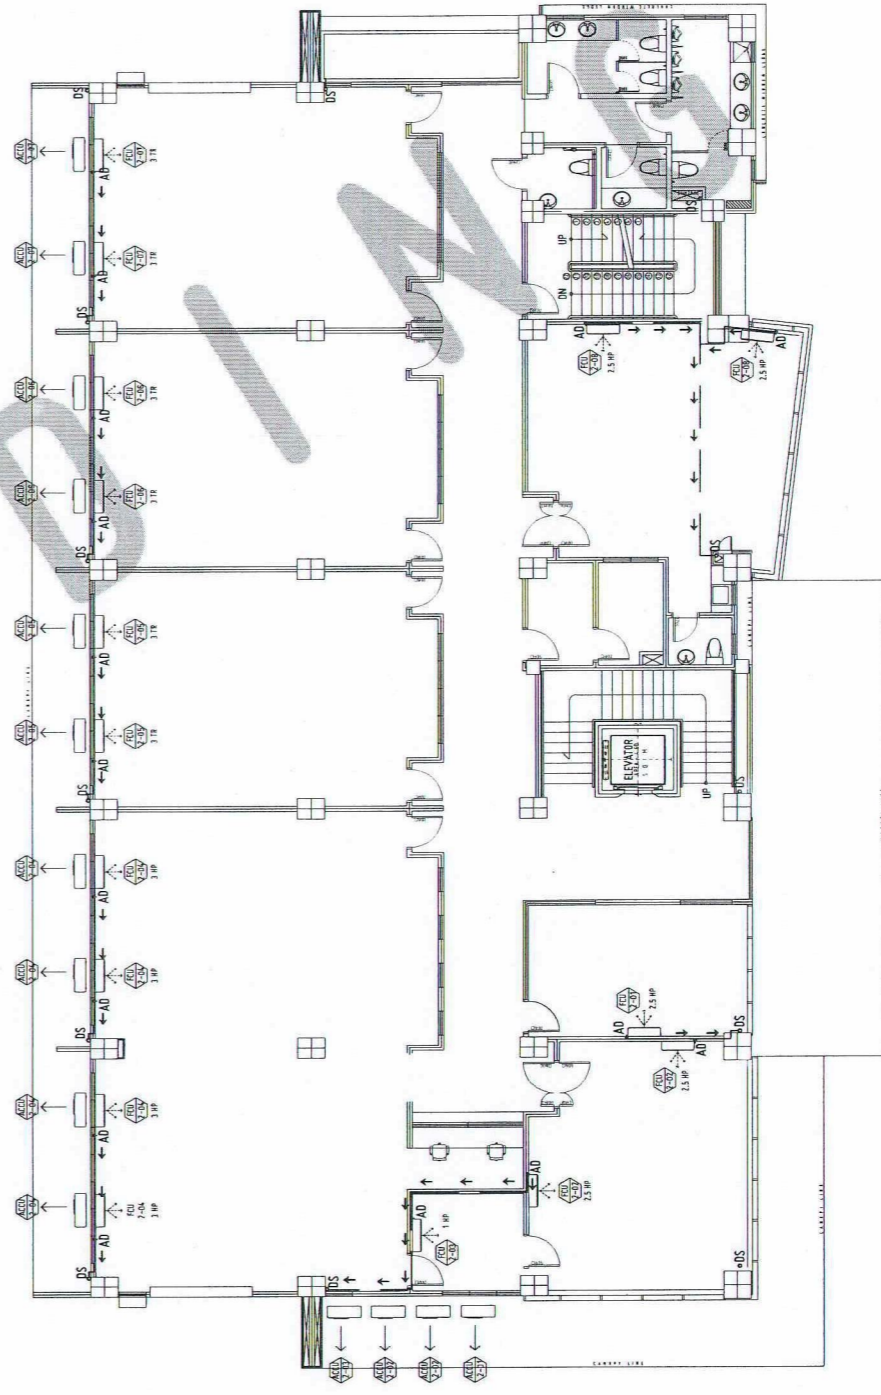

AIRCON DRAIN LAYOUT PLAN

SECOND FLOOR
SCALE: 1:100 MTS

- LEGEND:**
- 3/4" Ø PVC AIRCON DRAIN PIPE
 - DS DOWNSPOUT
 - AD AIRCON DRAIN LOCATION



REPUBLIC OF THE PHILIPPINES
UNIVERSITY OF SCIENCE AND TECHNOLOGY OF SOUTHERN PHILIPPINES
CAGAYAN DE ORO CAMPUS
INFRASTRUCTURE PLANNING AND FACILITY DEVELOPMENT UNIT
CLARO M. RECTO AVENUE, LAPASAN, CAGAYAN DE ORO CITY 9000
TELEPHONE # (08822) 72-60-65 / (088) 856-1738 / 856-1739 | TELE FAX (088) 856-4696
WEBSITE: www.ustp.edu.ph

MASTER PLUMBER
PROJECT
LOCATION
OWNER

PROPOSED CONSTRUCTION OF SMART ACADEMIC BUILDING
PHASE 1, JASAAN CAMPUS
USTP JASAAN CAMPUS, MISAMIS ORIENTAL
UNIVERSITY OF SCIENCE AND TECHNOLOGY OF SOUTHERN PHILIPPINES

RECOMMENDING APPROVAL:
Grace C. Baba
ENGR. GRACE C. BABA
DIRECTOR, INFRASTRUCTURE PLANNING & FACILITIES DEVELOPMENT OFFICE


RECOMMENDING APPROVAL:
Erwin B. Bucio
ATTY. ERWIN B. BUCIO
VP FOR ADMINISTRATION & LEGAL AFFAIRS

APPROVED BY:
Ambrosio B. Cultura II
DR. AMBROSIO B. CULTURA II
PRESIDENT, USTP SYSTEM

SHEET CONTENTS:
ACU DRAIN LAYOUT PLAN
GROUND FLOOR LAYOUT
SECOND FLOOR LAYOUT

DRAWN BY:
DATE DRAWN:
10.01.2025
PNT:

P15

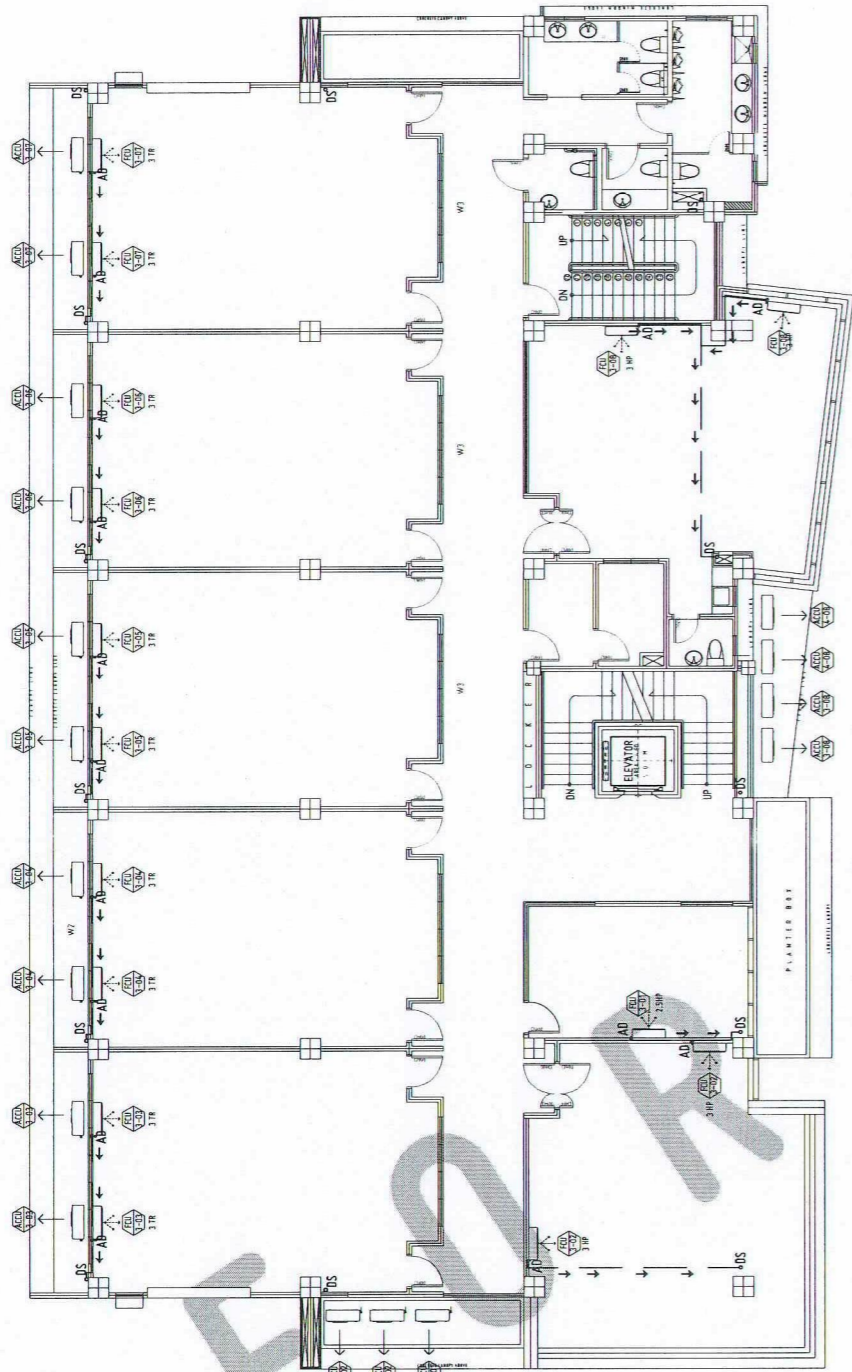


AIRCONE DRAIN LAYOUT PLAN
THIRD FLOOR

SCALE: 1:100 MTS

ME 2 1

- LEGEND:
- 3/4" Ø PVC AIRCON DRAIN PIPE
 - DS DOWNSPOUT
 - AD AIRCON DRAIN LOCATION

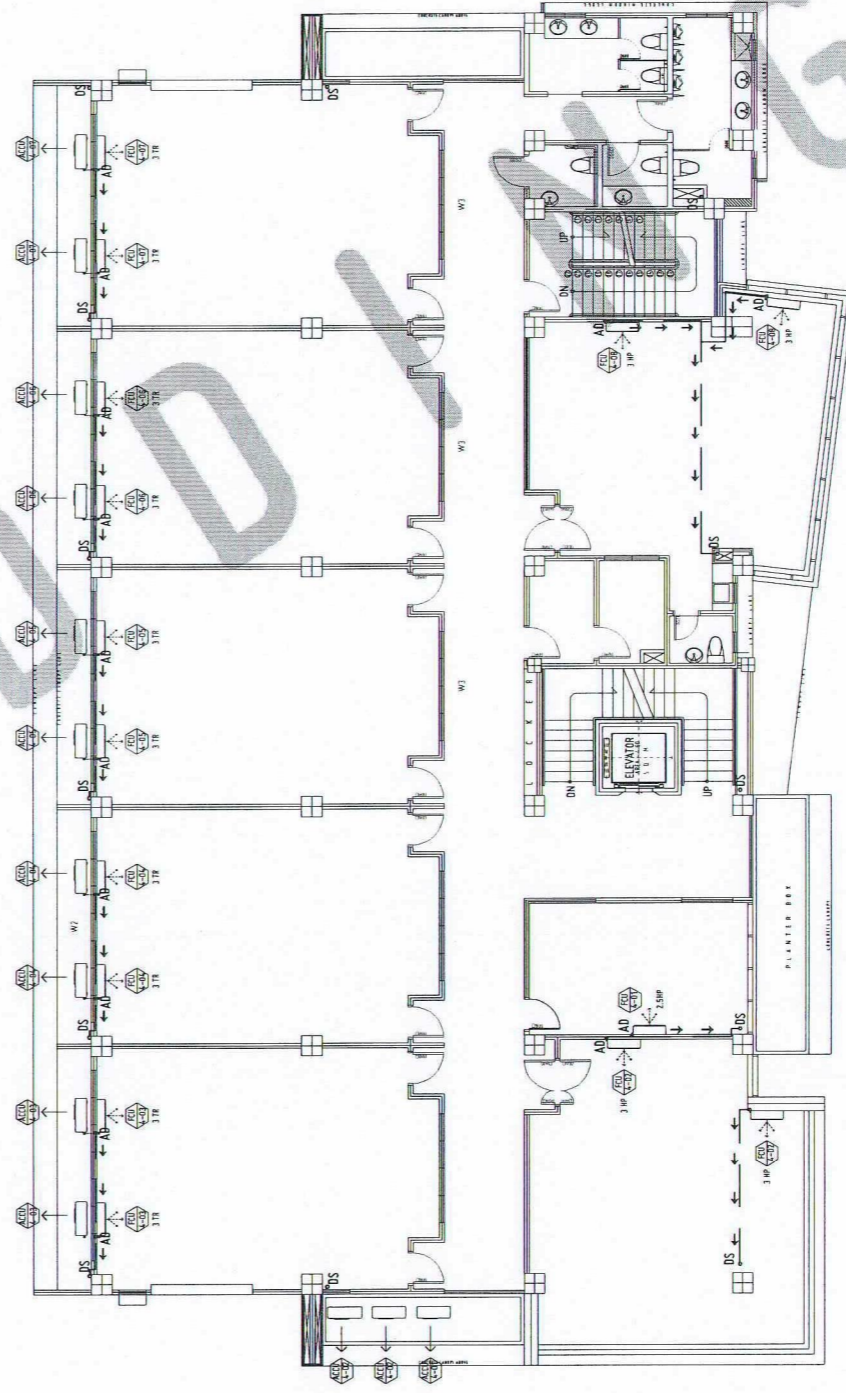

AIRCONE DRAIN LAYOUT PLAN
FOURTH FLOOR

SCALE: 1:100 MTS

ME 2 2

- LEGEND:
- 3/4" Ø PVC AIRCON DRAIN PIPE
 - DS DOWNSPOUT
 - AD AIRCON DRAIN LOCATION



REPUBLIC OF THE PHILIPPINES
UNIVERSITY OF SCIENCE AND TECHNOLOGY OF SOUTHERN PHILIPPINES
CAGAYAN DE ORO CAMPUS
INFRASTRUCTURE PLANNING AND FACILITY DEVELOPMENT UNIT
CLARO M. RECTO AVENUE, LAPASAN, CAGAYAN DE ORO CITY 9000
TELEPHONE # (08222) 72-60-65 / (088) 856-1738 / 856-1739 | TELE FAX (088) 856-4696
WEBSITE: www.ustp.edu.ph

MASTER PLUMBER
PROJECT
LOCATION
OWNER

PROPOSED CONSTRUCTION OF SMART ACADEMIC BUILDING PHASE 1, JASAAN CAMPUS
USTP JASAAN CAMPUS, MISAMIS ORIENTAL
UNIVERSITY OF SCIENCE AND TECHNOLOGY OF SOUTHERN PHILIPPINES

RECOMMENDING APPROVAL: <i>Grace C. Baba</i> ENGR. GRACE C. BABA DIRECTOR, INFRASTRUCTURE PLANNING & FACILITIES DEVELOPMENT OFFICE
--

RECOMMENDING APPROVAL: <i>Erwin B. Busico</i> ATTY. ERWIN B. BUSICO VP FOR ADMINISTRATION & LEGAL AFFAIRS
--

APPROVED BY: <i>Ambrosio B. Cultura II</i> DR. AMBROSIO B. CULTURA II PRESIDENT, USTP SYSTEM

SHEET CONTENTS: - ACU DRAIN LAYOUT PLAN - THIRD FLOOR LAYOUT - FOURTH FLOOR LAYOUT

DRAWN BY:
DATE DRAWN: 10.01.2025
FN:

P16