





1
A 1
NTS
PERSPECTIVE

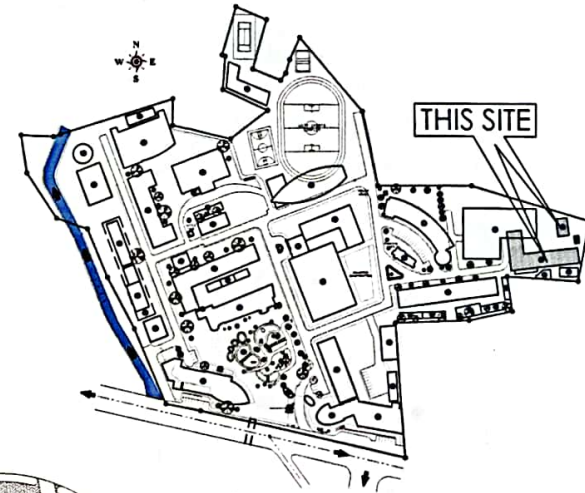

2
A 1
NTS
LOCATION PLAN

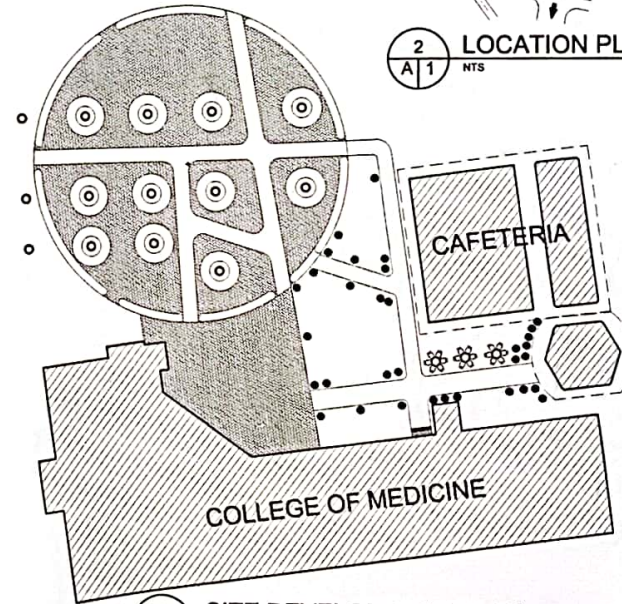

3
A 1
NTS
SITE DEVELOPMENT PLAN



REPUBLIC OF THE PHILIPPINES
UNIVERSITY OF SCIENCE & TECHNOLOGY OF
SOUTHERN PHILIPPINES
CIVIL AND SANITARY WORKS UNIT

C. M. RECTO AVENUE, LAPASAN 9000 CAGAYAN DE ORO CITY
TEL. NOS. (08622) 72-60-05 / (086) 856-1736 / 856-1739 TELE
FAX (086) 856-1696
WEB SITE: WWW.USTP.EDU.PH

PREPARED BY
[Signature]
ENGR. EDSEB LLOYD S. BALABIS
ASST. CHIEF DIRECTOR, ASW

PRC NO.:
TIN:
PTN NO.:
DATE ISSUED:

PROJECT:

PROPOSED RENOVATION OF ITB
(BLDG. 3) AS THE COLLEGE OF
MEDICINE (PHASE 2)

LOCATION: C. M. RECTO AVE., LAPASAN HIGHWAY, CAGAYAN DE ORO CITY
OWNER: UNIVERSITY OF SCIENCE & TECHNOLOGY OF SOUTHERN PHILIPPINES

NOTED BY:
[Signature]
DR. FERDINAND A. DIAZA
DIRECTOR, AUXILIARY MANAGEMENT
SERVICES

RECOMMENDING APPROVAL:
[Signature]
ATTY. JONATHAN S. OCHE
VICE CHANCELLOR FOR FINANCE
AND ADMINISTRATION

RECORDING APPROVAL:
[Signature]
ATTY. DIONEL O. ALBINA
CHANCELLOR, USTP-CAGAYAN

APPROVED:
[Signature]
DR. AMBROSIO M. CULTURA II
UNIVERSITY PRESIDENT

SHEET TITLE:
SHEET CONTENTS:
1. PERSPECTIVE
2. LOCATION PLAN
3. SITE DEVELOPMENT
PLAN
CAD BY: R.P.E.
DATE: 08-11-22

DRAWN BY: S.C.H.
DATE: 08-11-22

SHEET NO.
A
1
1
44



1-4 AVR INTERIOR PERSPECTIVE
A/3 SCALE:



REPUBLIC OF THE PHILIPPINES
UNIVERSITY OF SCIENCE & TECHNOLOGY OF
SOUTHERN PHILIPPINES
CIVIL AND SANITARY WORKS UNIT
C.M. RECTO AVENUE, LAPASAN 9000 CAGAYAN DE ORO CITY
TEL. NO. (0862) 72-00-01 / (086) 856-1758 / 856-1759 TELE
FAX (086) 856-1499
WEB SITE: WWW.USTP.EDU.PH

PREPARED BY:
ENGR. EDGEN LLOYD S. BALABIS
ASSISTANT DIRECTOR, IAW
PIC NO.:
PTR NO.:

PROJECT:
PROPOSED RENOVATION OF ITB
(BLDG. 3) AS THE COLLEGE OF
MEDICINE (PHASE 2)
LOCATION: C.M. RECTO AVE., LAPASAN HIGHWAY, CAGAYAN DE ORO CITY
OWNER: UNIVERSITY OF SCIENCE & TECHNOLOGY OF SOUTHERN PHILIPPINES

NOTED BY:
DR. FERDINAND S. JUMPA
DIRECTOR, FACILITY MANAGEMENT
SERVICES


RECOMMENDING APPROVAL:
ATTY. JONATHAN S. OCHOA
VICE CHANCELLOR FOR FINANCE
AND ADMINISTRATION

RECOMMENDING APPROVAL:
ATTY. DIONEL O. ALBINA
CHANCELLOR, USTP-CDO CAMPUS


APPROVED:
DR. AMBROSIO A. CULTURA II
UNIVERSITY PRESIDENT

SHEET TITLE:
SHEET CONTENTS:
1. AVR INTERIOR PERSPECTIVE
DRAWN BY: S.C.H.
DATE: 06-08-22
CAD BY: R.P.E.
#/26/22

SHEET NO.:
A
3
3
44

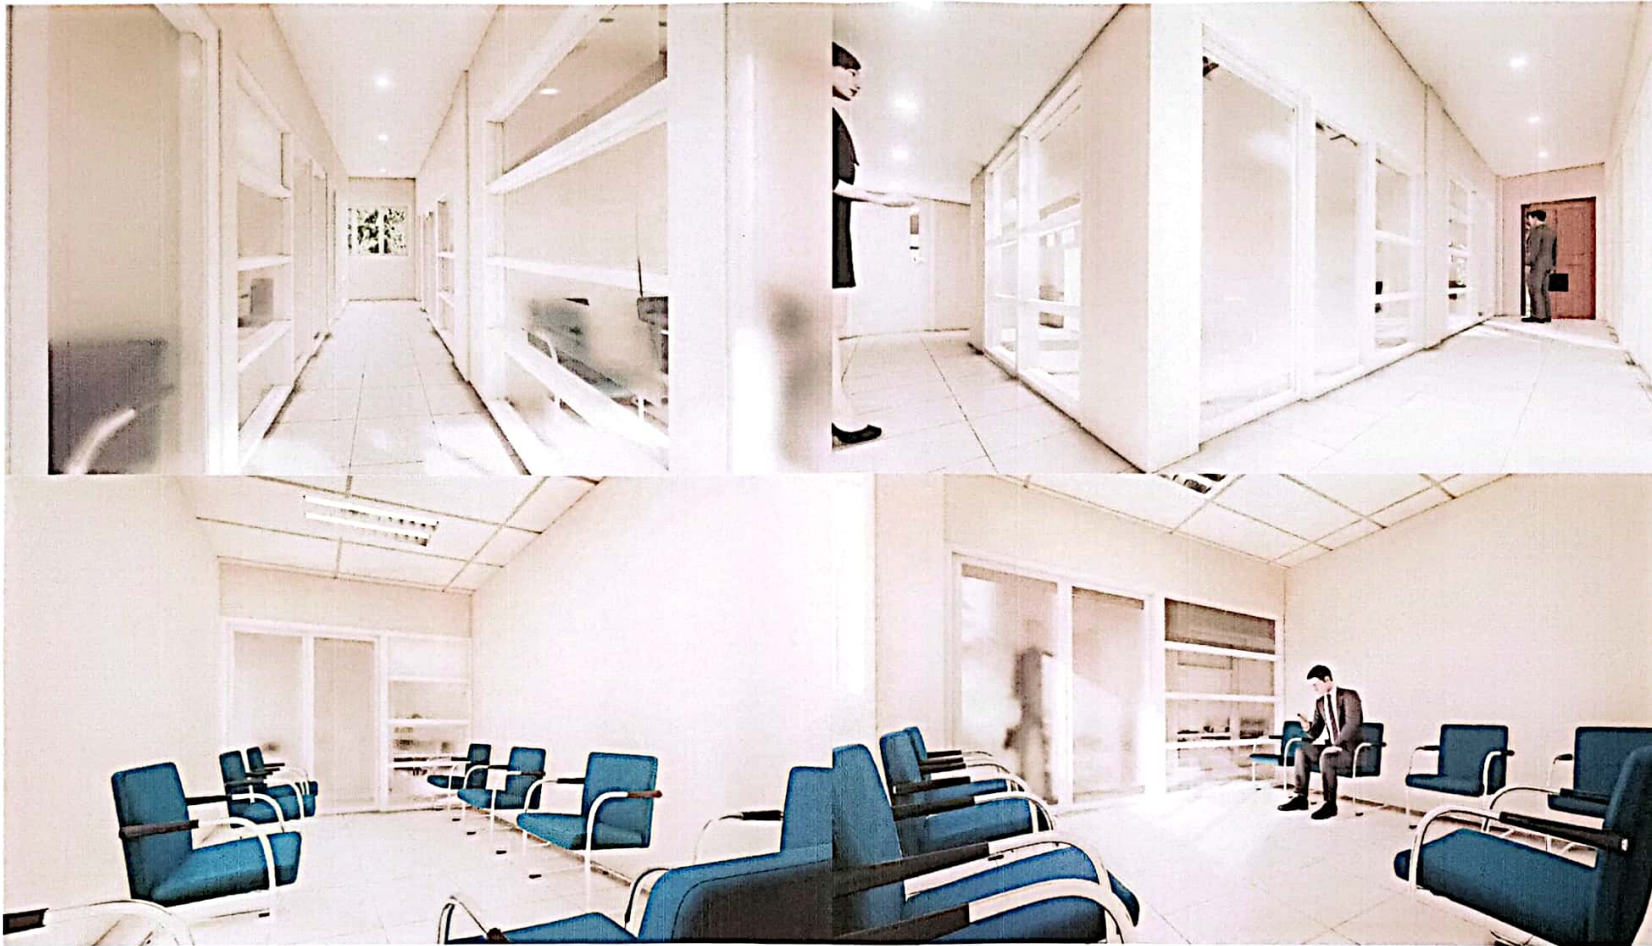
 

 
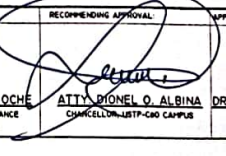
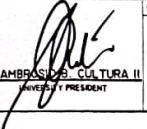



1-4 S.D.G. ROOM PERSPECTIVE
A 4 SCALE:

 <p>REPUBLIC OF THE PHILIPPINES UNIVERSITY OF SCIENCE & TECHNOLOGY OF SOUTHERN PHILIPPINES CIVIL AND SANITARY WORKS UNIT</p> <p>C.M. RECTO AVENUE, LAPASAN 9000 CAGAYAN DE ORO CITY TEL. NO. (0882) 72-05-85 / (088) 856-1736 / 856-1739 Tele FAX (088) 856-4400 WEB SITE: WWW.USTP.ORG.PH</p>	<p>PREPARED BY: <i>[Signature]</i> ENGR. EDGEN LLOYD S. BALABIS ASSISTANT DIRECTOR, SWU</p>	<p>PROJECT: PROPOSED RENOVATION OF ITB (BLDG. 3) AS THE COLLEGE OF MEDICINE (PHASE 2)</p>	<p>NOTED BY: <i>[Signature]</i> DR. BERDINANGA DUMPA DIRECTOR, AUXILIARY MANAGEMENT SERVICES</p>	<p>RECOMMENDING APPROVAL: <i>[Signature]</i> ATTY. JONATHAN S. OCHE VICE CHANCELLOR FOR FINANCE AND ADMINISTRATION</p>	<p>RECOMMENDING APPROVAL: <i>[Signature]</i> ATTY. DONNEL O. ALBINA CHANCELLOR, USTP-CDO CAMPUS</p>	<p>APPROVED: <i>[Signature]</i> DR. AMBROSIO B. CULTURA II UNIVERSITY PRESIDENT</p>	<p>SHEET TITLE: 1. S.D.G. ROOM PERSPECTIVE</p>	<p>DRAWN BY: G.C.H. DATE: 08-02-22</p>	<p>SHEET NO. A 4 45</p>
	<p>PRC NO.: PTR NO.:</p>	<p>TIN: DATE ISSUED:</p>	<p>LOCATION: OWNER:</p>	<p>C.M. RECTO AVE., LAPASAN HIGHWAY, CAGAYAN DE ORO CITY UNIVERSITY OF SCIENCE & TECHNOLOGY OF SOUTHERN PHILIPPINES</p>					




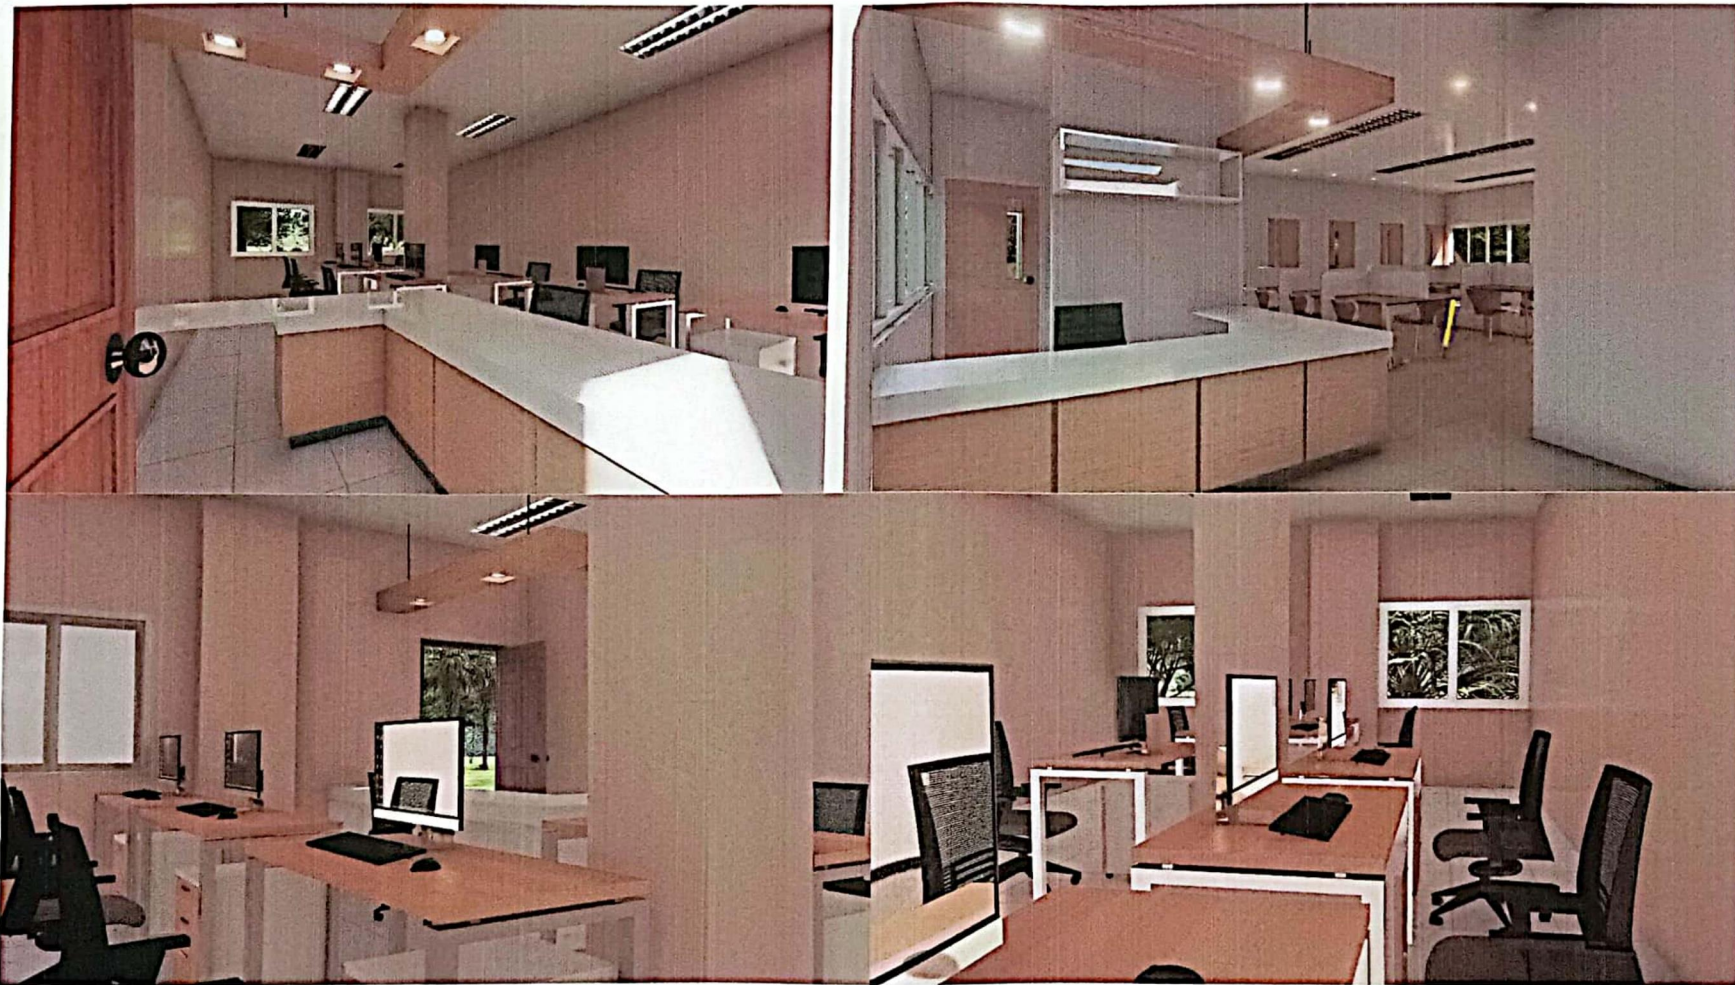
1-2 CLASSROOM INTERIOR PERSPECTIVE
 A 5 SCALE:

 <p>REPUBLIC OF THE PHILIPPINES UNIVERSITY OF SCIENCE & TECHNOLOGY OF SOUTHERN PHILIPPINES CIVIL AND SANITARY WORKS UNIT</p> <p>C.M. RECTO AVENUE, LAPASAN 9000 CAGAYAN DE ORO CITY TEL. NO. (08422) 72-80-85 / (086) 856-738 / 856-4739 TELE FAX (086) 856-4690 WEB SITE : WWW.USTP.PH</p>	PREPARED BY:  ENGR. EDEGM LLOYD S. BALANIS <small>ASSISTANT DIRECTOR, CWS</small>	PROJECT: PROPOSED RENOVATION OF ITB (BLDG. 3) AS THE COLLEGE OF MEDICINE (PHASE 2)	NOTED BY:  AR. FERDINAND A. SUMPA <small>DIRECTOR AUXILIARY MANAGEMENT SERVICE</small>	RECOMMENDING APPROVAL:  ATTY. JONATHAN S. OCHE <small>VICE CHANCELLOR FOR FINANCE AND ADMINISTRATION</small>	RECOMMENDING APPROVAL:  ATTY. DIONEL O. ALBINA <small>CHANCELLOR-USTP-CDO CAMPUS</small>	APPROVED:  DR. AMBRASIO S. CULTURA II <small>VICE CHANCELLOR FOR ACADEMIC AFFAIRS</small>	SHEET TITLE: 1. CLASSROOM INTERIOR PERSPECTIVE	DRAWN BY: S.C.H. DATE: 08-11-22 CAD BY: R.P.E. DATE: 08-11-22	SHEET NO. A 5 5 44
	PREPARED BY: ENGR. EDEGM LLOYD S. BALANIS <small>ASSISTANT DIRECTOR, CWS</small>	PROJECT: PROPOSED RENOVATION OF ITB (BLDG. 3) AS THE COLLEGE OF MEDICINE (PHASE 2)	NOTED BY: AR. FERDINAND A. SUMPA <small>DIRECTOR AUXILIARY MANAGEMENT SERVICE</small>	RECOMMENDING APPROVAL: ATTY. JONATHAN S. OCHE <small>VICE CHANCELLOR FOR FINANCE AND ADMINISTRATION</small>	RECOMMENDING APPROVAL: ATTY. DIONEL O. ALBINA <small>CHANCELLOR-USTP-CDO CAMPUS</small>	APPROVED: DR. AMBRASIO S. CULTURA II <small>VICE CHANCELLOR FOR ACADEMIC AFFAIRS</small>	SHEET TITLE: 1. CLASSROOM INTERIOR PERSPECTIVE	DRAWN BY: S.C.H. DATE: 08-11-22 CAD BY: R.P.E. DATE: 08-11-22	SHEET NO. A 5 5 44

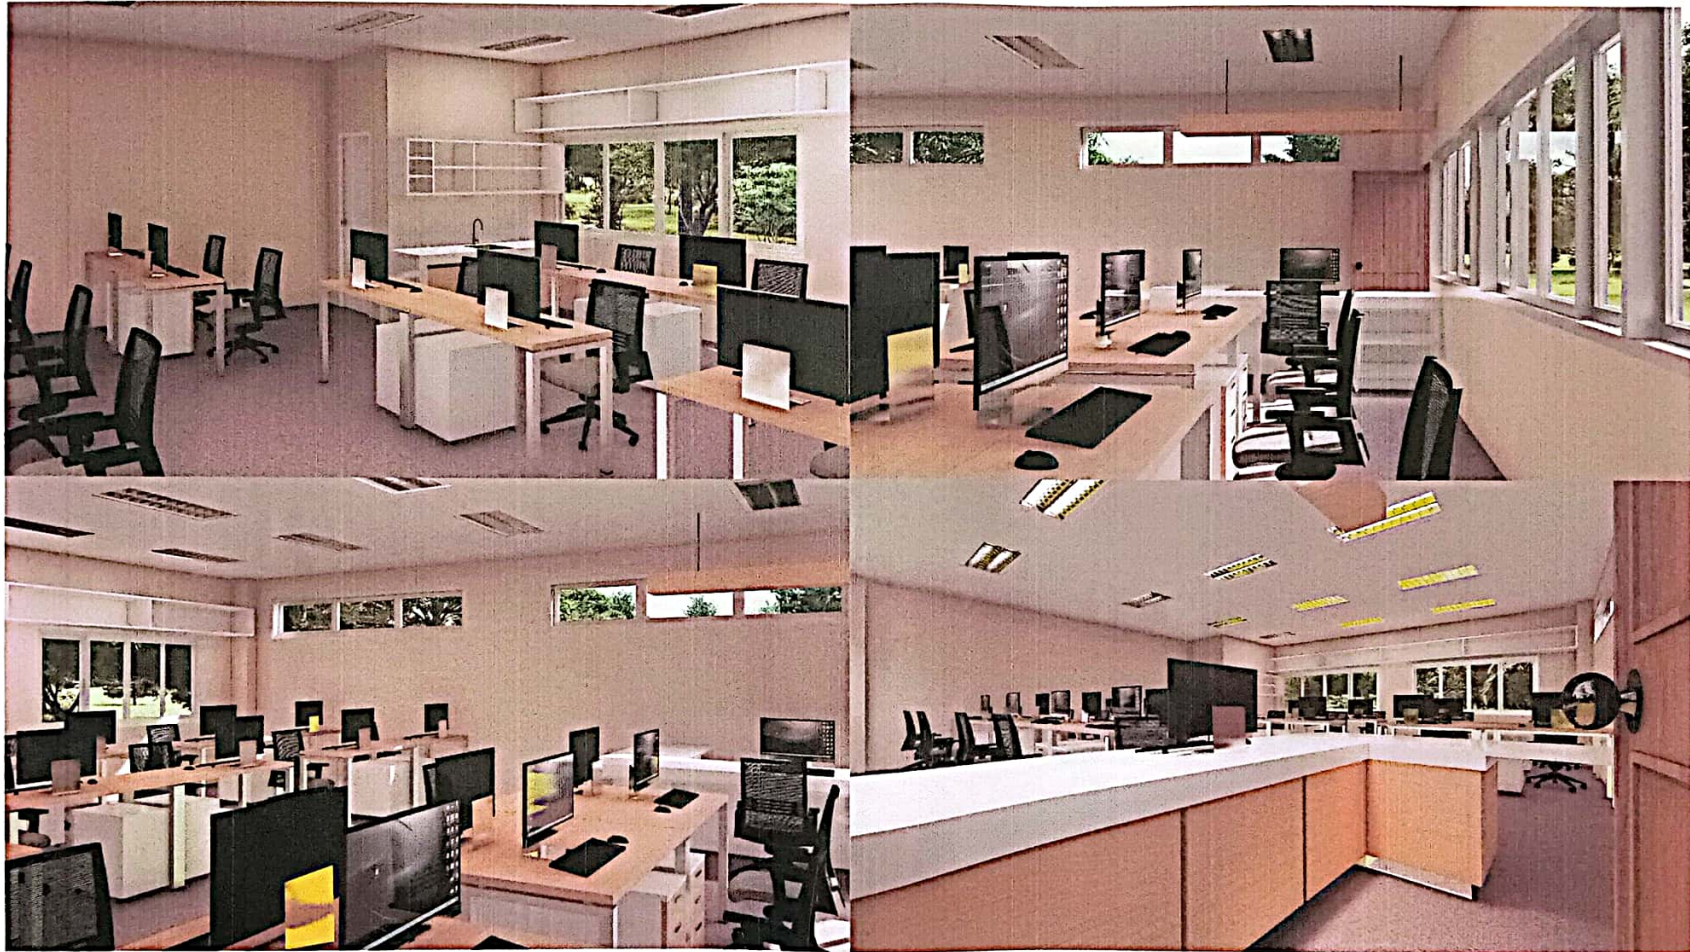

1-4 FACULTY ROOM 1 INTERIOR PERSPECTIVE
A 7 SCALE:

 <p>REPUBLIC OF THE PHILIPPINES UNIVERSITY OF SCIENCE & TECHNOLOGY OF SOUTHERN PHILIPPINES CIVIL AND SANITARY WORKS UNIT</p> <p>C.M. RECTO AVENUE, LAPASAN 9000 CAGAYAN DE ORO CITY TEL. NOS. (08822) 72-00-65 / (088) 856-1756 / 856-1759 TELE FAX (088) 856-1609 WEB SITE: WWW.USTP.PH</p>	<p>PREPARED BY: <i>[Signature]</i> ENGR. EDGEM LLOYD S. BALABIS ASSISTANT DIRECTOR, A&S</p>	<p>PROJECT: PROPOSED RENOVATION OF ITB (BLDG. 3) AS THE COLLEGE OF MEDICINE (PHASE 2)</p>	<p>NOTED BY: <i>[Signature]</i> DR. FERRINIAN B. LUMPA DIRECTOR, FACULTY MANAGEMENT SERVICES</p>	<p>RECOMMENDING APPROVAL: <i>[Signature]</i> ATTY. JONATHAN S. OCHE VICE CHANCELLOR FOR FINANCE AND ADMINISTRATION</p>	<p>RECOMMENDING APPROVAL: <i>[Signature]</i> ATTY. DIONEL O. ALBINA CHANCELLOR-USTP-CDO CAMPUS</p>	<p>APPROVED: <i>[Signature]</i> DR. AMBRAS B. CULTURA II UNIVERSITY PRESIDENT</p>	<p>SHEET TITLE: 1. FACULTY ROOM 1 INTERIOR PERSPECTIVE</p>	<p>DRAWN BY: G.C.H. DATE: 08-11-22</p>	<p>SHEET NO. A 7 7 44</p>
	<p>PHC NO. 1: _____ TR NO. 1: _____</p>	<p>LOCATION: C.M. RECTO AVE., LAPASAN HIGHWAY, CAGAYAN DE ORO CITY OWNER: UNIVERSITY OF SCIENCE & TECHNOLOGY OF SOUTHERN PHILIPPINES</p>	<p>DATE ISSUED: _____</p>	<p>DATE: 08-11-22</p>					



1-4 FACULTY ROOM 2 INTERIOR PERSPECTIVE
A/B SCALE:



REPUBLIC OF THE PHILIPPINES
UNIVERSITY OF SCIENCE & TECHNOLOGY OF SOUTHERN PHILIPPINES
CIVIL AND SANITARY WORKS UNIT
C. H. RECTO AVENUE, LAPASAN 9000 CAGAYAN DE ORO CITY
TEL. NO. (08822) 72-60-63 / (088) 856-1738 / 856-1739 TOLL
FAX (088) 856-6896
WEB SITE: WWW.USTP.EDU.PH

PREPARED BY:
[Signature]
ENGR. EDGER LLOYD S. BALABIS
ASSISTANT DIRECTOR ASW
PROJECT:
LOCATION:
C. H. RECTO AVE., LAPASAN HIGHWAY, CAGAYAN DE ORO CITY
OWNER:
UNIVERSITY OF SCIENCE & TECHNOLOGY OF SOUTHERN PHILIPPINES

PROPOSED RENOVATION OF ITB (BLDG. 3) AS THE COLLEGE OF MEDICINE (PHASE 2)

NOTED BY:
[Signature]
AR. FERDINAND S. DUMPA
DIRECTOR, ASSESSMENT AND MANAGEMENT SERVICES


RECOMMENDING APPROVAL:
[Signature]
AILEY JONATHAN S. OCHE
VICE CHANCELLOR FOR FINANCE AND ADMINISTRATION

RECOMMENDING APPROVAL:
[Signature]
AILEY DIGNEL O. ALBINA
CHANCELLOR, USTP-CDO CAMPUS


APPROVED:
[Signature]
DR. AMBERLY B. CULTURA II
UNIVERSITY PRESIDENT

SHEET TITLE:
SHEET CONTENTS:
1. FACULTY ROOM 2 INTERIOR PERSPECTIVE
DRAWN BY: G. C. H.
DATE: 08-11-22
CAD BY: R.P.E.
DATE: 08-11-22

SHEET NO.
A/8
8/44

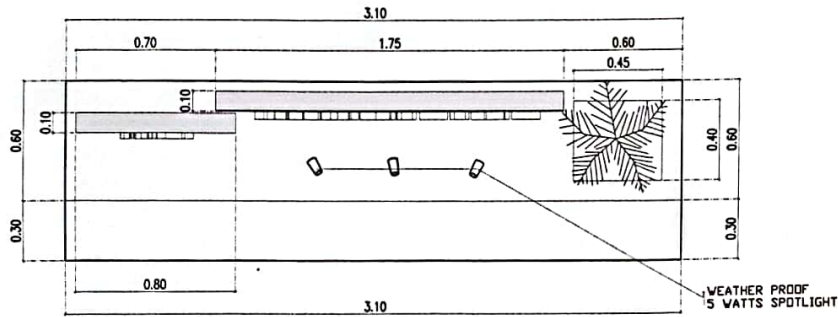


SIGNAGE TOP VIEW
SCALE:

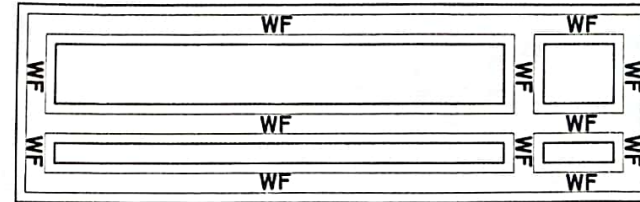


SIGNAGE FOOTING PLAN
SCALE:

LED LOGO LIGHT
ACRYLIC GLASS BODY SLIM LINE
CONSTRUCTION 50MM THK,
SCREEN PRINTED

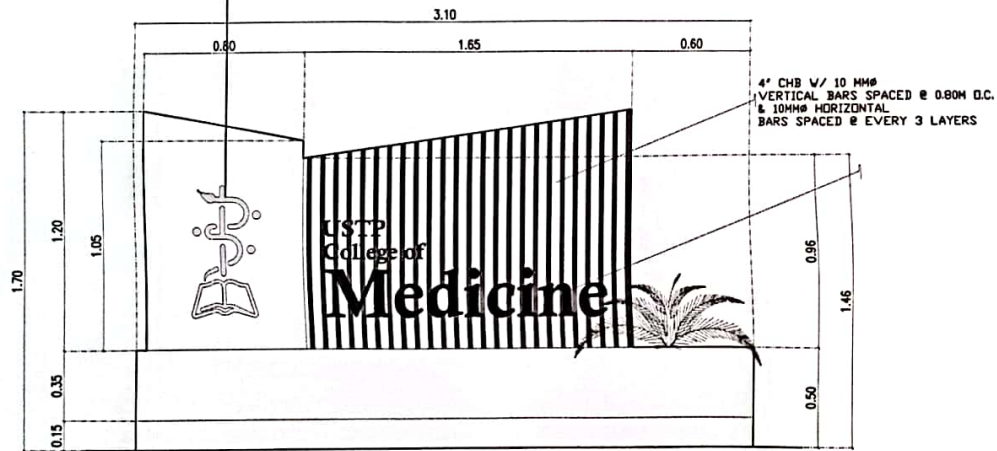

SIGNAGE FRONT VIEW
SCALE:

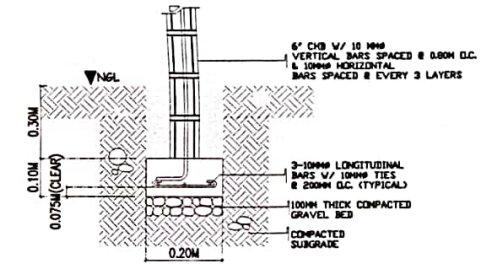

WF SECTION



REPUBLIC OF THE PHILIPPINES
UNIVERSITY OF SCIENCE & TECHNOLOGY OF
SOUTHERN PHILIPPINES
CIVIL AND SANITARY WORKS UNIT
C. H. RECTO AVENUE, LAPASAN 9008 CAGAYAN DE ORO CITY
TEL. NOS. (08822) 72-90-95 / (0888) 856-1738 / 856-1739 TELS
FAX (088) 856-1696
WEB SITE: WWW.USTP.EDU.PH

DESIGNED BY:
ENGR. EDGEM LLOYD S. BALABIS
ASSISTANT DIRECTOR, SWS

PROJECT:
PROPOSED RENOVATION OF ITB
(BLDG. 3) AS THE COLLEGE OF
MEDICINE (PHASE 2)
LOCATION: C. H. RECTO AVE., LAPASAN HIGHWAY, CAGAYAN DE ORO CITY
OWNER: UNIVERSITY OF SCIENCE & TECHNOLOGY OF SOUTHERN PHILIPPINES

NOTED BY:
DR. FERDINAND A. TUMPA
DIRECTOR, ALUMNI MANAGEMENT
SERVICES


RECOMMENDING APPROVAL:
ATTY. JONATHAN S. OCHE
VICE CHANCELLOR FOR FINANCE
AND ADMINISTRATION

RECOMMENDING APPROVAL:
ATTY. DIONEL O. ALBINA
CHANCELLOR, USTP-CDO CAMPUS

APPROVED:
DR. AMBRASO S. CULTURA II
UNIVERSITY PRESIDENT

SHEET TITLE:
1. SIGNAGE DETAIL
DRAWN BY: E.C.H.
DATE: 04-19-23
CAD BY: R.P.E.
DATE: 04-19-23

SHEET NO.
1

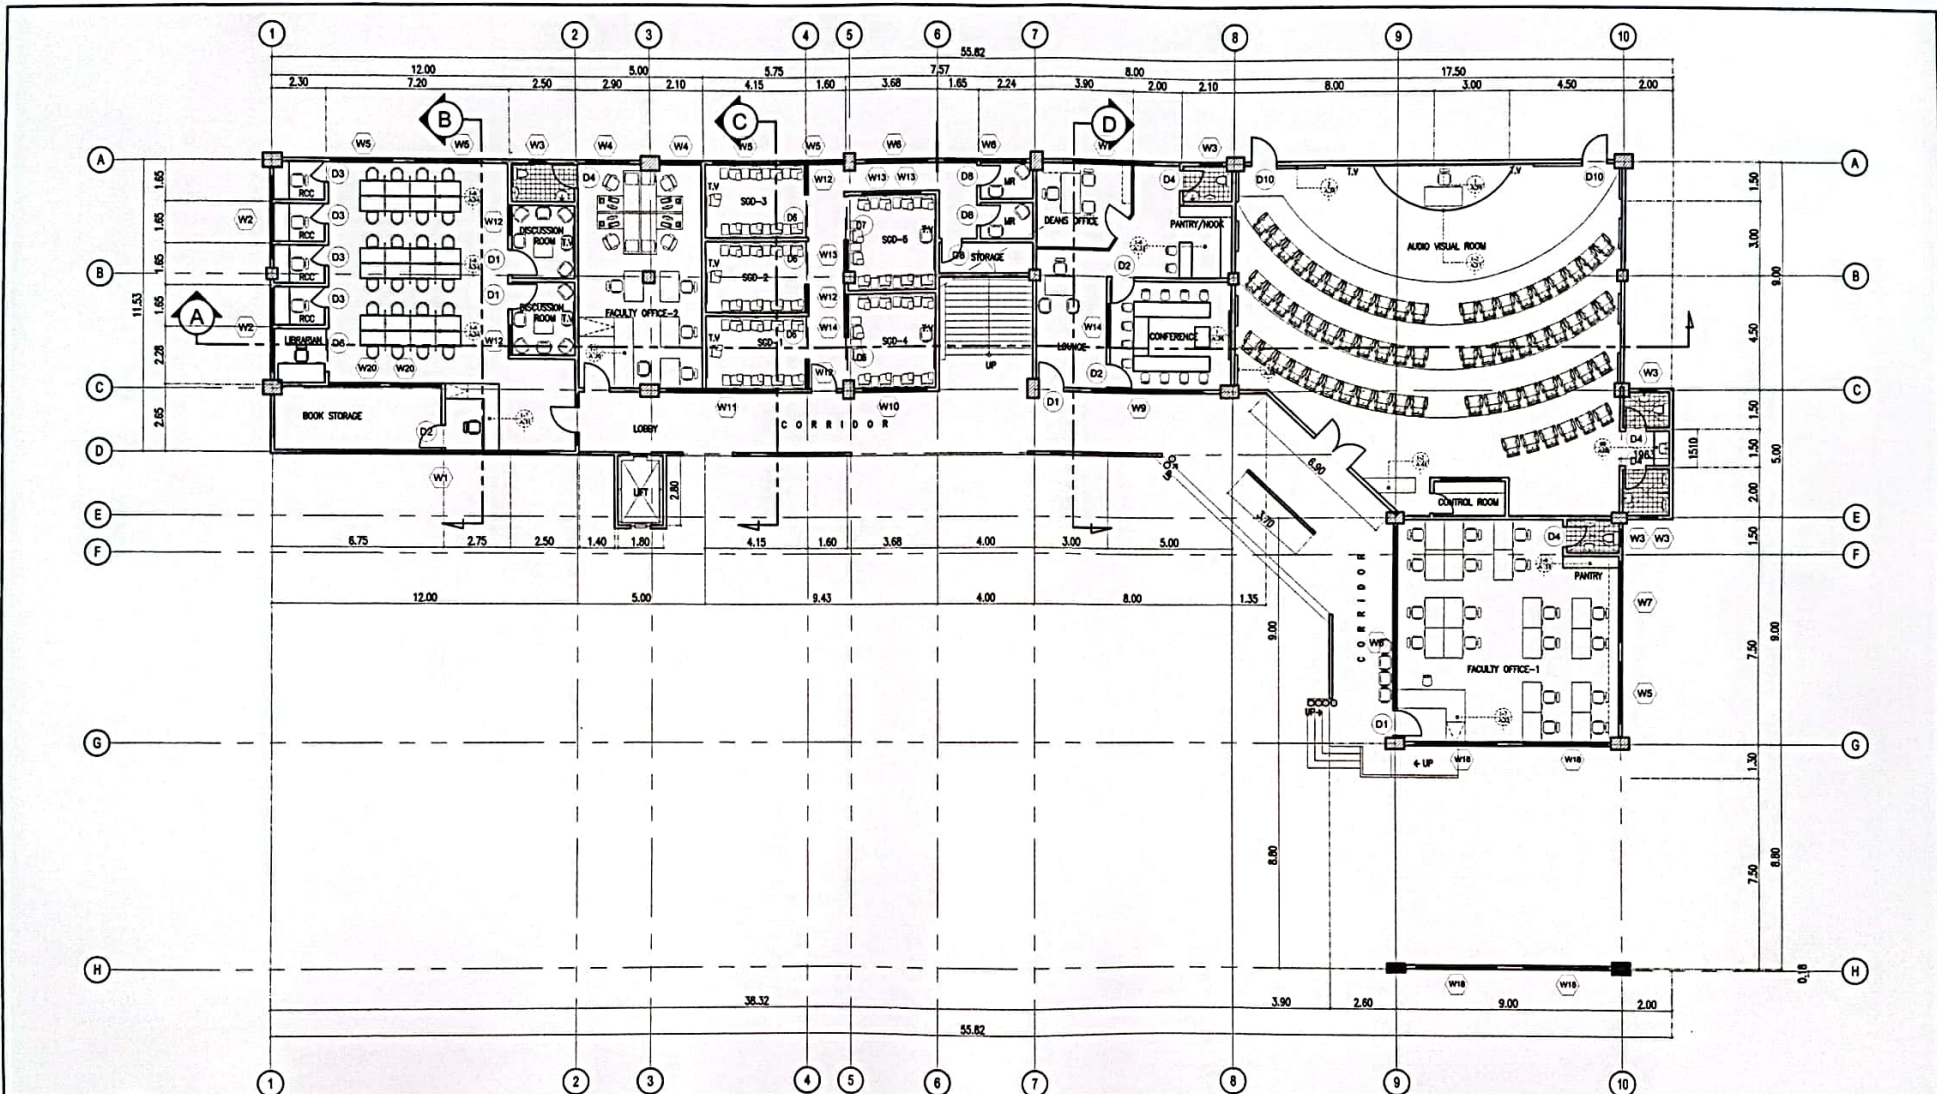

1
A/10 PROPOSED GROUND FLOOR PLAN
SCALE: 1:200M



REPUBLIC OF THE PHILIPPINES
UNIVERSITY OF SCIENCE & TECHNOLOGY OF SOUTHERN PHILIPPINES
CIVIL AND SANITARY WORKS UNIT
C. M. RECTO AVENUE, LAPASAN 9000 CAGAYAN DE ORO CITY
TEL. NO. (0882) 72-66-65 / (088) 886-1738 / 886-1739 TELE
FAX (088) 950-6076
WEB SITE: WWW.USTP.EDU.PH

PREPARED BY:
[Signature]
ENGR. EDGEM LLOYD S. BALABIS
ASSISTANT DIRECTOR, UWS

PROJECT:
PROPOSED RENOVATION OF ITB (BLDG. 3) AS THE COLLEGE OF MEDICINE (PHASE 2)

LOCATION: C.M. RECTO AVE., LAPASAN HIGHWAY, CAGAYAN DE ORO CITY
OWNER: UNIVERSITY OF SCIENCE & TECHNOLOGY OF SOUTHERN PHILIPPINES

NOTED BY:
[Signature]
MR. FERDINAND S. DUMPA
DIRECTOR, ADMINISTRATION

RECOMMENDING APPROVAL:
[Signature]
ATTY. JONATHAN S. OCHE
VICE CHANCELLOR FOR FINANCE AND ADMINISTRATION


RECOMMENDING APPROVAL:
[Signature]
ATTY. DIONESE S. ARBINA
CHANCELLOR, USTP-CDO CAMPUS

APPROVED:
[Signature]
DR. AMBRASO S. CULTURA II
PRESIDENT

SHEET TITLE:
SHEET CONTENTS:
1. PROPOSED GROUND FLOOR PLAN

DRAWN BY: S.C.H.
DATE: 08-11-22
CAD BY: R.P.R.
DATE: 08-11-22


SHEET NO.
A
10
44

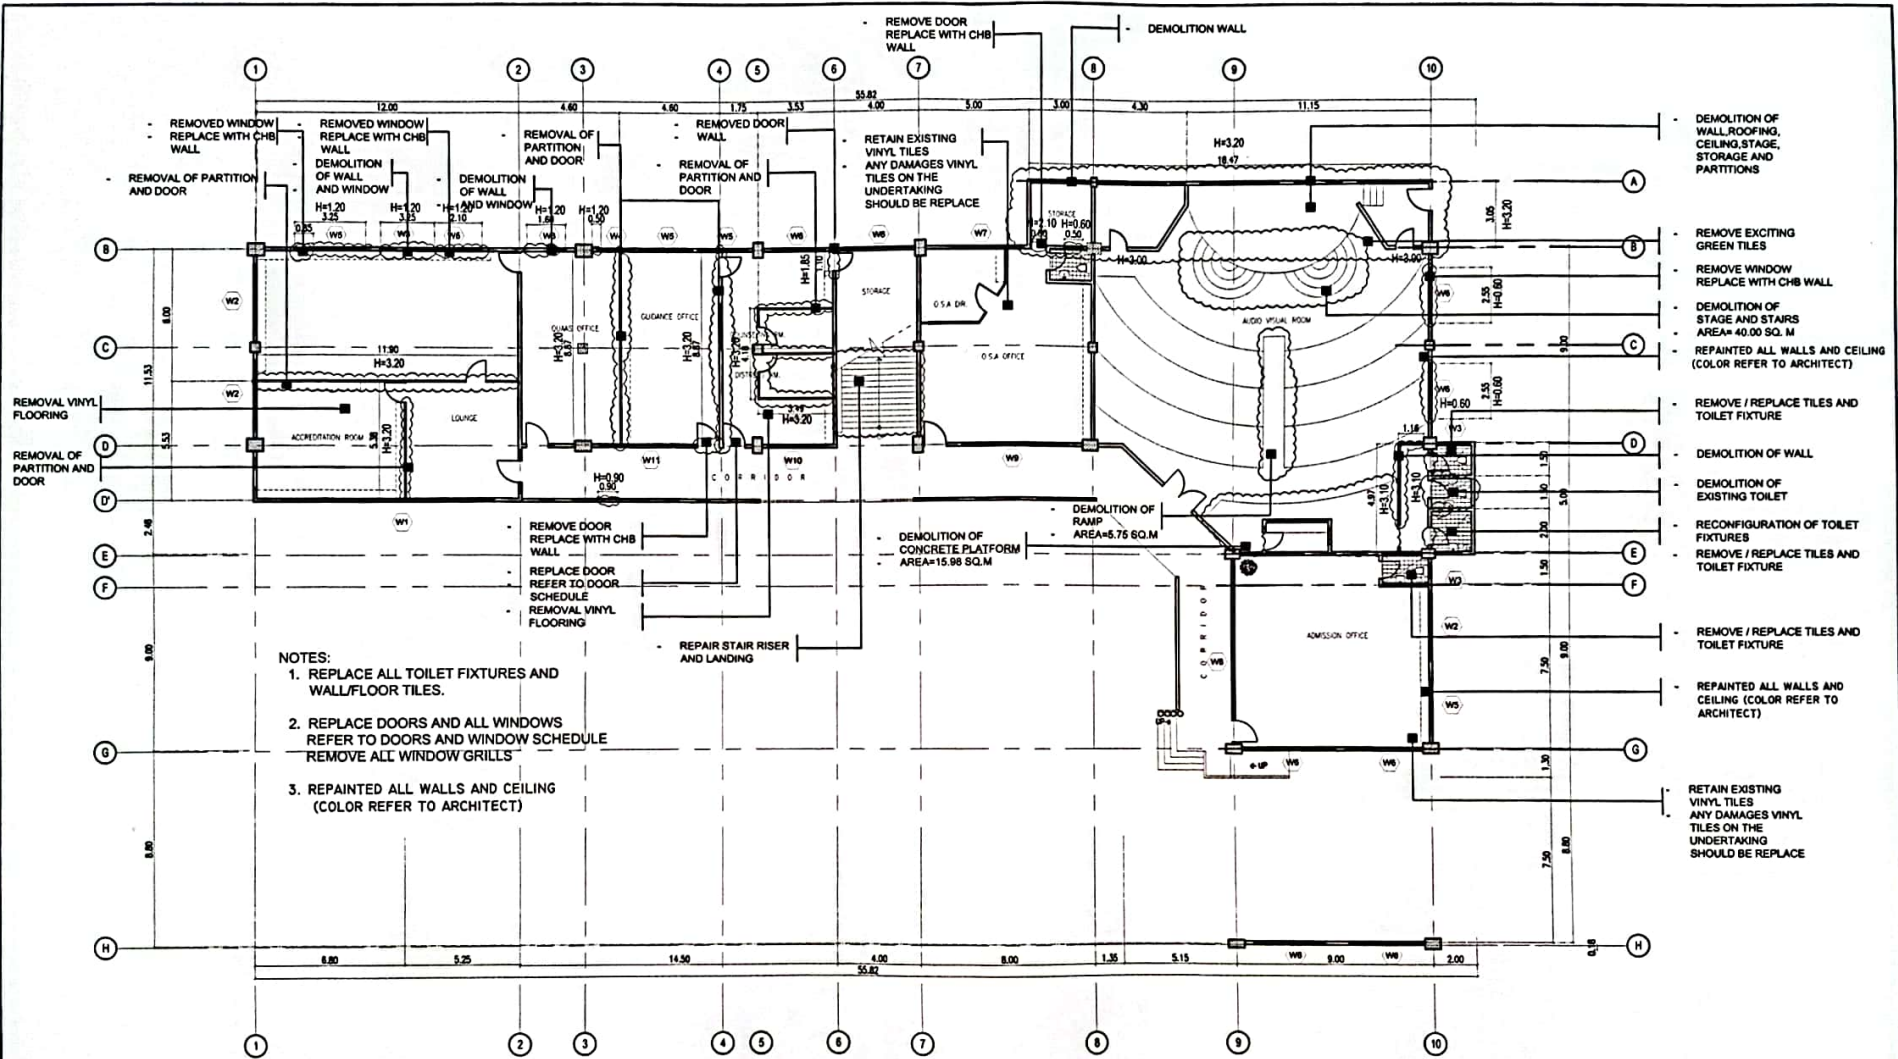

- NOTES:**
1. REPLACE ALL TOILET FIXTURES AND WALL/FLOOR TILES.
 2. REPLACE DOORS AND ALL WINDOWS REFER TO DOORS AND WINDOW SCHEDULE REMOVE ALL WINDOW GRILLS
 3. REPAINTED ALL WALLS AND CEILING (COLOR REFER TO ARCHITECT)

1
A/11 **GROUND FLOOR DEMOLITION PLAN**
SCALE: 1:200M

<p>REPUBLIC OF THE PHILIPPINES UNIVERSITY OF SCIENCE & TECHNOLOGY OF SOUTHERN PHILIPPINES CIVIL AND SANITARY WORKS UNIT C.H. RECTO AVENUE, LAPANAN 9000 CASAYAN DE ORO CITY TEL. NOS. (088) 227 72-80-85 / (088) 850-1750 / 850-1750 TILLS FAX (088) 850-1870 WEB SITE: WWW.USTP.EDU.PH</p>	<p>PREPARED BY: <i>[Signature]</i> ENGR. EDGEN LLOYD S. BALABIS ASSISTANT DIRECTOR, UWS</p>	<p>PROJECT: PROPOSED RENOVATION OF ITB (BLDG. 3) AS THE COLLEGE OF MEDICINE (PHASE 2)</p>	<p>NOTED BY: <i>[Signature]</i> AS FERNANDO S. DOMESTICO DIRECTOR, AUXILIARY MANAGEMENT SERVICES</p>	<p>RECOMMENDING APPROVAL: <i>[Signature]</i> ATTY. JONATHAN S. OCHOA VICE CHANCELLOR FOR FINANCE AND ADMINISTRATION</p>	<p>RECOMMENDING APPROVAL: <i>[Signature]</i> ATTY. GIORELO ALBINA CHANCELLOR, USTP-CAO CAMPUS</p>	<p>APPROVED: <i>[Signature]</i> DR. AMBROSIO M. LA TURRA II UNIVERSITY PRESIDENT</p>	<p>SHEET TITLE: 1. GROUND FLOOR DEMOLITION PLAN</p>	<p>DRAWN BY: S.C.H. DATE: 09-08-22 CAD BY: R.P.E. DATE: 09-08-22</p>	<p>SHEET NO. A/11 11 44</p>
	<p>PHC NO.: T/M PTM NO.: DATE ISSUED</p>	<p>LOCATION: C.H. RECTO AVE., LAPANAN HIGHWAY, CASAYAN DE ORO CITY OWNER: UNIVERSITY OF SCIENCE & TECHNOLOGY OF SOUTHERN PHILIPPINES</p>							

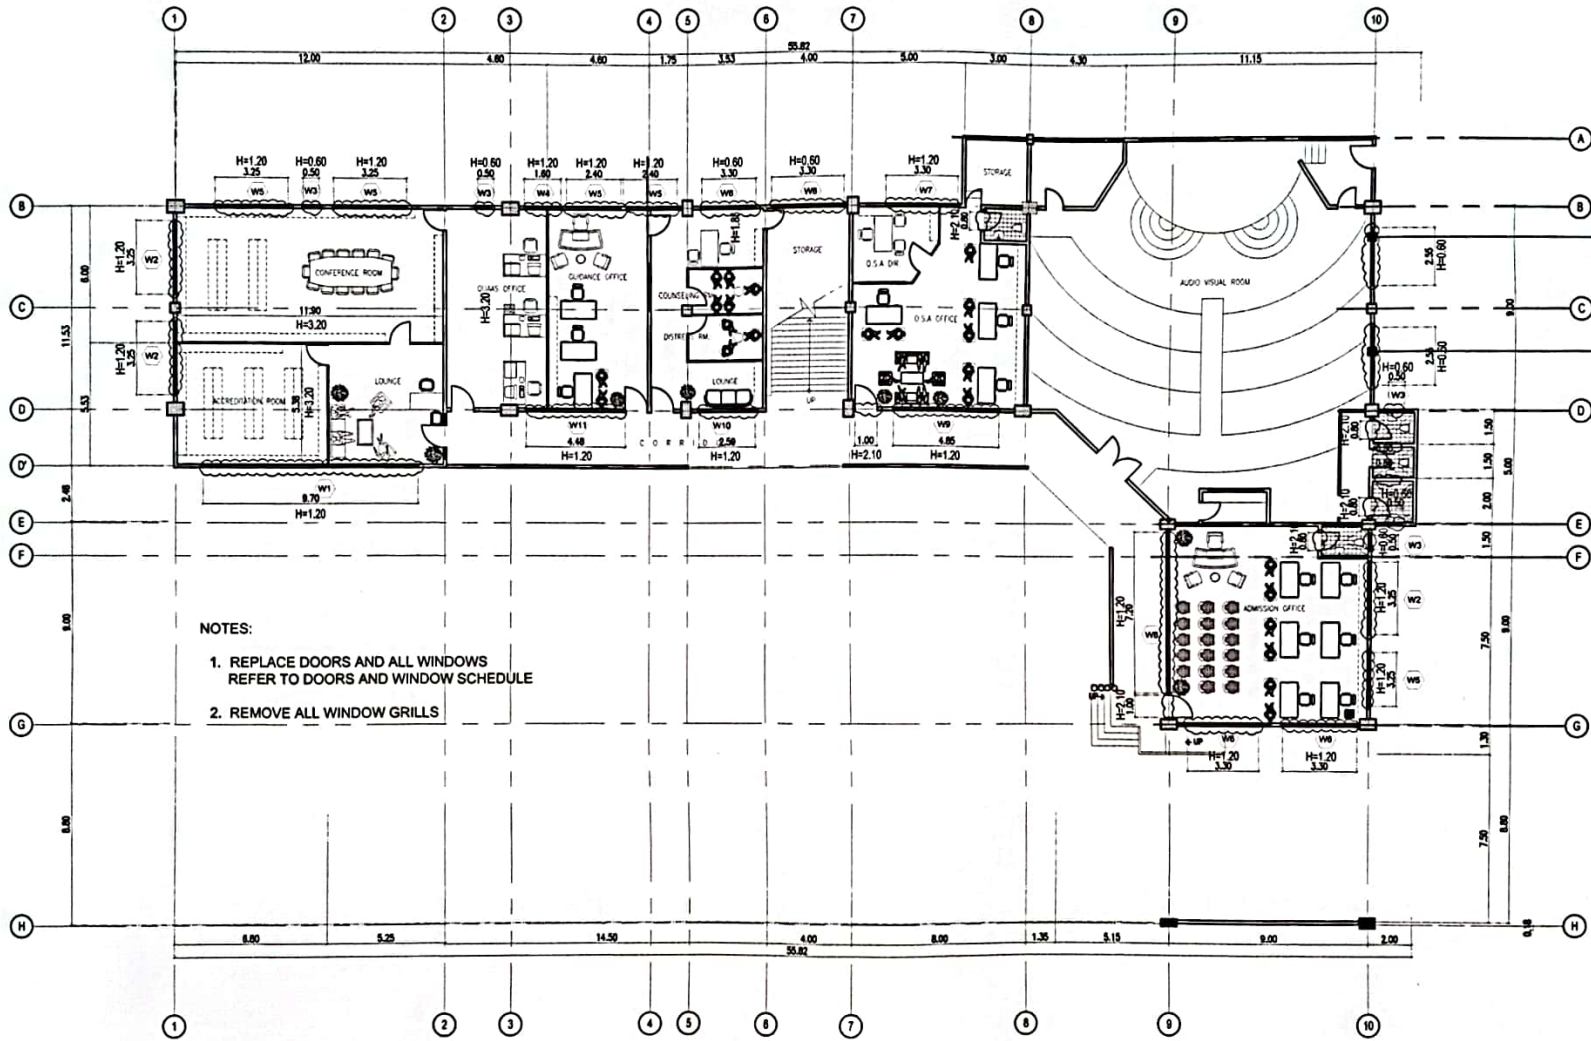


- NOTES:
1. REPLACE DOORS AND ALL WINDOWS REFER TO DOORS AND WINDOW SCHEDULE
 2. REMOVE ALL WINDOW GRILLS

REMOVE WINDOW
REPLACE WITH CHB WALL

REMOVE WINDOW
REPLACE WITH CHB WALL

1 GROUND FLOOR DEMOLITION PLAN FOR WINDOWS AND DOORS
 A/12 SCALE: 1:200M

<p>REPUBLIC OF THE PHILIPPINES UNIVERSITY OF SCIENCE & TECHNOLOGY OF SOUTHERN PHILIPPINES CIVIL AND SANITARY WORKS UNIT C.M. RECTO AVENUE, LAPASAN 9000 CAGAYAN DE ORO CITY TEL. Nos. (08822) 72-00-66 / (0881) 854-1730 / 854-1734 TELS FAX (088) 856-4490 WEB SITE: WWW.USTP.EDU.PH</p>	PREPARED BY ENGR. EDEGM LLOYD S. BALAGIS ASSISTANT DIRECTOR, AHS	PROJECT: PROPOSED RENOVATION OF ITB (BLDG. 3) AS THE COLLEGE OF MEDICINE (PHASE 2)	NOTED BY: AR. FERDINAND S. DURAN DIRECTOR, ADMINISTRATION & FACILITIES SERVICES	RECOMMENDING APPROVAL: ATTY. JONATHAN S. OCHOA VICE CHANCELLOR FOR FINANCE AND ADMINISTRATION	RECOMMENDING APPROVAL: ATTY. RIGEL O. ALBINA CHANCELLOR, USTP-CDO CAMPUS	APPROVED: DR. AMBROSIO M. VENTURA II PRESIDENT	SHEET TITLE: SHEET CONTENTS: 1. GROUND FLOOR DEMOLITION PLAN FOR WINDOWS AND DOORS	DRAWN BY: E.C.H. DATE: 06-01-22 CAD BY: R.P.E. DATE: 06-01-22	SHEET NO. A 12 44
	PIC NO.: TRN: PTR NO.:	DATE ISSUED:	LOCATION: C.M. RECTO AVE., LAPASAN MINDAY, CAGAYAN DE ORO CITY OWNER: UNIVERSITY OF SCIENCE & TECHNOLOGY OF SOUTHERN PHILIPPINES						

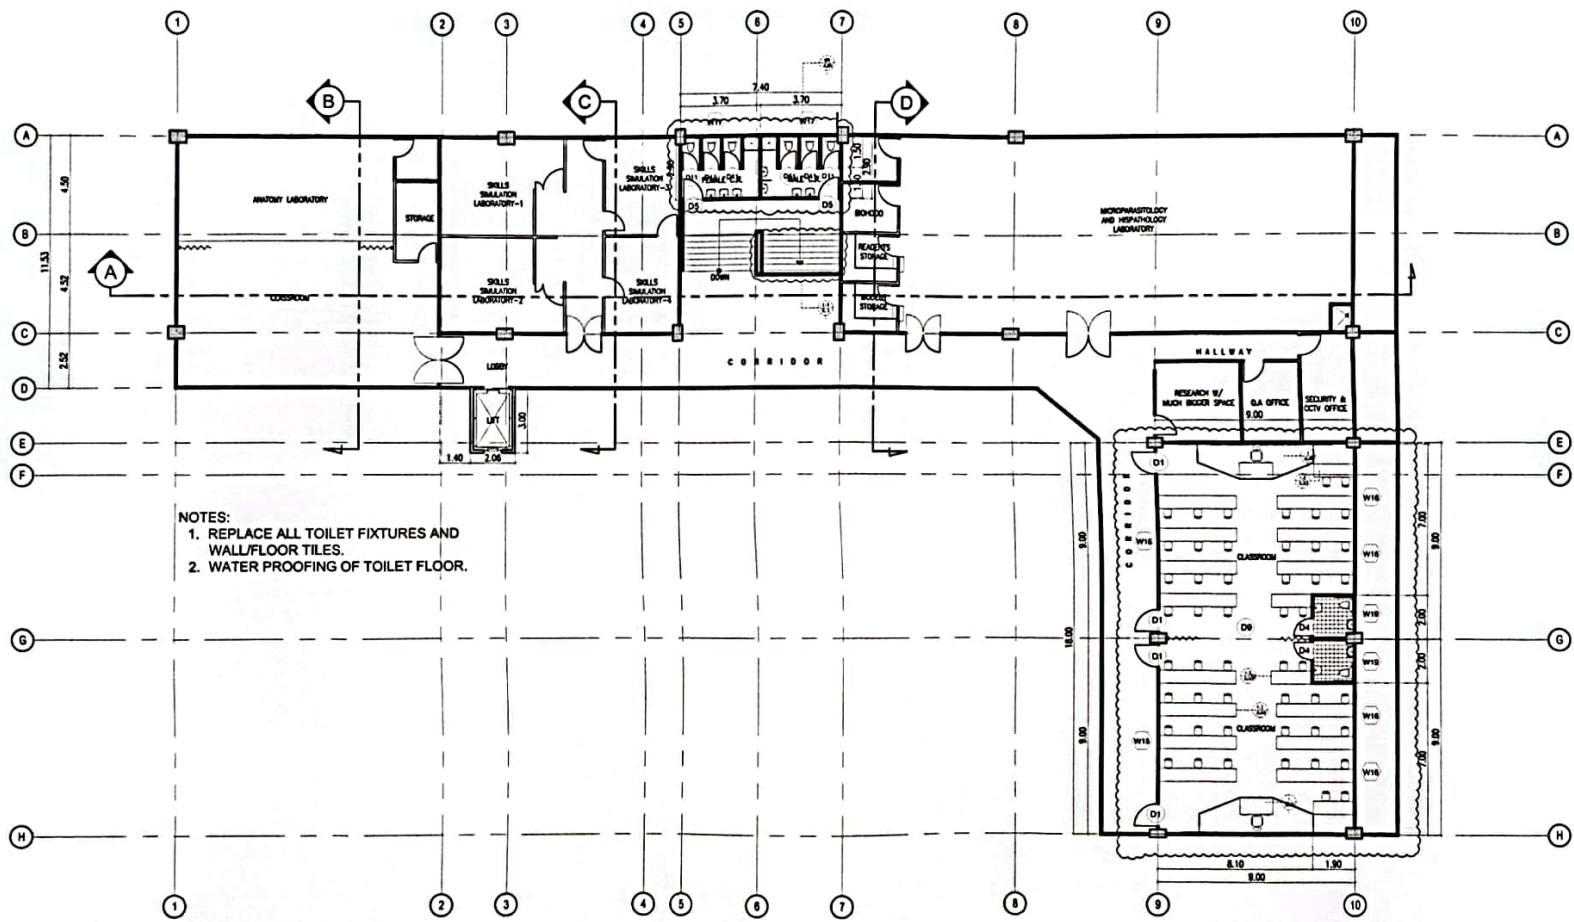

NOTES:
 1. REPLACE ALL TOILET FIXTURES AND WALL/FLOOR TILES.
 2. WATER PROOFING OF TOILET FLOOR.

1
A/13 **PROPOSED SECOND FLOOR PLAN**
 SCALE: 1:200M



REPUBLIC OF THE PHILIPPINES
 UNIVERSITY OF SCIENCE & TECHNOLOGY OF
 SOUTHERN PHILIPPINES
 CIVIL AND SANITARY WORKS UNIT
 C. H. RECTO AVENUE, LAPASAN 9000 CAGAYAN DE ORO CITY
 TEL. NOS. (088) 227-71-60-63 / (088) 856-1754 / 856-1734 TELX
 FAX (088) 856-6470
 WEB SITE: WWW.USTP.PH

PREPARED BY:
 ENGR. EDGEN LLOYD S. BALABIS
 ASST. DIR. CIVIL AND SANITARY WORKS UNIT
 PRC NO. _____ TRN _____
 PTR NO. _____ DATE ISSUED _____

PROJECT:
PROPOSED RENOVATION OF ITB (BLDG. 3) AS THE COLLEGE OF MEDICINE (PHASE 2)
 LOCATION: C. H. RECTO AVENUE, LAPASAN HIGHWAY, CAGAYAN DE ORO CITY
 OWNER: UNIVERSITY OF SCIENCE & TECHNOLOGY OF SOUTHERN PHILIPPINES

NOTED BY:
 DR. FERDINAND S. PAMPA
 DIRECTOR, SUPERVISORY MANAGEMENT SERVICES


RECOMMENDING APPROVAL:
 ATTY. JONATHAN S. OCHE
 VICE CHANCELLOR FOR FINANCE AND ADMINISTRATION

RECOMMENDING APPROVAL:
 ATTY. DIONEL O. ALBINA
 CHANCELLOR, USTP-CDO CAMPUS

APPROVED:
 DR. AMBROSIO S. CULTURA II
 UNIVERSITY PRESIDENT

SHEET TITLE:
 1. PROPOSED SECOND FLOOR PLAN
 DRAWN BY: B.C.H.
 DATE: 00-0-22
 CAD BY: R.P.E.
 DATE: 00-0-22

SHEET NO.
A
13
13
44

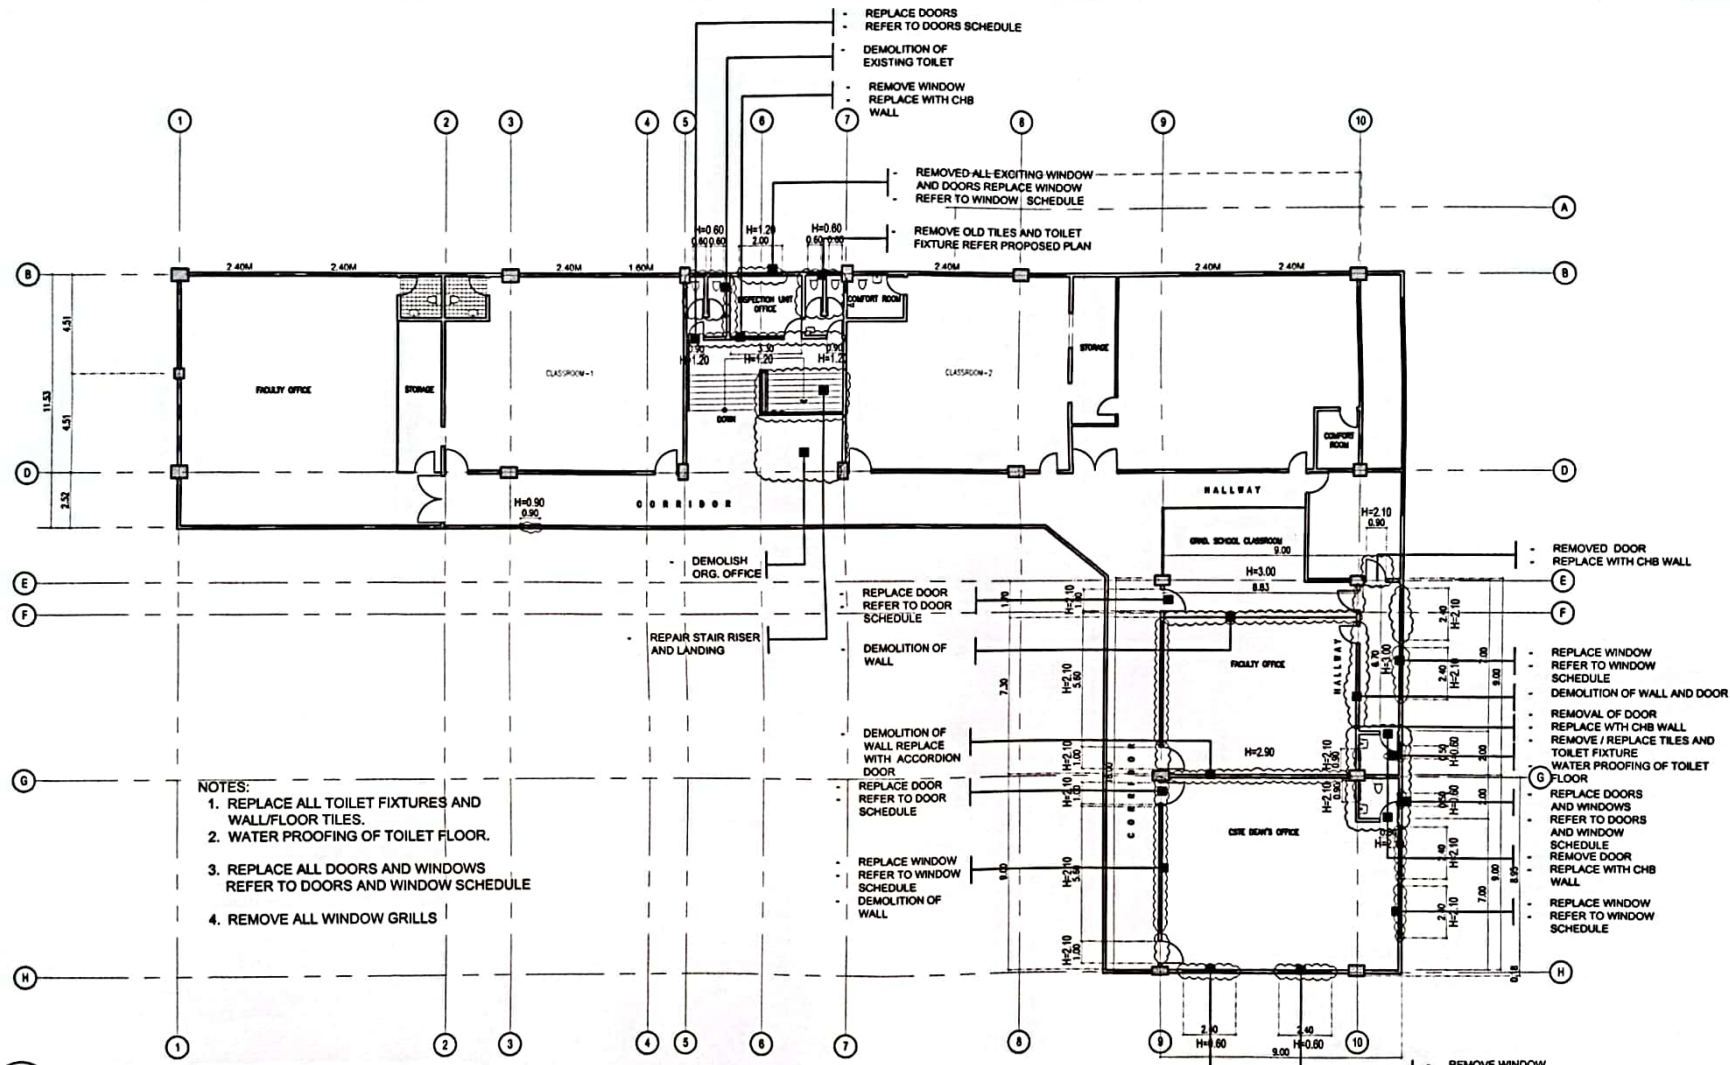

- NOTES:**
1. REPLACE ALL TOILET FIXTURES AND WALL/FLOOR TILES.
 2. WATER PROOFING OF TOILET FLOOR.
 3. REPLACE ALL DOORS AND WINDOWS REFER TO DOORS AND WINDOW SCHEDULE
 4. REMOVE ALL WINDOW GRILLS

1 SECOND FLOOR DEMOLITION PLAN
 SCALE: 1:200M



REPUBLIC OF THE PHILIPPINES
 UNIVERSITY OF SCIENCE & TECHNOLOGY OF SOUTHERN PHILIPPINES
 CIVIL AND SANITARY WORKS UNIT
 C.P. RECTO AVENUE, LAPANAN 9000 CAGAYAN DE ORO CITY
 TEL. NO. (08622) 72-00-65 / (0862) 866-1736 / 854-1739 TRLX
 FAX NO. 856-4470
 WEB SITE: WWW.USTIP.UMD.PH

PREPARED BY:
 ENGR. EDGEN LLOYD S. BALABIS
 ASST. DIR. DIRECTOR, ASW
 PRC NO.:
 TBL:
 PTR NO.:
 DATE ISSUED:

PROJECT:
PROPOSED RENOVATION OF ITB (BLDG. 3) AS THE COLLEGE OF MEDICINE (PHASE 2)
 LOCATION: C.H. RECTO AVE., LAPANAN HIGHWAY, CAGAYAN DE ORO CITY
 OWNER: UNIVERSITY OF SCIENCE & TECHNOLOGY OF SOUTHERN PHILIPPINES

NOTED BY:
 ART FERDINANDA HUMBA
 DIRECTOR, BLDG. MAINTENANCE SERVICES

RECOMMENDING APPROVAL:
 ATTY. JONATHAN S. OCHE
 VICE CHANCELLOR FOR FINANCE AND ADMINISTRATION

RECOMMENDING APPROVAL:
 ATTY. DIDNEL O. ALBINA
 CHANCELLOR, USTP-CDO CAMPUS

APPROVED:
 DR. AMBROSIO S. CULATURA II
 UNIVERSITY PRESIDENT


SHEET TITLE:
 1. SECOND FLOOR DEMOLITION PLAN
 DRAWN BY: B.C.H.
 DATE: 09-09-22
 CAD BY: R.P.S.
 DATE: 09-09-22

SHEET NO.
 A
 14
 44

LEGEND:




FLOOR TO CEILING DRYWALL

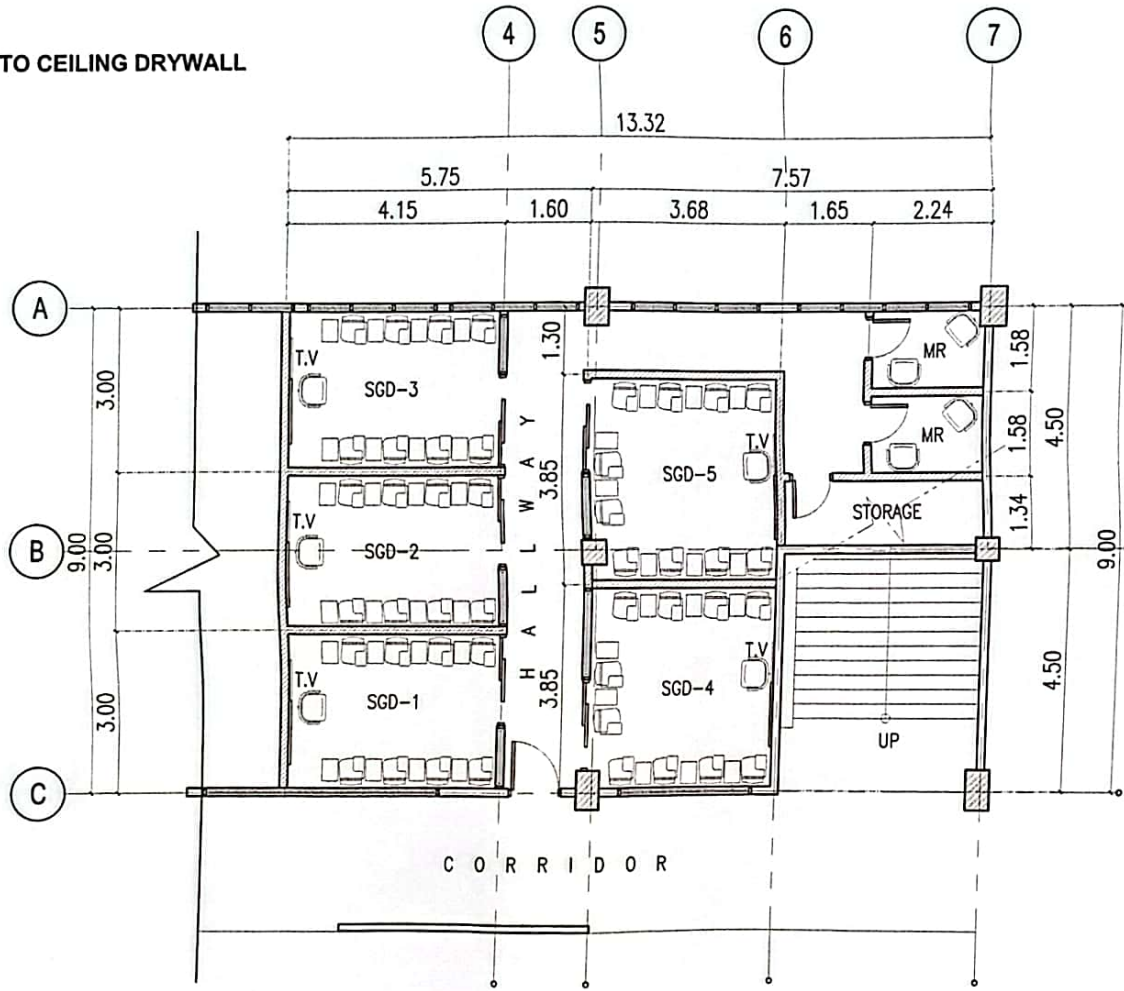

1 SGD & MR FLOOR PLAN
A/15 SCALE: 1:100M

<p>REPUBLIC OF THE PHILIPPINES UNIVERSITY OF SCIENCE & TECHNOLOGY OF SOUTHERN PHILIPPINES CIVIL AND SANITARY WORKS UNIT</p> <p>C. M. RECTO AVENUE, LAPASAN 9000 CAGAYAN DE ORO CITY TEL. NO. (08322) 71-65-65 / (088) 954-7734 / 954-4739 TELE FAX (088) 654-6496 WEB SITE: WWW.USTP.EDU.PH</p>	<p>PREPARED BY: <i>[Signature]</i> ENGR. EDGEN LLOYD S. BALABIS ASSISTANT DIRECTOR, ASG</p>	<p>PROJECT: PROPOSED RENOVATION OF ITB (BLDG. 3) AS THE COLLEGE OF MEDICINE (PHASE 2)</p>	<p>NOTED BY: <i>[Signature]</i> DR. FERDINAND A. DUMPA DIRECTOR, ADMINISTRATION SERVICES</p>	<p>RECOMMENDING APPROVAL: <i>[Signature]</i> ATTY. JONATHAN S. OCHE VICE CHANCELLOR FOR FINANCE AND ADMINISTRATION</p>	<p>RECOMMENDING APPROVAL: <i>[Signature]</i> ATTY. DIANEL O. ALBINA CHANCELLOR, USTP-CDO CAMPUS</p>	<p>APPROVED: <i>[Signature]</i> DR. AMBRASIO S. CULTURA II UNIVERSITY PRESIDENT</p>	<p>SHEET TITLE: 1. SGD & MR FLOOR PLAN</p>	<p>DRAWN BY: G.C.H. DATE: 08-11-22</p>	<p>SHEET NO. A 15 15 44</p>
	<p>LOCATION: C.M. RECTO AVE., LAPASAN HIGHWAY, CAGAYAN DE ORO CITY</p>	<p>OWNER: UNIVERSITY OF SCIENCE & TECHNOLOGY OF SOUTHERN PHILIPPINES</p>	<p>DATE ISSUED:</p>	<p>DATE: 08-11-22</p>					

 
LEGEND:




FLOOR TO CEILING DRYWALL



 2.10 MTS HEIGHT DRYWALL



FLOOR TO CEILING CHB WALL

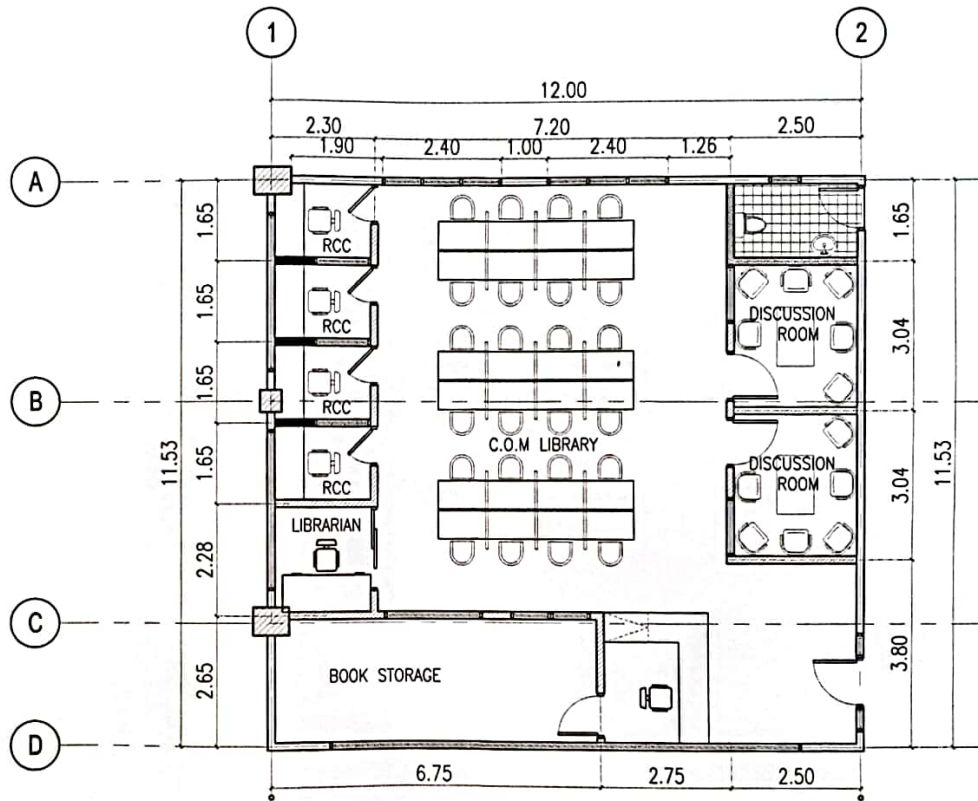

1
A/16 C.O.M. LIBRARY FLOOR PLAN
SCALE: 1:100M



REPUBLIC OF THE PHILIPPINES
UNIVERSITY OF SCIENCE & TECHNOLOGY OF
SOUTHERN PHILIPPINES
CIVIL AND SANITARY WORKS UNIT
C. M. RECTO AVENUE, LAPASAN, 9000 CAGAYAN DE ORO CITY
TEL. NOS. (088) 221-72-66-68 / (088) 886-1736 / 886-1739 TOLL
FREE (088) 856-6186
WEB SITE: WWW.USTP.EDU.PH

PREPARED BY:
ENR. EDGEN LLOYD S. BALABIS
ASSISTANT DIRECTOR, SWU
PROJECT NO.:
DATE ISSUED:

PROJECT:
PROPOSED RENOVATION OF ITB
(BLDG. 3) AS THE COLLEGE OF
MEDICINE (PHASE 2)
LOCATION: C. M. RECTO AVE., LAPASAN HIGHWAY, CAGAYAN DE ORO CITY
OWNER: UNIVERSITY OF SCIENCE & TECHNOLOGY OF SOUTHERN PHILIPPINES

NOTED BY:
DR. FERDINAND A. DUMPA
DIRECTOR, ALP/ITB MANAGEMENT
AND ADMINISTRATION

RECOMMENDING APPROVAL:
ATTY. JONATHAN S. OCHE
VICE CHANCELLOR FOR FINANCE
AND ADMINISTRATION

RECOMMENDING APPROVAL:
ATTY. DIANEL O. ALBINA
CHANCELLOR, USTP-CDO CAMPUS

APPROVED:
DR. AMBROSIO S. CULTURA II
UNIVERSITY PRESIDENT


SHEET TITLE:
1. C.O.M. LIBRARY
FLOOR PLAN
DRAWN BY: S.C.H.
DATE: 06-02-22
CAD BY: R.P.E.
DATE: 06-02-22

SHEET NO.
A
16
16
44


LEGEND:

1.97 MTS HEIGHT PHENOLIC BOARD PARTITION


3MTS HEIGHT CHB WALL

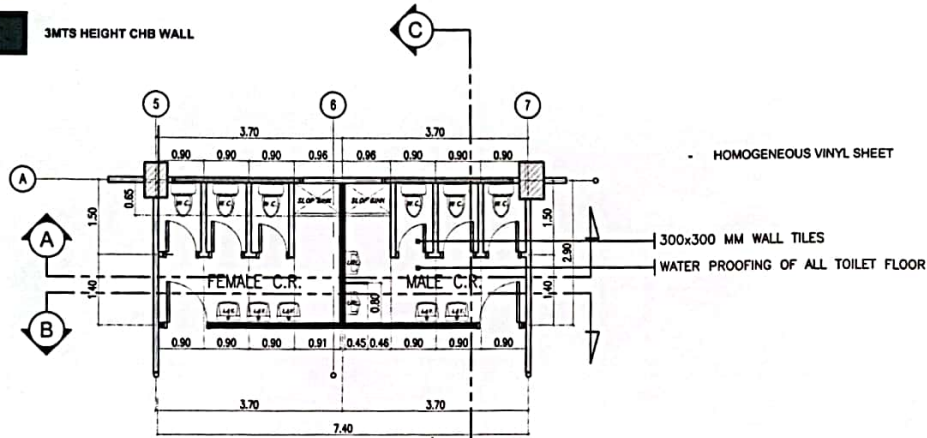


1 MALE & FEMALE TOILET MEZZANINE FLOOR PLAN
SCALE: 1:100M

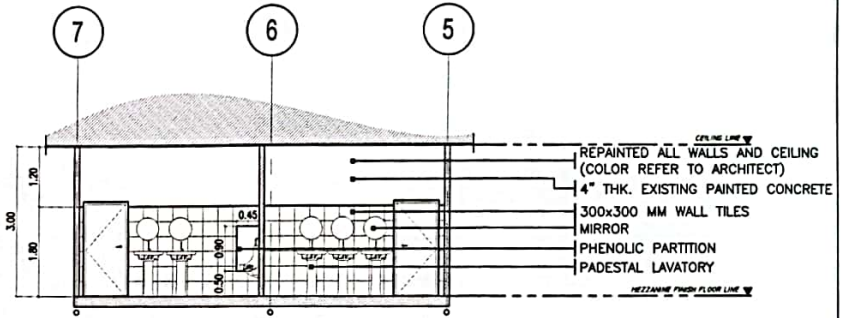

2 MALE & FEMALE TOILET MEZZANINE SECTION THROUGH A-A
SCALE: 1:100M

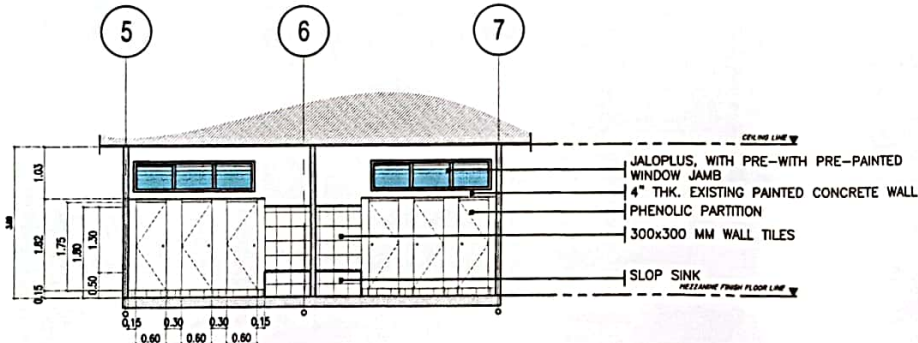

3 MALE & FEMALE TOILET MEZZANINE SECTION THROUGH B-B
SCALE: 1:100M

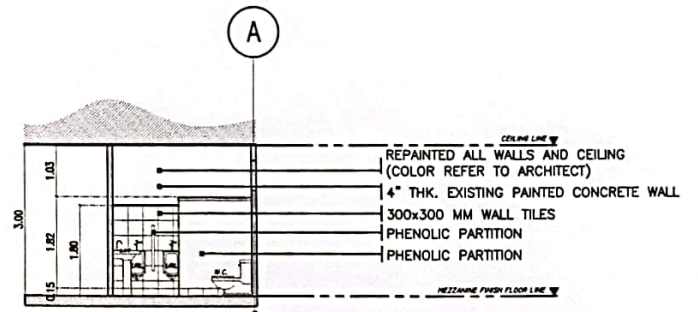

4 MALE & FEMALE TOILET MEZZANINE SECTION THROUGH C-C
SCALE: 1:100M



REPUBLIC OF THE PHILIPPINES
UNIVERSITY OF SCIENCE & TECHNOLOGY OF SOUTHERN PHILIPPINES
CIVIL AND SANITARY WORKS UNIT
C.M. RECTO AVENUE, LAPASAN 9000 CAGAYAN DE ORO CITY
TEL. NOS. (0882) 72-00-85 / (0882) 856-1738 / 856-1750 TELE
FAX (0882) 856-6998
WWW SITE: WWW.USTP.EDU.PH

PREPARED BY:
[Signature]
ENGR. EDGEN LLOYD S. BALARIS
ARCHITECT DIRECTOR, A/E

PROJECT:
PROPOSED RENOVATION OF ITB (BLDG. 3) AS THE COLLEGE OF MEDICINE (PHASE 2)
LOCATION: C.M. RECTO AVE., LAPASAN HIGHWAY, CAGAYAN DE ORO CITY
OWNER: UNIVERSITY OF SCIENCE & TECHNOLOGY OF SOUTHERN PHILIPPINES

NOTED BY:
[Signature]
ATY. FERNANDO Z. DUMPA
DIRECTOR, QUALITY MANAGEMENT


RECOMMENDING APPROVAL:
[Signature]
ATTY. JONATHAN S. OCHE
VICE CHANCELLOR FOR FINANCE AND ADMINISTRATION

RECOMMENDING APPROVAL:
[Signature]
ATY. DIONEL O. ALBINA
CHANCELLOR, USTP-CDO CAMPUS


APPROVED:
[Signature]
DR. AMBROSIO B. CULTURA II
UNIVERSITY PRESIDENT


SHEET TITLE
DRAWN BY: G.C.H.
DATE: 08-08-22
SHEET CONTENTS:
1. MALE & FEMALE TOILET MEZZANINE FLOOR PLAN
2. SECTION THROUGH A-A
3. SECTION THROUGH B-B
4. SECTION THROUGH C-C
CAD BY: R.P.E.
DATE: 08-08-22

SHEET NO.
A
17
44

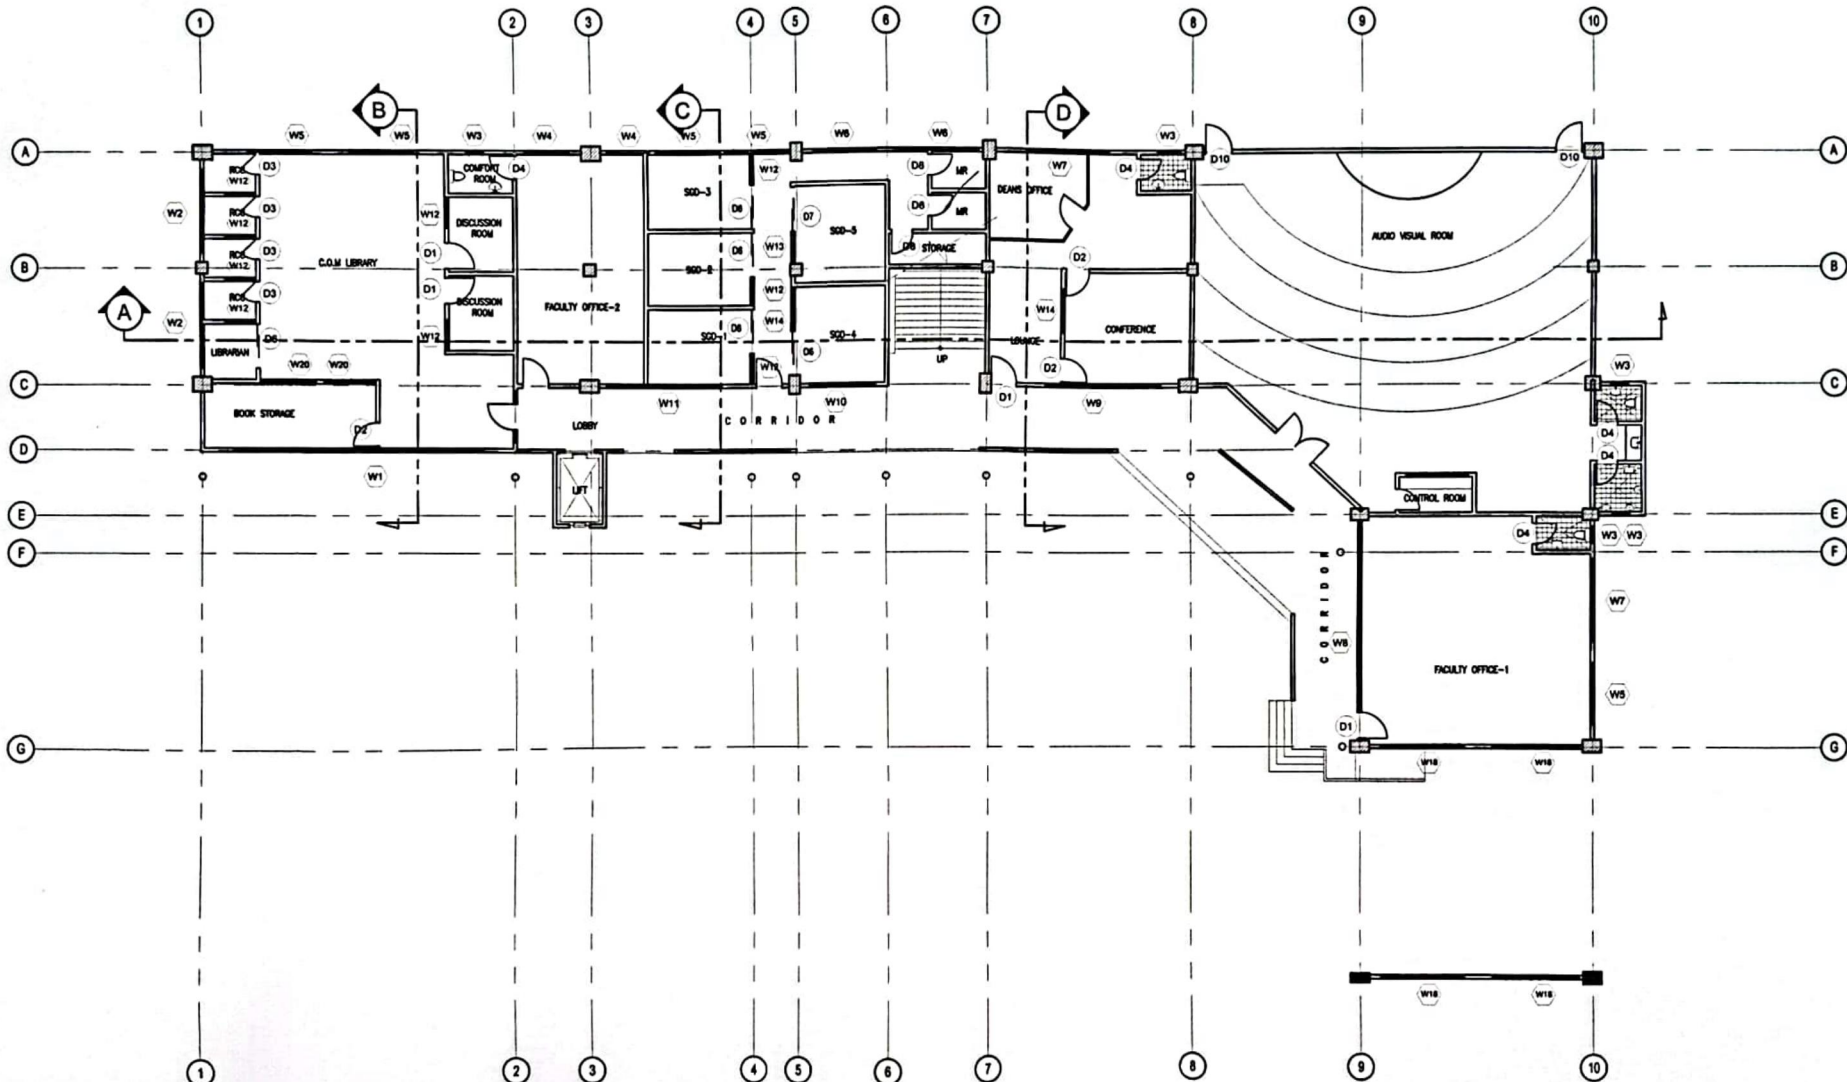


1
A/18 GROUND FLOOR SCHEDULE OF DOORS AND WINDOWS PLAN
SCALE: 1:200M


 <p>REPUBLIC OF THE PHILIPPINES UNIVERSITY OF SCIENCE & TECHNOLOGY OF SOUTHERN PHILIPPINES CIVIL AND SANITARY WORKS UNIT</p> <p>C. H. RECTO AVENUE, LAPASAN 9000 CAGAYAN DE ORO CITY TEL. NO. (08822) 72-00-00 / (088) 806-1750 / 806-1750 TOLL FAX (088) 806-6496 WEB SITE: WWW.USTIP.UMD.PH</p>	<p>PREPARED BY: <i>[Signature]</i> ENGR. EDGEN LLOYD S. BALABIS ASSISTANT DIRECTOR, A/S</p>	<p>PROJECT: PROPOSED RENOVATION OF ITB (BLDG. 3) AS THE COLLEGE OF MEDICINE (PHASE 2)</p>	<p>NOTED BY: <i>[Signature]</i> AR. FERDINAND S. DULERA DIRECTOR OF SANITARY MANAGEMENT SERVICES</p>	<p>RECOMMENDING APPROVAL: <i>[Signature]</i> ATTY. JONATHAN S. OCHE VICE CHANCELLOR FOR FINANCE AND ADMINISTRATION</p>	<p>RECOMMENDING APPROVAL: <i>[Signature]</i> ATTY. DONEL O. ALBINA CHANCELLOR, USTP-CDO CAMPUS</p>	<p>APPROVED: <i>[Signature]</i> DR. AMBRONIO S. CULTURA II UNIVERSITY PRESIDENT</p>	<p>SHEET TITLE: 1. GROUND FLOOR SCHEDULE OF DOORS AND WINDOWS PLAN</p>	<p>DRAWN BY: S.C.H. DATE: 08-08-22 CAD BY: R.P.E. DATE: 08-08-22</p>	<p>SHEET NO. A 18 44</p>
	<p>PRC NO.:</p>	<p>TIN:</p>	<p>LOCATION: C. H. RECTO AVE., LAPASAN HIGHWAY, CAGAYAN DE ORO CITY</p>	<p>OWNER: UNIVERSITY OF SCIENCE & TECHNOLOGY OF SOUTHERN PHILIPPINES</p>	<p>DATE ISSUED:</p>				

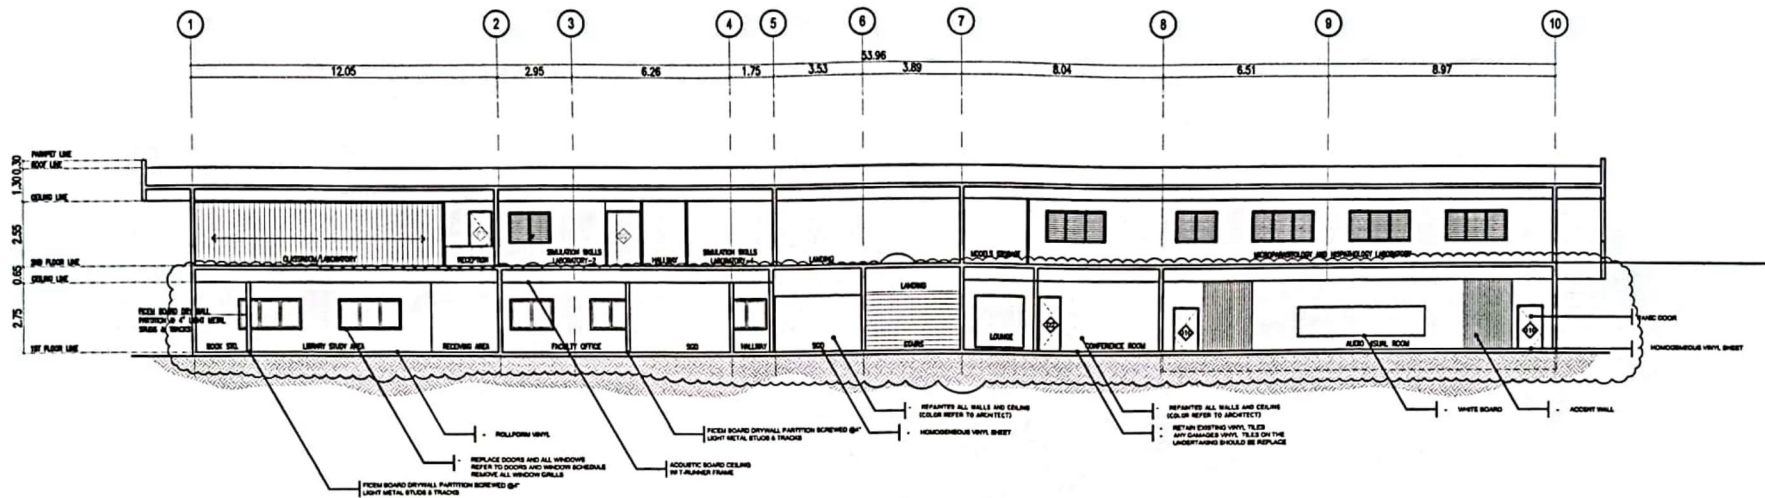


1 SECTION THROUGH "A"
 A/21 SCALE: 1:200M

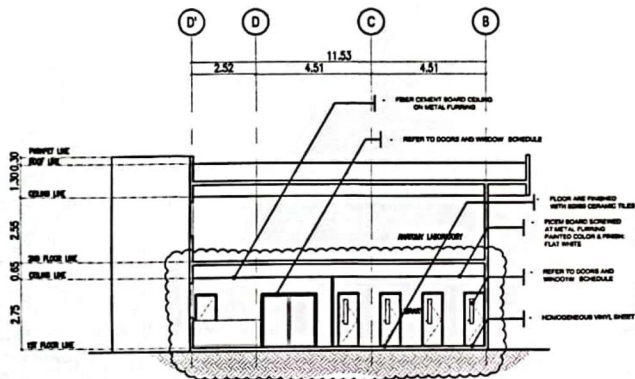

2 SECTION THROUGH "B"
 A/21 SCALE: 1:200M

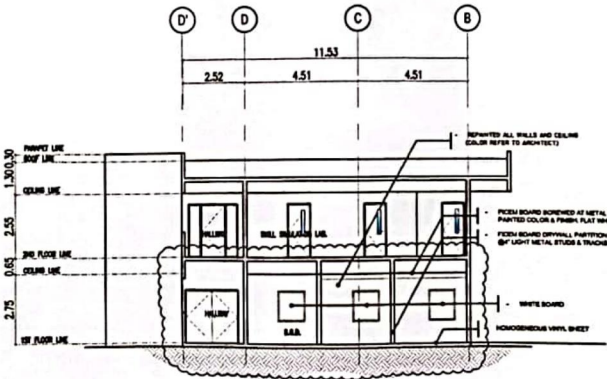

3 SECTION THROUGH "C"
 A/21 SCALE: 1:200M

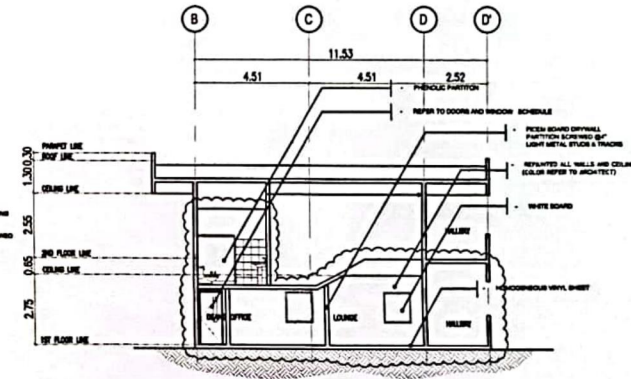

4 SECTION THROUGH "D"
 A/21 SCALE: 1:200M



REPUBLIC OF THE PHILIPPINES
 UNIVERSITY OF SCIENCE & TECHNOLOGY OF
 SOUTHERN PHILIPPINES
 CIVIL AND SANITARY WORKS UNIT
 C. H. RECTO AVENUE, LAPASAN 9000 CASAYAN DE ORO CITY
 TEL. NOS. (0842) 72-66-65 / (086) 856-1736 / 856-1759 TOLL
 FAX (0842) 856-1676
 WEB SITE: WWW.USTP.EDU.PH

PREPARED BY:
 ENGR. EDGEM LLOYD S. BALABIS
 ASSISTANT DIRECTOR, CIVIL AND SANITARY WORKS UNIT
 PRC NO.: TMR
 PTR NO.: DATE ISSUED:

PROJECT:
 PROPOSED RENOVATION OF ITB
 (BLDG. 3) AS THE COLLEGE OF
 MEDICINE (PHASE 2)
 LOCATION: C.H. RECTO AVE., LAPASAN HIGHWAY, CASAYAN DE ORO CITY
 OWNER: UNIVERSITY OF SCIENCE & TECHNOLOGY OF SOUTHERN PHILIPPINES

NOTED BY:
 DR. FERDINAND A. SAMPANA
 DIRECTOR, QUALITY MANAGEMENT SERVICES

RECOMMENDING APPROVAL:
 ATTY. JONATHAN S. OCHE
 VICE CHANCELLOR FOR FINANCE AND ADMINISTRATION

RECOMMENDING APPROVAL:
 ATTY. DIANEL O. ALBINA
 CHANCELLOR, USTP-CIO CAMPUS

APPROVED:
 DR. AMBROSIO S. CULTURA II
 UNIVERSITY PRESIDENT

SHEET TITLE:
 1. SECOND FLOOR
 SCHEDULE OF DOORS
 AND WINDOWS
 DRAWN BY: S.C.H.
 DATE: 06-10-22
 CAD BY: P.P.E.
 DATE: 06-10-22

SHEET NO.
 A
 21
 44

<p>NAME: SLIDING WINDOW LOCATION: C.O.M LIBRARY DESCRIPTION: 1/2" THK. FLOAT GLASS WITH POWDER-COATED WHITE 1/2"x1" RECTANGULAR ALUMINUM FRAMING NUMBER OF SET: 1 SET</p>	<p>NAME: SLIDING WINDOW LOCATION: C.O.M LIBRARY DESCRIPTION: 1/2" THK. FLOAT GLASS WITH POWDER-COATED WHITE 1/2"x1" RECTANGULAR ALUMINUM FRAMING NUMBER OF SET: 2 SETS</p>	<p>NAME: AWNING WINDOW LOCATION: TOILET DESCRIPTION: 1/2" THK. FLOAT GLASS WITH POWDER-COATED WHITE 1/2"x1" RECTANGULAR ALUMINUM FRAMING NUMBER OF SET: 5 SETS</p>	<p>NAME: SLIDING WINDOW LOCATION: FACULTY 2 DESCRIPTION: 1/2" THK. FLOAT GLASS WITH POWDER-COATED WHITE 1/2"x1" RECTANGULAR ALUMINUM FRAMING NUMBER OF SET: 2 SETS</p>	<p>NAME: SLIDING WINDOW LOCATION: SGO ROOMS, FACULTY RM. 1, COM UB DESCRIPTION: 1/2" THK. FLOAT GLASS WITH POWDER-COATED WHITE 1/2"x1" RECTANGULAR ALUMINUM FRAMING NUMBER OF SET: 5 SETS</p>
<p>NAME: AWNING WINDOW LOCATION: MR ROOM DESCRIPTION: 1/2" THK. FLOAT GLASS WITH POWDER-COATED WHITE 1/2"x1" RECTANGULAR ALUMINUM FRAMING NUMBER OF SET: 2 SETS</p>	<p>NAME: SLIDING WINDOW LOCATION: FACULTY ROOM 1 DESCRIPTION: 1/2" THK. FLOAT GLASS WITH POWDER-COATED WHITE 1/2"x1" RECTANGULAR ALUMINUM FRAMING NUMBER OF SET: 2 SETS</p>	<p>NAME: SLIDING WINDOW LOCATION: FACULTY ROOM 1 DESCRIPTION: 1/2" THK. FLOAT GLASS WITH POWDER-COATED WHITE 1/2"x1" RECTANGULAR ALUMINUM FRAMING NUMBER OF SET: 1 SET</p>	<p>NAME: SLIDING WINDOW LOCATION: DEANS OFFICE DESCRIPTION: 1/2" THK. FLOAT GLASS WITH POWDER-COATED WHITE 1/2"x1" RECTANGULAR ALUMINUM FRAMING NUMBER OF SET: 1 SET</p>	

1 SCHEDULE OF WINDOWS
A/22 SCALE:



REPUBLIC OF THE PHILIPPINES
UNIVERSITY OF SCIENCE & TECHNOLOGY OF SOUTHERN PHILIPPINES
CIVIL AND SANITARY WORKS UNIT
C. H. RECTO AVENUE, LAPASAN 9000 CAGAYAN DE ORO CITY
TEL. NO. (0882) 72-60-68 / (0882) 850-1738 / 850-1739 TELX
FAX (0882) 850-6499
WEB SITE: WWW.USTP.EDU.PH

DESIGNED BY: *[Signature]*
ENGR. EDGEN LLOYD S. BALABIS
ASSISTANT DIRECTOR, AHS

PROJECT: PROPOSED RENOVATION OF ITS (BLDG. 3) AS THE COLLEGE OF MEDICINE (PHASE 2)
LOCATION: C.H RECTO AVE., LAPASAN HIGHWAY, CAGAYAN DE ORO CITY
OWNER: UNIVERSITY OF SCIENCE & TECHNOLOGY OF SOUTHERN PHILIPPINES

NOTED BY: *[Signature]*
DR. FERDINAND A. BERNARDO
DIRECTOR, QUALITY MANAGEMENT SERVICES

RECOMMENDING APPROVAL: *[Signature]*
ATTY. JONATHAN S. OCHE
VICE CHANCELLOR FOR FINANCE AND ADMINISTRATION

RECOMMENDING APPROVAL: *[Signature]*
ATTY. RICHIE O. ALBINA
CHANCELLOR, USTP-CDO CAMPUS

APPROVED: *[Signature]*
DR. AMBROSIO B. CULTURA II
UNIVERSITY PRESIDENT

SHEET TITLE: 1. SCHEDULE OF WINDOWS
DRAWN BY: G.C.H.
DATE: 09-0-08
CAD BY: R.P.E.
DATE: 08-11-07


SHEET NO. A/22
22
44

NAME: PANEL DOOR LOCATION: DEANS OFFICE, FACULTY ROOM 1, DISCUSSION ROOM, CLASSROOM DESCRIPTION: WOODEN PANEL DOOR WITH VIEWING PANE AND LEVER DOOR KNOB SET NUMBER OF SET: 8 SETS	NAME: PANEL DOOR LOCATION: DEANS CONFERENCE, BOOK STORAGE ROOM, STORAGE ROOM DESCRIPTION: WOODEN PANEL DOOR WITH VIEWING PANE AND LEVER DOOR KNOB SET NUMBER OF SET: 4 SETS	NAME: PANEL DOOR LOCATION: RGC DESCRIPTION: WOODEN PANEL DOOR WITH VIEWING PANE AND LEVER DOOR KNOB SET NUMBER OF SET: 4 SETS	NAME: PANEL DOOR LOCATION: TOILET DESCRIPTION: WOODEN PANEL DOOR AND LEVER DOOR KNOB SET NUMBER OF SET: 7 SETS
NAME: PANEL DOOR LOCATION: MALE AND FEMALE TOILET ROOM DESCRIPTION: WOODEN PANEL DOOR AND LEVER DOOR KNOB SET NUMBER OF SET: 2 SETS	NAME: SLIDING DOOR LOCATION: SGD ROOM DESCRIPTION: ALUMINUM SLIDING DOOR WITH FROSTED FILM AND DOOR LOCK SET NUMBER OF SET: 3 SETS	NAME: SLIDING DOOR LOCATION: SGD ROOM DESCRIPTION: ALUMINUM SLIDING DOOR WITH FROSTED FILM AND DOOR LOCK SET NUMBER OF SET: 1 SET	NAME: PANEL DOOR LOCATION: MR ROOM, STORAGE ROOM DESCRIPTION: WOODEN PANEL DOOR WITH VIEWING PANE AND LEVER DOOR KNOB SET NUMBER OF SET: 3 SETS

NAME: CUSTOMIZE ACOUSTIC ACCORDION DOOR LOCATION: 2ND FLOOR CLASSROOMS DESCRIPTION: POLYESTER FIBER BOARD ON MARINE PLYWOOD ACCORDION PANELS WITH GLIDERS ON CEILING MOUNTED TRACK NUMBER OF SET: 1 SET	NAME: PANIC DOOR LOCATION: AVS DESCRIPTION: PANIC DOOR SET AND ACCESSORIES NUMBER OF SET: 2 SETS	NAME: PHENOLIC DOOR LOCATION: 2ND FLOOR TOILET DESCRIPTION: PHENOLIC BOARD WITH ACCESSORIES NUMBER OF SET: 8 SETS

1
A/24 SCHEDULE OF DOORS
SCALE:

<p>REPUBLIC OF THE PHILIPPINES UNIVERSITY OF SCIENCE & TECHNOLOGY OF SOUTHERN PHILIPPINES CIVIL AND SANITARY WORKS UNIT C. H. RECTO AVENUE, LAFAYETTE 0003 CAGAYAN DE ORO CITY Tel. Nos. (0862) 72-60-69 / (0862) 856-1736 / 856-1739 Telle Fax (0862) 856-6498 Web Site: www.ustip.edu.ph</p>	PREPARED BY: ENGR. EDGEN LLOIDO S. BALABIS ASSISTANT DIRECTOR, AMS	PROJECT: PROPOSED RENOVATION OF ITB (BLDG. 3) AS THE COLLEGE OF MEDICINE (PHASE 2)	NOTED BY: AR FERDINAND S. DUPPA DIRECTOR - HEALTH MANAGEMENT SERVICE	RECOMMENDING APPROVAL: ATTY. JONATHAN S. OCHE VICE CHANCELLOR FOR FINANCE AND ADMINISTRATION	RECOMMENDING APPROVAL: ATTY. DOREL O. ALBINA CHANCELLOR, USTP-CAG CAMPUS	APPROVED: DR. AMBROSIO B. CULTURA II UNIVERSITY PRESIDENT	SHEET TITLE: 1. SCHEDULE OF DOORS	DRAWN BY: S.C.H. DATE: 08-0-22	SHEET NO. A 24 44
	PRC NO: TRN: PFM NO:	DATE ISSUED:	LOCATION: C.H. RECTO AVE., LAFAYETTE HIGHWAY, CAGAYAN DE ORO CITY OWNER: UNIVERSITY OF SCIENCE & TECHNOLOGY OF SOUTHERN PHILIPPINES	SHEET CONTENTS: 1. SCHEDULE OF DOORS	CAD BY: R.P.E. DATE: 08-0-22				

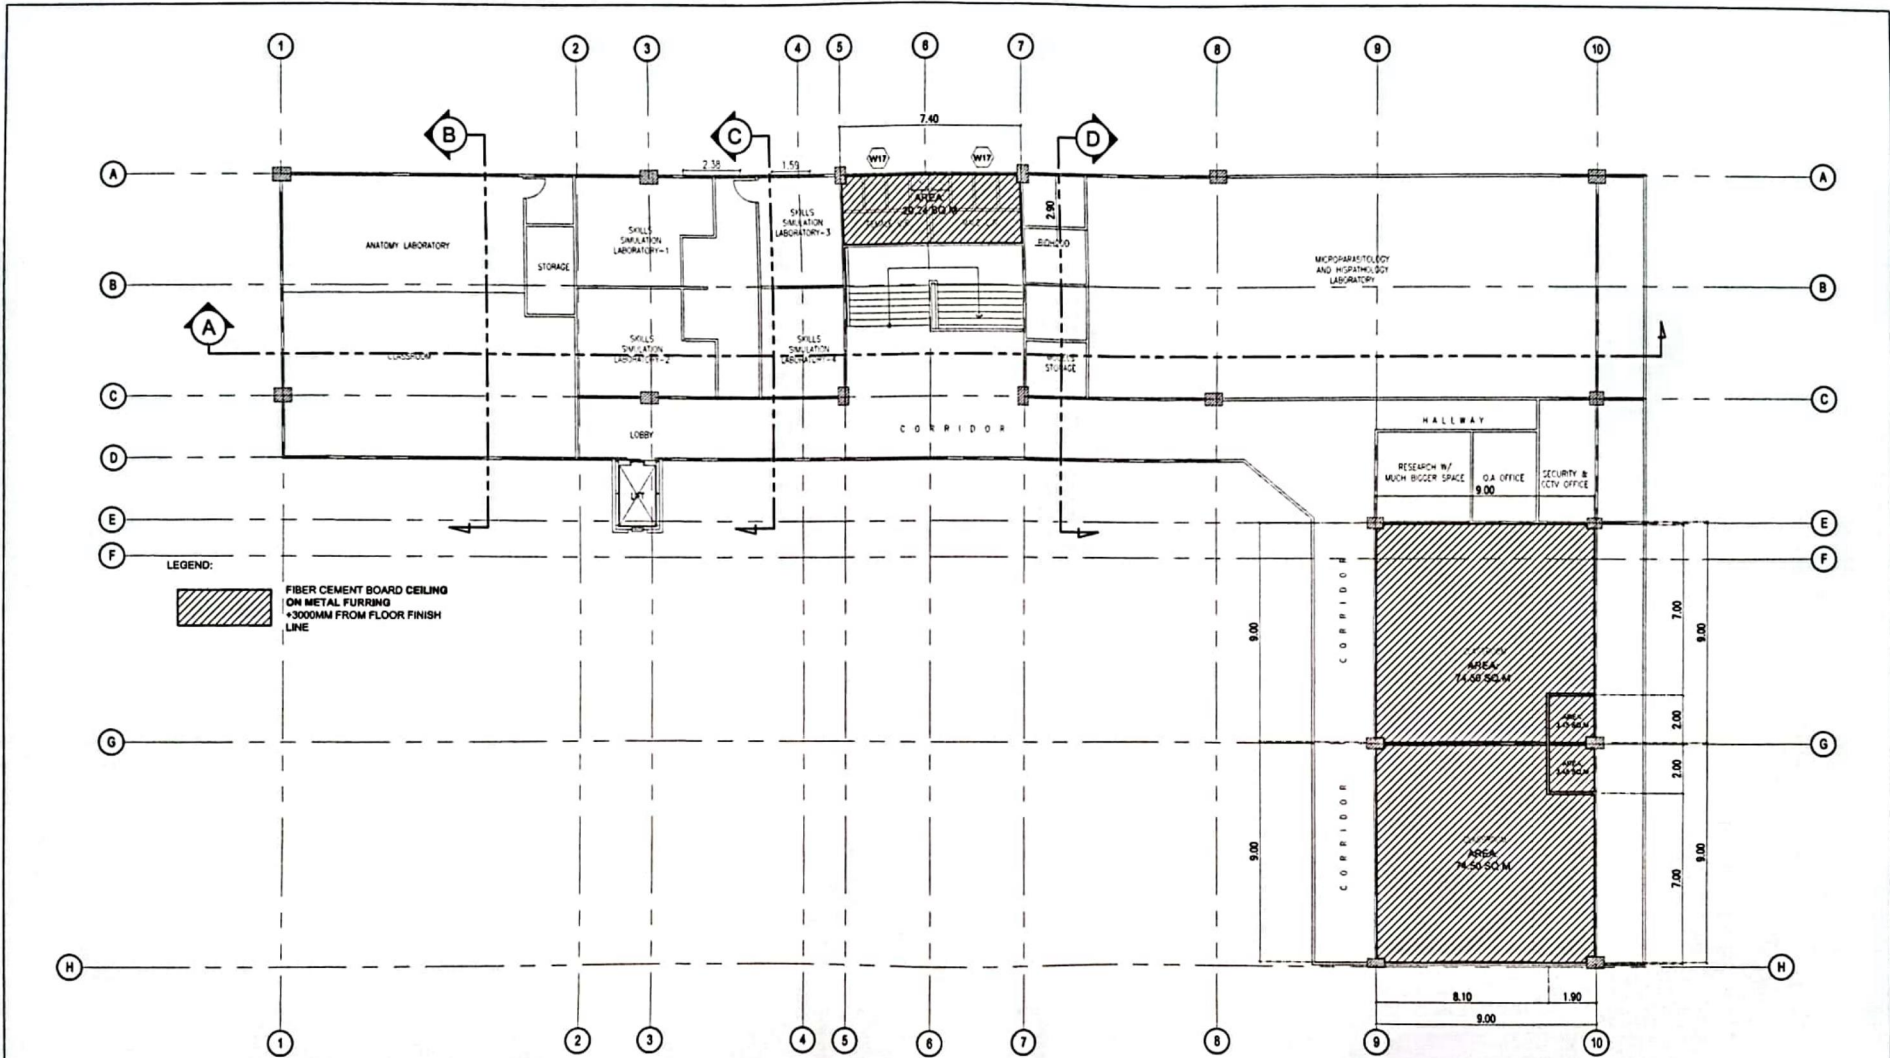

1
A/25 **SECOND FLOOR REFLECTED CEILING PLAN**
SCALE: 1:200M



REPUBLIC OF THE PHILIPPINES
UNIVERSITY OF SCIENCE & TECHNOLOGY OF SOUTHERN PHILIPPINES
 CIVIL AND SANITARY WORKS UNIT
 C. H. RECTO AVENUE, LAPASAN 9000 CAGAYAN DE ORO CITY
 TEL. NOS. (08822) 72-00-85 / (088) 856-1736 / 856-1739 TELE
 FAX (088) 856-1696
 WEB SITE: [WWW.USTP.EDU.PH](http://www.ustp.edu.ph)

PREPARED BY:
[Signature]
ENGR. ROSEM LLOYD S. BALABIS
 ASSISTANT DIRECTOR, AHS

PROJECT: **PROPOSED RENOVATION OF ITB (BLDG. 3) AS THE COLLEGE OF MEDICINE**
 LOCATION: C.H. RECTO AVE., LAPASAN HIGHWAY, CAGAYAN DE ORO CITY
 OWNER: UNIVERSITY OF SCIENCE & TECHNOLOGY OF SOUTHERN PHILIPPINES

NOTED BY:
[Signature]
DR. PERCIVAL B. SORIANO
 DIRECTOR OF COLLEGE OF ENGINEERING
 SERVICE


RECOMMENDING APPROVAL:
[Signature]
ATTY. JONATHAN S. OCHE
 VICE CHANCELLOR FOR FINANCE AND ADMINISTRATION

RECOMMENDING APPROVAL:
[Signature]
ATTY. DIANEL O. ALBINA
 CHANCELLOR, USTP-CDO CAMPUS

APPROVED:
[Signature]
DR. AMBROSIO S. CULTURA II
 VICE PRESIDENT

SHEET TITLE:
 1. SECOND FLOOR REFLECTED CEILING PLAN
 DRAWN BY: S.C.N.
 DATE: 06-0-20
 CAD BY: R.P.E.
 DATE: 06-0-20

SHEET NO.
A
25
44

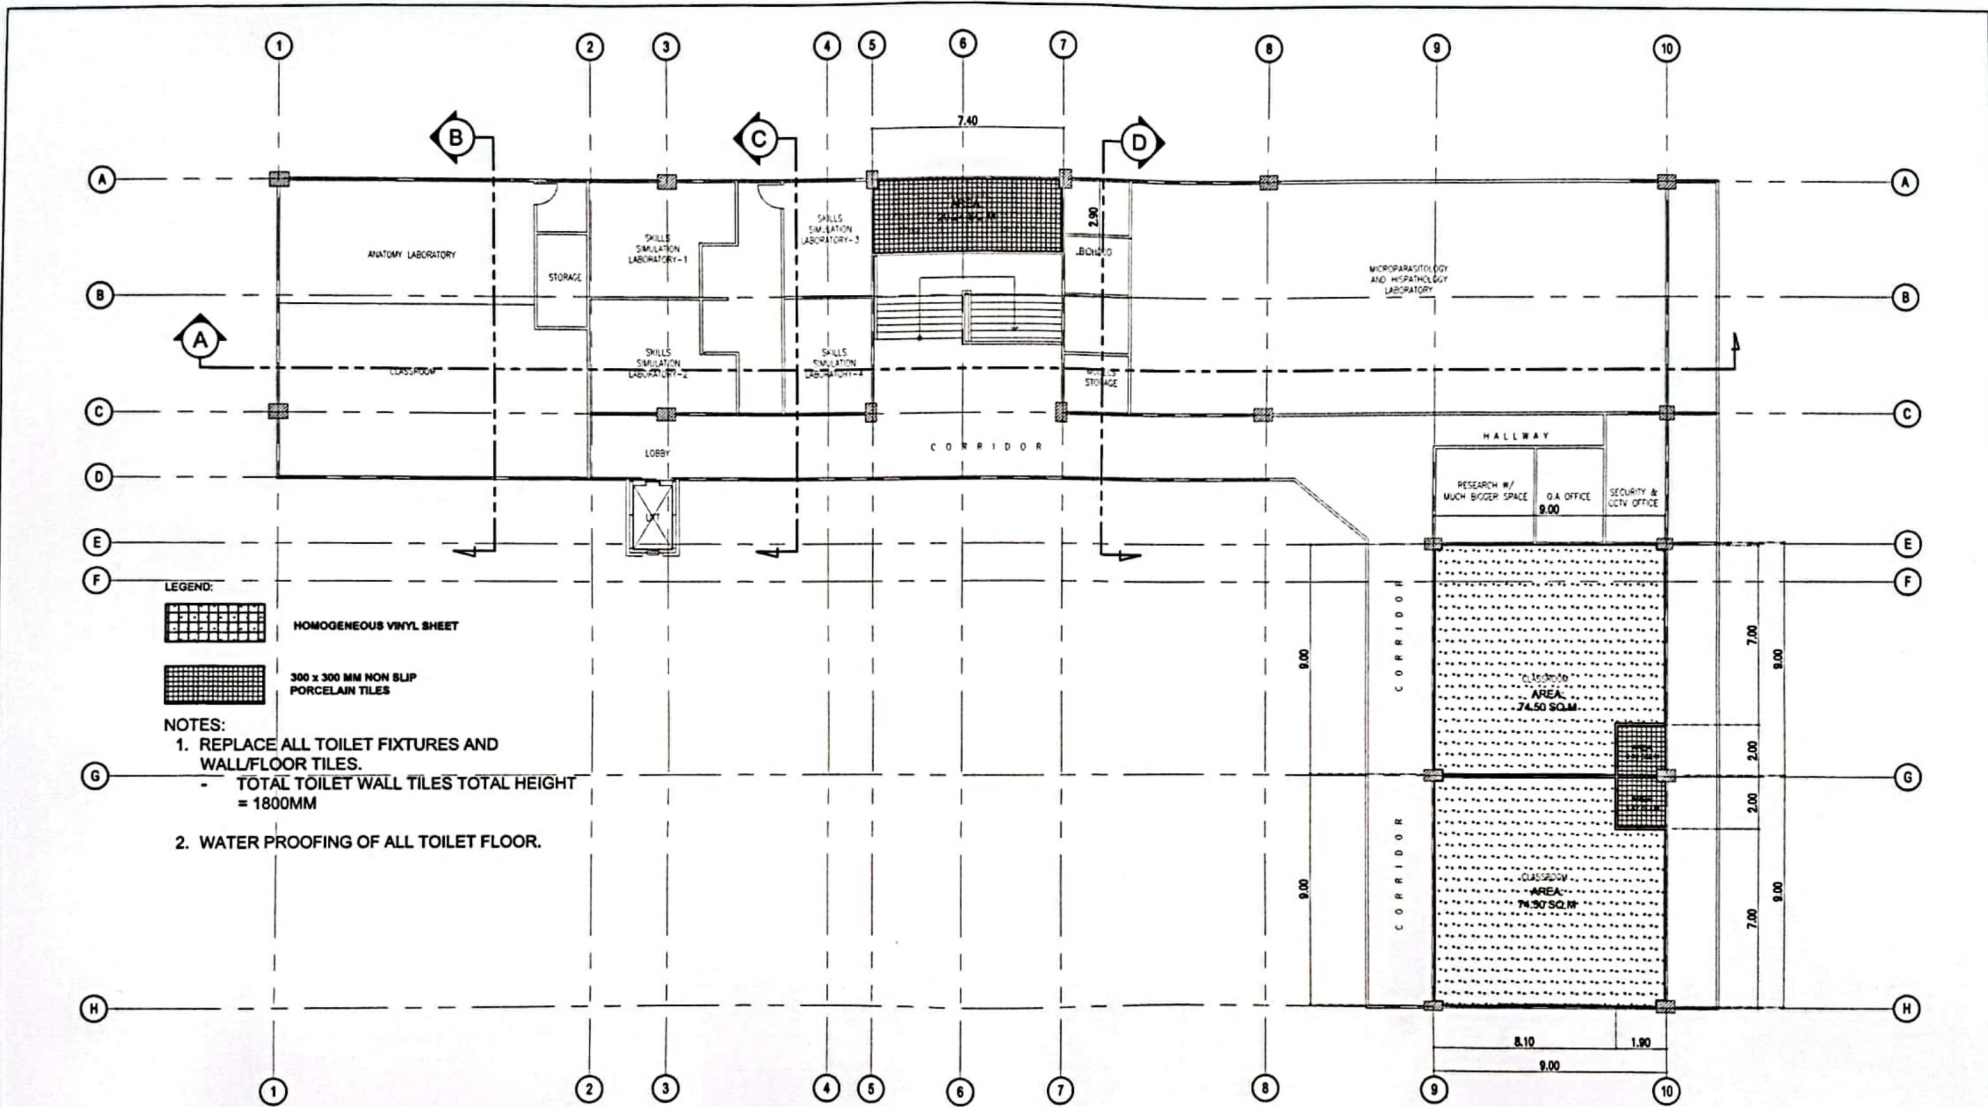


- LEGEND:**
- HOMOGENEOUS VINYL SHEET
 - 300 x 300 MM NON SLIP PORCELAIN TILES

- NOTES:**
1. REPLACE ALL TOILET FIXTURES AND WALL/FLOOR TILES.
- TOTAL TOILET WALL TILES TOTAL HEIGHT = 1800MM
 2. WATER PROOFING OF ALL TOILET FLOOR.

1 SECOND FLOOR (FLOOR FINISH SCHEDULE)
 A 26 SCALE: 1:200M

 USTP <small>UNIVERSITY OF SCIENCE & TECHNOLOGY OF SOUTHERN PHILIPPINES</small>	REPUBLIC OF THE PHILIPPINES UNIVERSITY OF SCIENCE & TECHNOLOGY OF SOUTHERN PHILIPPINES CIVIL AND SANITARY WORKS UNIT <small>C. P. RECTO AVENUE, LAPASAN 9000 CAGAYAN DE ORO CITY TEL. NO. (0862) 75-66-68 / (086) 856-1756 / 856-1759 TOLL FAX (086) 856-1686 WEB SITE: WWW.USTP.EDU.PH</small>	PREPARED BY: ENGR. EDMUND LOYD S. BALARIN <small>ASSISTANT DIRECTOR, APS</small>	PROJECT: PROPOSED RENOVATION OF ITB (BLDG. 3) AS THE COLLEGE OF MEDICINE (PHASE 2)	NOTED BY: ATTY. JONATHAN S. OPRE <small>VICE CHANCELLOR FOR FINANCE AND ADMINISTRATION</small>	RECOMMENDING APPROVAL: ATTY. DIONEL O. ALBINA <small>CHANCELLOR, USTP-CDO CAMPUS</small>	APPROVED: DR. AMÉRICO B. CULTURA II <small>UNIVERSITY PRESIDENT</small>	SHEET TITLE: 1. SECOND FLOOR (FLOOR FINISH SCHEDULE)	DRAWN BY: G.C.H. DATE: 08-02-22 CAD BY: R.P.E. DATE: 08-02-22	SHEET NO. A 26 26 44
	LOCATION: C.H. RECTO AVE., LAPASAN HIGHWAY, CAGAYAN DE ORO CITY OWNER: UNIVERSITY OF SCIENCE & TECHNOLOGY OF SOUTHERN PHILIPPINES		PROJ. NO.: TBN DATE ISSUED:	PTC. NO.: DATE ISSUED:	NOTED BY: ATTY. JONATHAN S. OPRE <small>VICE CHANCELLOR FOR FINANCE AND ADMINISTRATION</small>	RECOMMENDING APPROVAL: ATTY. DIONEL O. ALBINA <small>CHANCELLOR, USTP-CDO CAMPUS</small>	APPROVED: DR. AMÉRICO B. CULTURA II <small>UNIVERSITY PRESIDENT</small>	SHEET TITLE: 1. SECOND FLOOR (FLOOR FINISH SCHEDULE)	DRAWN BY: G.C.H. DATE: 08-02-22 CAD BY: R.P.E. DATE: 08-02-22

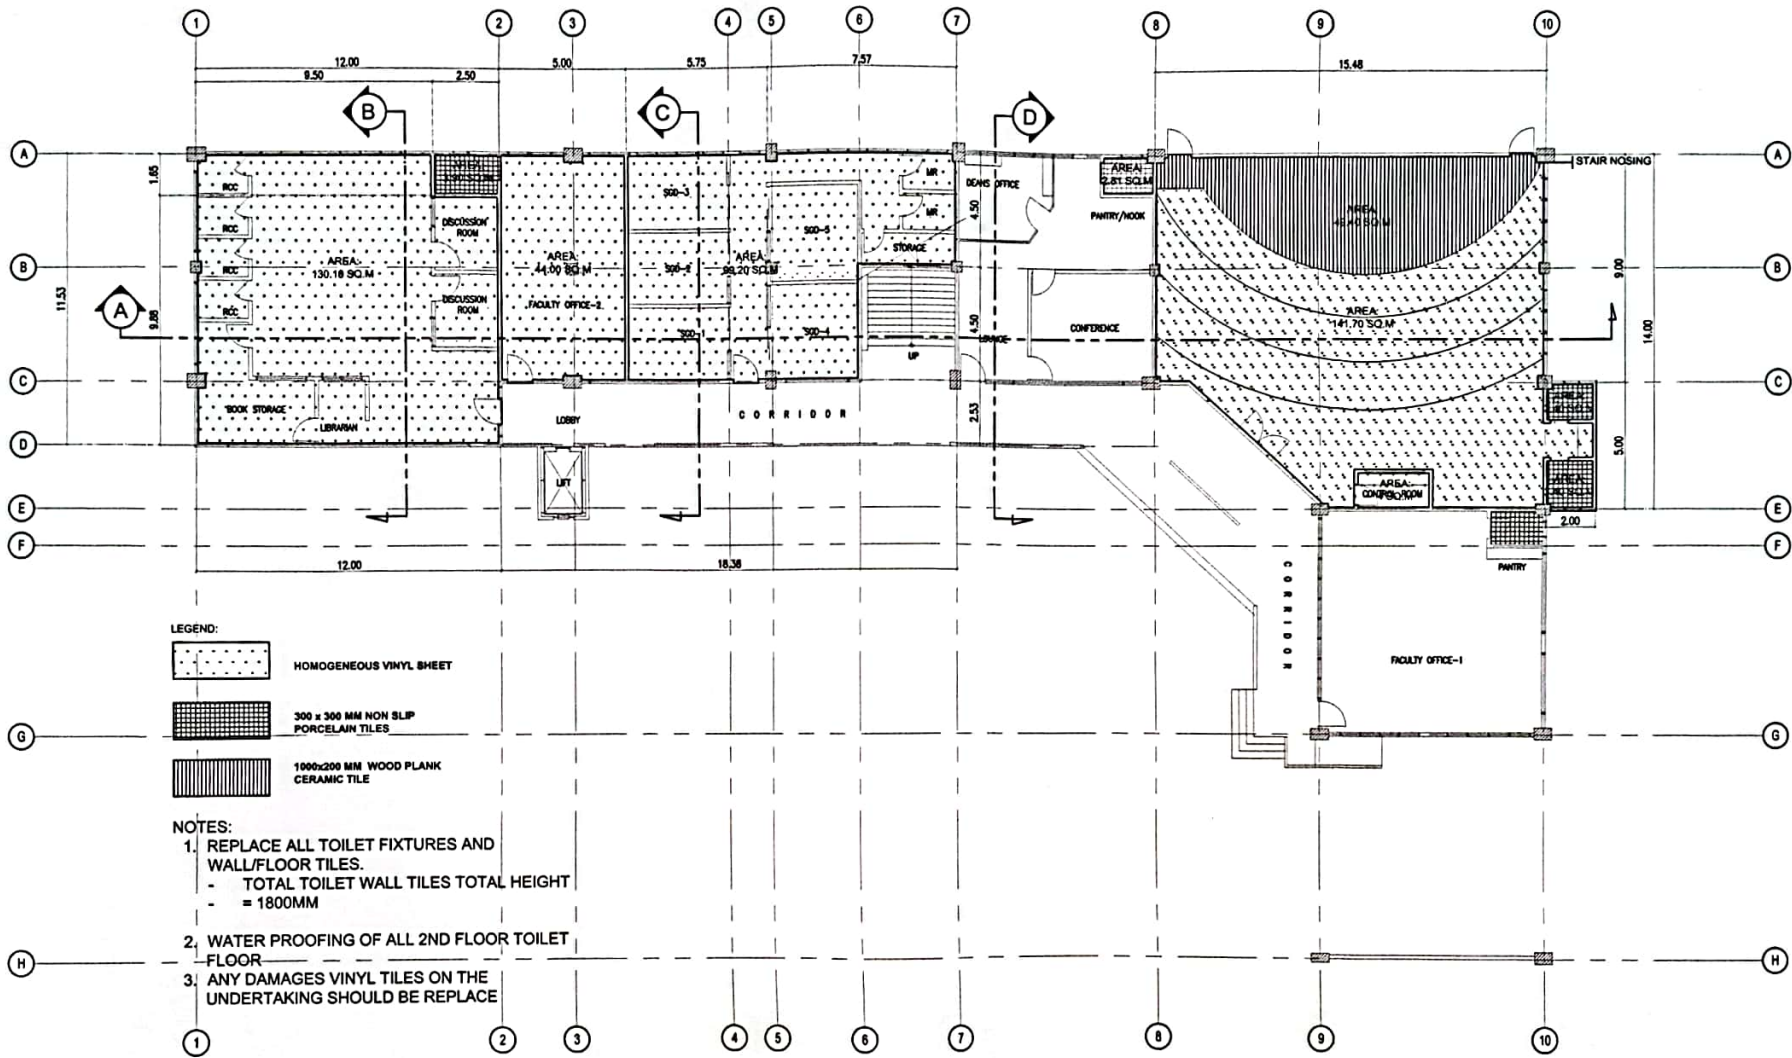

LEGEND:


- HOMOGENEOUS VINYL SHEET
- 300 x 300 MM NON SLIP PORCELAIN TILES
- 1000x200 MM WOOD PLANK CERAMIC TILE

NOTES:

1. REPLACE ALL TOILET FIXTURES AND WALL/FLOOR TILES.
 - TOTAL TOILET WALL TILES TOTAL HEIGHT = 1800MM
2. WATER PROOFING OF ALL 2ND FLOOR TOILET FLOOR
3. ANY DAMAGES VINYL TILES ON THE UNDERTAKING SHOULD BE REPLACE

1 GROUND FLOOR (FLOOR FINISH SCHEDULE)
 SCALE: 1:200M

 USTP <small>UNIVERSITY OF SCIENCE & TECHNOLOGY OF SOUTHERN PHILIPPINES</small>	REPUBLIC OF THE PHILIPPINES UNIVERSITY OF SCIENCE & TECHNOLOGY OF SOUTHERN PHILIPPINES CIVIL AND SANITARY WORKS UNIT <small>C. H. RECTO AVENUE, LAPASAN 9000 CAGAYAN DE ORO CITY TEL. NO. (08822) 72-60-85 / (088) 856-1754 / 856-1754 TOLL FAX (088) 856-0476 WEB SITE: WWW.USSTP.EDU.PH</small>	PREPARED BY: ENGR. EDGER L. OROS, S. BALABIS <small>ASST. INT. DIRECTOR, IAW</small>	PROJECT: PROPOSED RENOVATION OF ITB (BLDG. 3) AS THE COLLEGE OF MEDICINE (PHASE 2)	NOTED BY: ATTY. FERDINAND S. DUMA <small>DIRECTOR, BUREAU OF ENGINEERING & SURVEYING</small>	RECOMMENDING APPROVAL: ATTY. JONATHAN S. OCHE <small>VICE CHANCELLOR FOR FINANCE AND ADMINISTRATION</small>	RECOMMENDING APPROVAL: ATTY. DIONEL O. ALBINA <small>CHANCELLOR, USTP-CDO CAMPUS</small>	APPROVED: DR. AMBRICIO B. CULTURA II <small>UNIVERSITY PRESIDENT</small>	SHEET TITLE: 1. GROUND FLOOR (FLOOR FINISH SCHEDULE)	DRAWN BY: G.C.H. DATE: 08-11-22 CAD BY: R.P.E. DATE: 08-11-22	SHEET NO. <div style="border: 1px solid black; padding: 5px; text-align: center;"> A 27 27 44 </div>	
	<small>C. H. RECTO AVENUE, LAPASAN 9000 CAGAYAN DE ORO CITY TEL. NO. (08822) 72-60-85 / (088) 856-1754 / 856-1754 TOLL FAX (088) 856-0476 WEB SITE: WWW.USSTP.EDU.PH</small>		LOCATION: C. H. RECTO AVE., LAPASAN HIGHWAY, CAGAYAN DE ORO CITY OWNER: UNIVERSITY OF SCIENCE & TECHNOLOGY OF SOUTHERN PHILIPPINES		DATE ISSUED:		DATE: 08-11-22		DATE: 08-11-22		DATE: 08-11-22

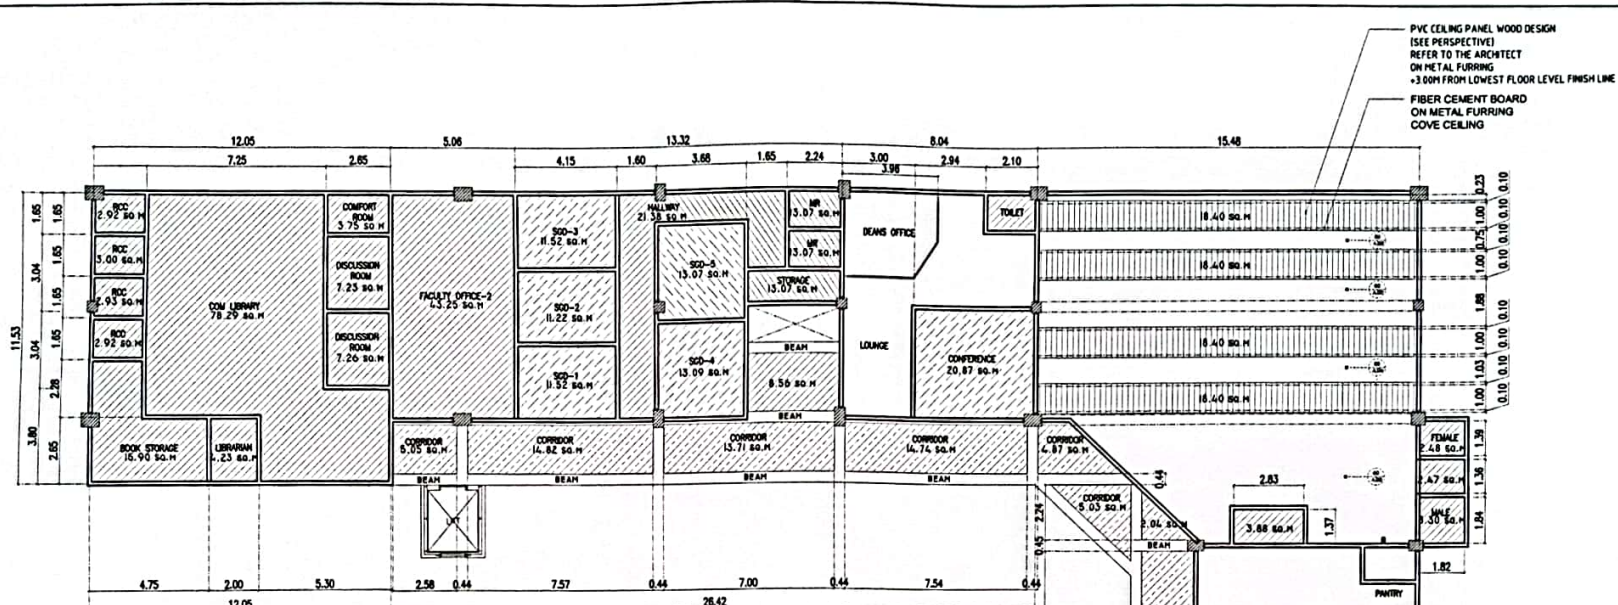

1 GROUND FLOOR REFLECTED CEILING PLAN
 A 28 SCALE: 1:200M

<p>REPUBLIC OF THE PHILIPPINES UNIVERSITY OF SCIENCE & TECHNOLOGY OF SOUTHERN PHILIPPINES CIVIL AND SANITARY WORKS UNIT</p> <p>C.H. RECTO AVENUE, LAPASAAN 9000 CAGAYAN DE ORO CITY TEL. NOS (08622) 78-00-88 / (0862) 854-1734 / 854-1739 FAX (0862) 854-0490 WWW SITE: WWW.USTP.EDU.PH</p>	PREPARED BY: ENGR. EDEGM LLOYD S. BALABIS ARCHITECT	PROJECT: PROPOSED RENOVATION OF ITB (BLDG. 3) AS THE COLLEGE OF MEDICINE (PHASE 2)	NOTED BY: ARNEL FERDINAND Z. DUHRA DIRECTOR, CIVIL AND SANITARY WORKS UNIT	RECOMMENDING APPROVAL: ATTY. JONATHAN S. OCHO VICE CHANCELLOR FOR FINANCE AND ADMINISTRATION	RECOMMENDING APPROVAL: ATTY. GHAZEL O. ALBINA CHANCELLOR, USTP-CDO CAMPUS	APPROVED: DR. AMBRACIO B. CULTURA II UNIVERSITY PRESIDENT	SHEET TITLE: GROUND FLOOR REFLECTED CEILING PLAN	DRAWN BY: G.C.H. DATE: 08-11-22	SHEET NO: A 28 44
	PRC NO.: PTR NO.: TIN: DATE ISSUED:	LOCATION: C.H. RECTO AVE., LAPASAAN HIGHWAY, CAGAYAN DE ORO CITY OWNER: UNIVERSITY OF SCIENCE & TECHNOLOGY OF SOUTHERN PHILIPPINES	SHEET CONTENTS: 1. GROUND FLOOR REFLECTED CEILING PLAN	DATE: 08-11-22	CAD BY: R.P.B. DATE: 08-11-22				

NOTE:


- REPLACE ALL DAMAGED 60X60 SIZE ACOUSTIC BOARDS AS SHOWN IN THE DRAWING PAINT W/ BLACK (FLAT)
- REMOVE ALL EXISTING ELECTRICAL LIGHTS
- REMOVE ALL EXISTING SPOTLIGHTS

- REMOVE EXISTING SPOTLIGHTS
- REPAINT EXISTING 60X60 ACOUSTIC BOARD & T-RUNNERS W/ BLACK PAINT (FLAT)


- REMOVE DAMAGED EXISTING ACOUSTIC BOARDS

LEGEND:

- - DAMAGED 60X60 SIZE ACOUSTIC BOARDS AS SHOWN IN THE DRAWING PAINT W/ BLACK (FLAT)
- - EXISTING ELECTRICAL LIGHTS
- ⊗ - EXISTING SPOTLIGHTS

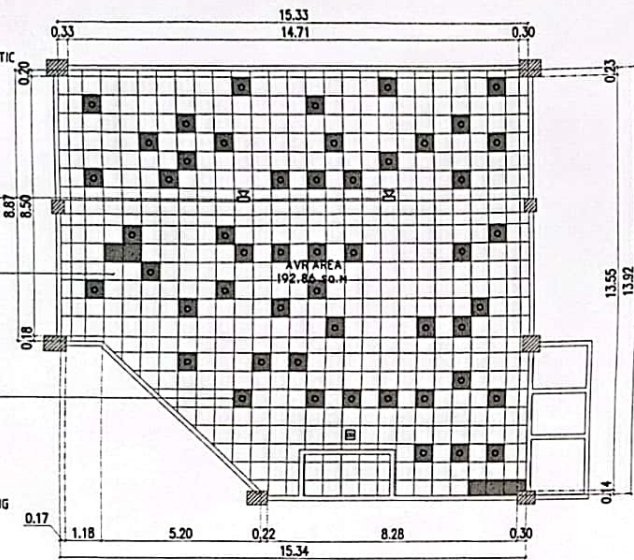

1 EXISTING A.V.R. CEILING PLAN
A/29 SCALE: 1:175M

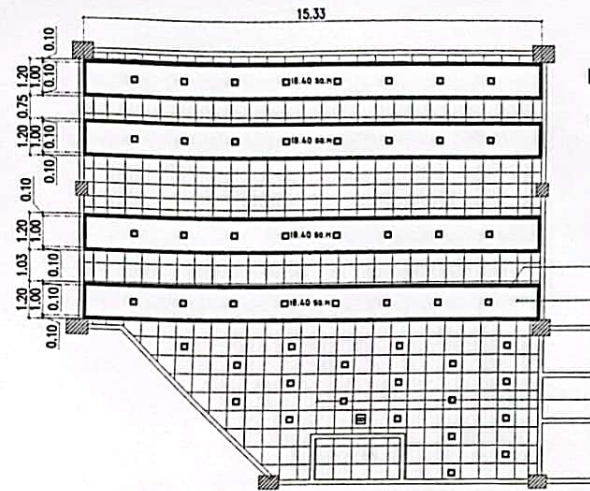


2 PROPOSED A.V.R. CEILING PLAN
A/29 SCALE: 1:175M

LEGEND:


- 24 WATTS T5 FLUORESCENT LAMP (WARM WHITE) (COVE LIGHTING)
- SQUARE CUT-OUT: 150X150MM 15 1/8" 6500K (DAYLIGHT)


- FIBER CEMENT BOARD ON METAL FURRING COVE CEILING
- PVC CEILING PANEL WOOD DESIGN (SEE PERSPECTIVE) REFER TO THE ARCHITECT ON METAL FURRING +3.00M FROM LOWEST FLOOR LEVEL FINISH LINE

- REPAINT EXISTING 60X60 ACOUSTIC BOARD & T-RUNNERS W/ BLACK PAINT (FLAT) +3.30M FROM LOWEST FLOOR LEVEL FINISH LINE

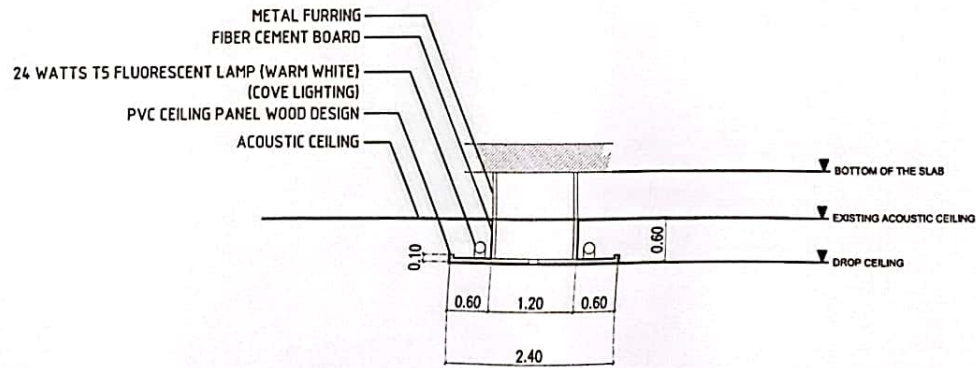


3 COVE CEILING DETAIL
A/29 SCALE: 1:75M


 <p>REPUBLIC OF THE PHILIPPINES UNIVERSITY OF SCIENCE & TECHNOLOGY OF SOUTHERN PHILIPPINES CIVIL AND SANITARY WORKS UNIT</p> <p>C.H. RECTO AVENUE, LAPASAN 9000 CAGAYAN DE ORO CITY TEL. NOS. (08622) 72-65-45 / (086) 856-1738 / 856-1739 TELE FAX (086) 856-4893 WEB SITE: WWW.USTIP.EDU.PH</p>	<p>PREPARED BY: <i>[Signature]</i> ENGR. EDGEM LLOYD S. BALABIS ASSISTANT DIRECTOR, AHS</p>	<p>PROJECT: PROPOSED RENOVATION OF ITB (BLDG. 3) AS THE COLLEGE OF MEDICINE (PHASE 2)</p>	<p>NOTED BY: <i>[Signature]</i> DR. FERDINAND A. DUMPA DIRECTOR, AHS MANAGEMENT SERVICES</p>	<p>RECOMMENDING APPROVAL: <i>[Signature]</i> ATTY. JONATHAN S. OCHE VICE CHANCELLOR FOR FINANCE AND ADMINISTRATION</p>	<p>RECOMMENDING APPROVAL: <i>[Signature]</i> ATTY. LIONEL O. ALBINA CHANCELLOR, USTP-CDO CAMPUS</p>	<p>APPROVED: <i>[Signature]</i> DR. AMBROSIO M. CULTURA II UNIVERSITY PRESIDENT</p>	<p>SHEET TITLE: 1. EXISTING A.V.R. CEILING PLAN 2. PROPOSED A.V.R. CEILING PLAN 3. COVE CEILING DETAIL</p>	<p>DRAWN BY: G.C.H. DATE: 08-11-22</p>	<p>SHEET NO. A/29 29 44</p>
	<p>PRC NO.: PTR NO.:</p>	<p>DATE ISSUED:</p>	<p>LOCATION: C.H. RECTO AVE., LAPASAN HIGHWAY, CAGAYAN DE ORO CITY</p>	<p>OWNER: UNIVERSITY OF SCIENCE & TECHNOLOGY OF SOUTHERN PHILIPPINES</p>	<p>DATE: 08-11-22</p>	<p>DATE: 08-11-22</p>	<p>DATE: 08-11-22</p>		

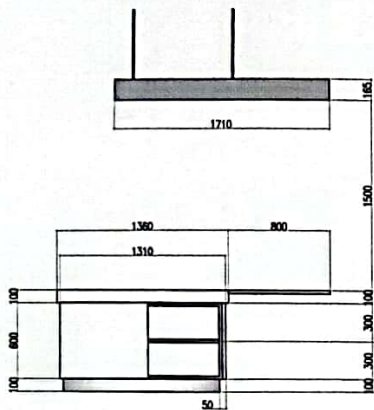


1 LEFT SIDE VIEW
A/30

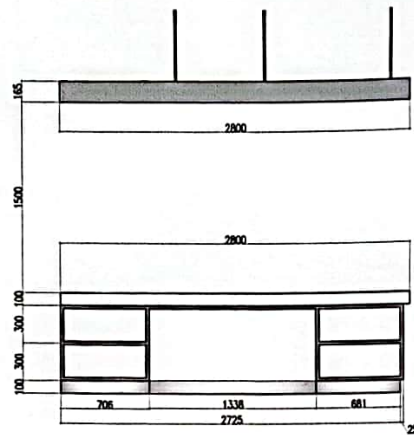

2 FRONT VIEW
A/30

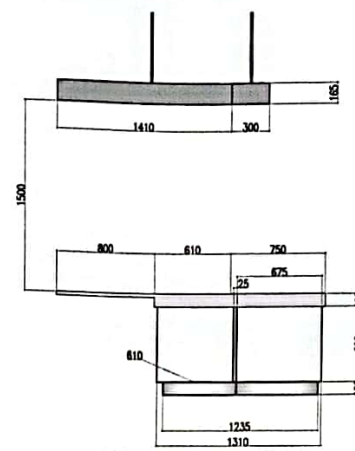

3 RIGHT SIDE VIEW
A/30

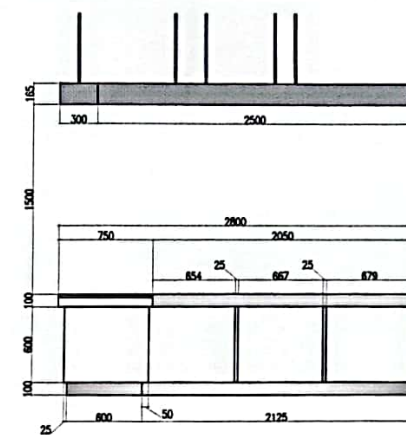

4 REAR VIEW
A/30




80mm CABLE CROWN HOLE
COLOR: GREY


TABLE TOP:
USE 25mm THK. MARINE PLYBOARD
AUTOMOTIVE SPRAY PAINT (WHITE)



 COUNTERFLAP w/ Height
25mm THK. MARINE PLYBOARD
W/ BEECH WOOD DESIGN LAMINATE AND EDGING




25mm THK. MARINE PLYBOARD
WHITE PAINT (SHEG GLOSS)

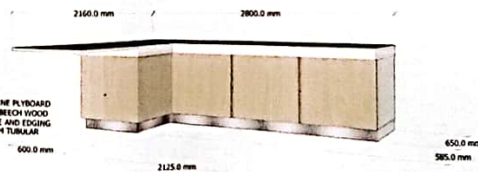

25mm THK. MARINE PLYBOARD
W/ BEECH WOOD
DESIGN LAMINATE AND EDGING
ALUMINUM TUBULAR

ALUMINUM TUBULAR

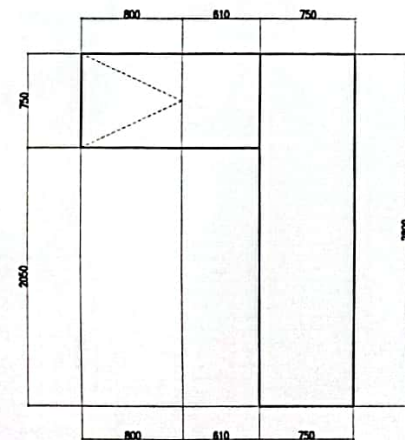


5 TOP VIEW
A/30


6 FACULTY OFFICE 2 COUNTER DETAIL 1(1 SET)
A/30 SCALE:

7 FACULTY OFFICE 2 COUNTER DETAIL 2(1SET)
A/30 SCALE:


<p>REPUBLIC OF THE PHILIPPINES UNIVERSITY OF SCIENCE & TECHNOLOGY OF SOUTHERN PHILIPPINES CIVIL AND SANITARY WORKS UNIT</p> <p>C. H. RECTO AVENUE, LAPASAN 8000 CAGAYAN DE ORO CITY TEL. NBR. (0842) 72-00-65 / (0842) 854-1738 / 854-1739 TELA FAX (0842) 856-0495 WEB SITE: WWW.USTP.EDU.PH</p>	<p>PREPARED BY: <i>[Signature]</i> ENGR. EDGEM LLOYD S. BALABIS ASST. DIR. / DIRECTOR ASST.</p>	<p>PROJECT: PROPOSED RENOVATION OF ITB (BLDG. 3) AS THE COLLEGE OF MEDICINE (PHASE 2)</p>	<p>NOTED BY: <i>[Signature]</i> DR. FERDINANDO B. PUYA DIRECTOR, ASST. DIR. / MANAGEMENT SERVICES</p>	<p>RECOMMENDING APPROVAL: <i>[Signature]</i> ATTY. JONATHAN S. OCHER VICE CHANCELLOR FOR FINANCE AND ADMINISTRATION</p>	<p>RECOMMENDING APPROVAL: <i>[Signature]</i> ATTY. DONEL O. ALBINA CHANCELLOR, USTP-CDO CAMPUS</p>	<p>APPROVED: <i>[Signature]</i> DR. AMBROSIO M. CULTURA II UNIVERSITY PRESIDENT</p>	<p>SHEET TITLE: SHEET CONTENTS: 1. FACULTY OFFICE 2 ELEVATIONS 2. FACULTY OFFICE 2 DETAILS</p>	<p>DRAWN BY: S. C.H. DATE: 06-04-22 CAD BY: R.P.E. DATE: 06-04-22</p>	<p>SHEET NO. A 30 44</p>
	<p>PRC NO.: PTR NO.:</p>	<p>DATE ISSUED:</p>	<p>LOCATION: OWNER:</p>	<p>C. H. RECTO AVENUE, LAPASAN NEHRWAY, CAGAYAN DE ORO CITY UNIVERSITY OF SCIENCE & TECHNOLOGY OF SOUTHERN PHILIPPINES</p>					

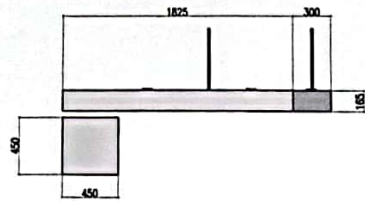


1 LEFT SIDE VIEW
A/31

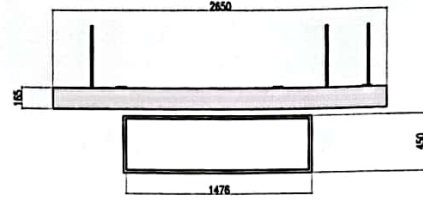






2 FRONT VIEW
A/31

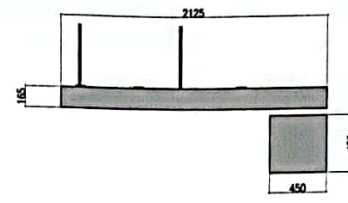


3 RIGHT SIDE VIEW
A/31

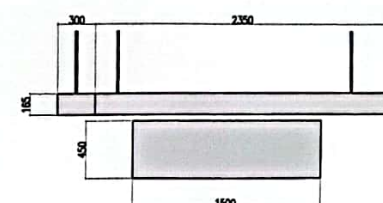


4 REAR VIEW
A/31

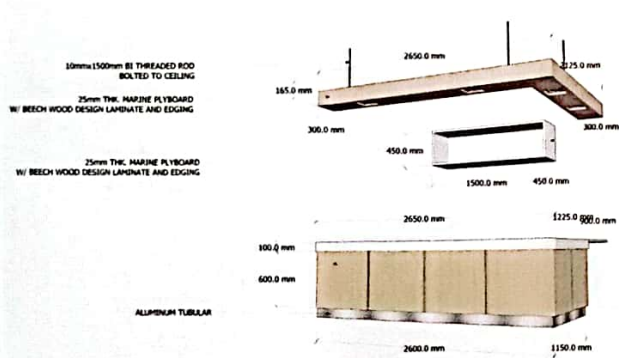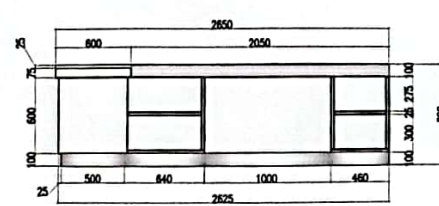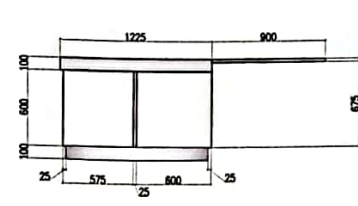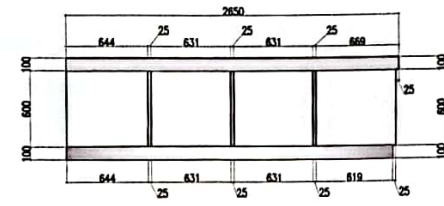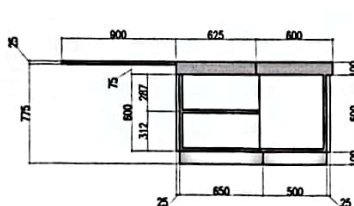

6 LIBRARY RECEPTION COUNTER DETAIL 1 (1 SET)
A/31 SCALE:

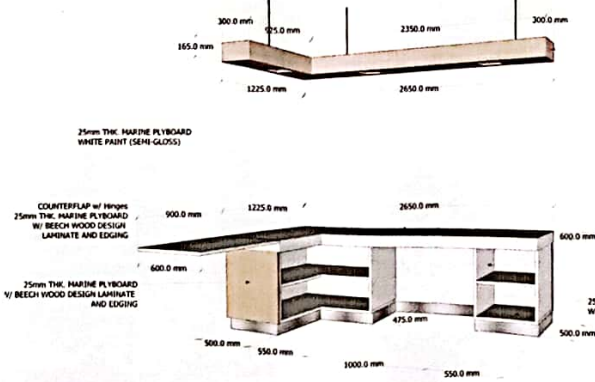


7 LIBRARY RECEPTION COUNTER DETAIL 2 (1 SET)
A/31 SCALE:

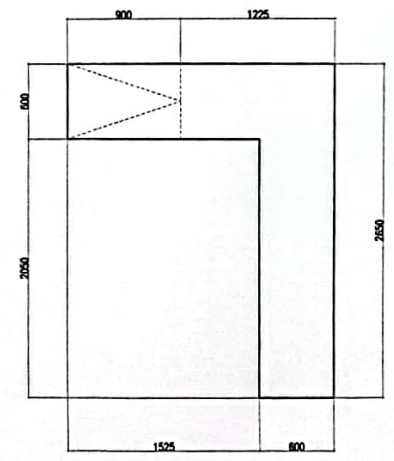


5 TOP VIEW
A/31


<p>REPUBLIC OF THE PHILIPPINES UNIVERSITY OF SCIENCE & TECHNOLOGY OF SOUTHERN PHILIPPINES CIVIL AND SANITARY WORKS UNIT C. H. RECTO AVENUE, LAPASAH 9000 CASAYAN II ONE CITY TEL. NO. (088) 227-66-65 / (088) 856-7738 / 856-1739 TELE FAX (088) 856-1695 WWW.USTP.UTP.PH</p>	<p>PREPARED BY: ENGR. EDGAR LLOYD S. BALABIS ASST. DIR. DIRECTOR, UWS</p>	<p>PROJECT: PROPOSED RENOVATION OF ITB (BLDG. 3) AS THE COLLEGE OF MEDICINE (PHASE 2)</p>	<p>NOTED BY: ATY. FERDINAND A. LIMBA DIRECTOR, SANITARY MANAGEMENT SERVICES</p>	<p>RECOMMENDING APPROVAL: ATTY. JONATHAN S. OCHE VICE CHANCELLOR FOR FINANCE AND ADMINISTRATION</p>	<p>RECOMMENDING APPROVAL: ATTY. DIGNEL O. ALBINA CHANCELLOR, USTP-CNO CAMPUS</p>	<p>APPROVED: DR. AMBROSO C. CULTURA II UNIVERSITY PRESIDENT</p>	<p>SHEET TITLE 1. LIBRARY RECEPTION COUNTER ELEVATION 2. LIBRARY RECEPTION COUNTER DETAIL</p>	<p>DRAWN BY: S.C.H. DATE: 08-10-22</p>	<p>SHEET NO. A 31 44</p>
	<p>DATE ISSUED:</p>	<p>LOCATION: C. H. RECTO AVE., LAPASAH HIGHWAY, CASAYAN DE ORO CITY</p>	<p>OWNER: UNIVERSITY OF SCIENCE & TECHNOLOGY OF SOUTHERN PHILIPPINES</p>	<p>CAD BY: R.P.E. DATE: 08-10-22</p>					
	<p>PRC NO.: TPN</p>								

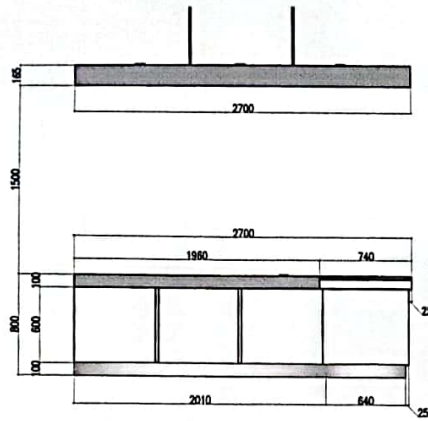


1 LEFT SIDE VIEW
A/B2

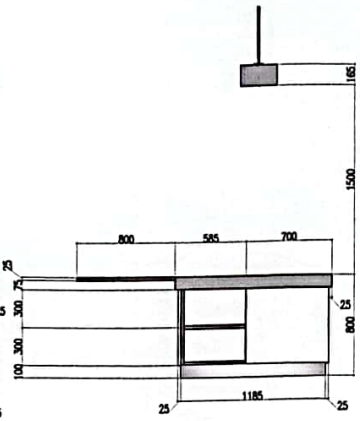

2 FRONT VIEW
A/B2

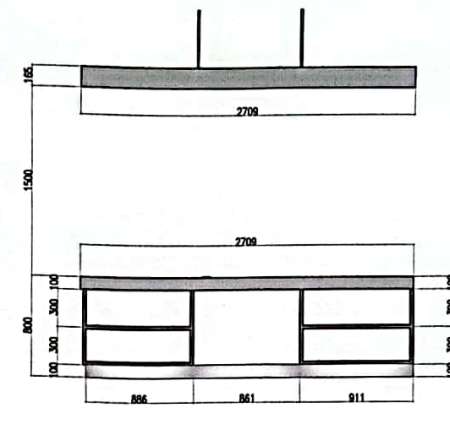

3 RIGHT SIDE VIEW
A/B2

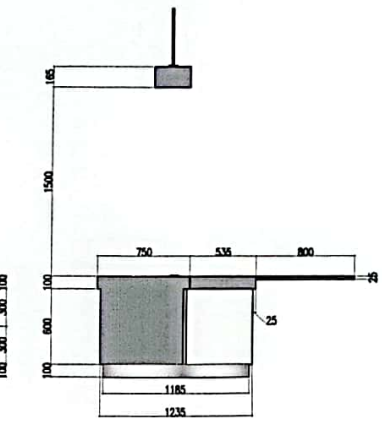



4 REAR VIEW
A/B2



5 FACULTY OFFICE 1 COUNTER DETAIL 1 (1SET)
SCALE:







6 FACULTY OFFICE 1 COUNTER DETAIL 2 (1 SET)
SCALE:

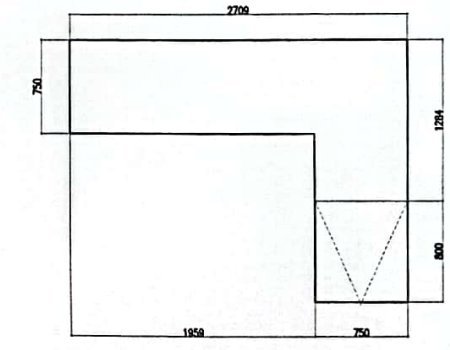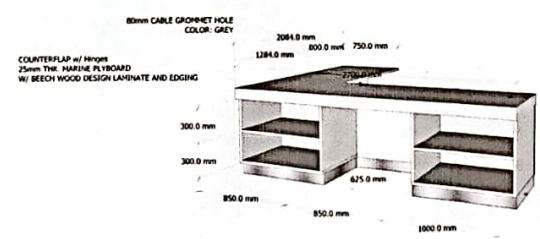



8 TOP VIEW
A/B2

<p>REPUBLIC OF THE PHILIPPINES UNIVERSITY OF SCIENCE & TECHNOLOGY OF SOUTHERN PHILIPPINES CIVIL AND SANITARY WORKS UNIT</p> <p>C. H. RECTO AVENUE, LAPASAN 9000 CAGAYAN DE ORO CITY TEL. Nos. (0862) 72-60-65 / (0862) 856-1730 / 856-1739 TRLS FAX (0862) 856-4890 WEB SITE: WWW.USTP.PH</p>	<p>PREPARED BY: <i>[Signature]</i> ENGR. EDGEM LLOYD S. BALABIS ASSISTANT DIRECTOR, ASB</p>	<p>PROJECT: PROPOSED RENOVATION OF ITB (BLDG. 3) AS THE COLLEGE OF MEDICINE (PHASE 2)</p>	<p>NOTED BY: <i>[Signature]</i> DR. FERDINAND A. ALPINA DIRECTOR, FACILITY MANAGEMENT SERVICES</p>	<p>RECOMMENDING APPROVAL: <i>[Signature]</i> ATTY. JONATHAN S. OCHE VICE CHANCELLOR FOR FINANCE AND ADMINISTRATION</p>	<p>RECOMMENDING APPROVAL: <i>[Signature]</i> ATTY. DIONELO ALBINA CHANCELLOR, USTP-CDO CAMPUS</p>	<p>APPROVED: <i>[Signature]</i> DR. AMBROSIO B. CULTURA II UNIVERSITY PRESIDENT</p>	<p>SHEET TITLE: FACULTY OFFICE 1 COUNTER ELEVATIONS FACULTY OFFICE 1 COUNTER DETAILS</p>	<p>DRAWN BY: E.C.H. DATE: 08-11-22</p>	<p>SHEET NO. A 32 44</p>
	<p>PRC NO.: TIM: PTN NO.: DATE ISSUED:</p>	<p>LOCATION: C.H RECTO AVE., LAPASAN HIGHWAY, CAGAYAN DE ORO CITY</p>	<p>OWNER: UNIVERSITY OF SCIENCE & TECHNOLOGY OF SOUTHERN PHILIPPINES</p>	<p>DATE: 08-11-22</p>					

 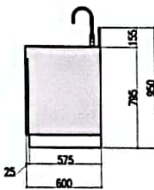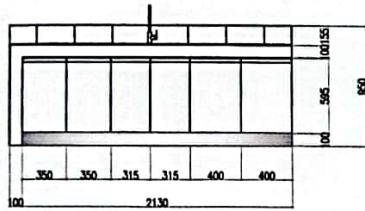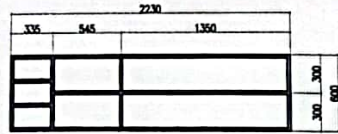



1 LEFT SIDE VIEW
A33

 2 FRONT VIEW
A33


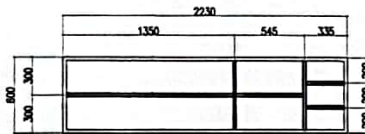


3 RIGHT SIDE VIEW
A33

4 REAR VIEW
A33

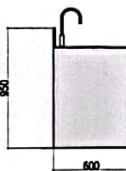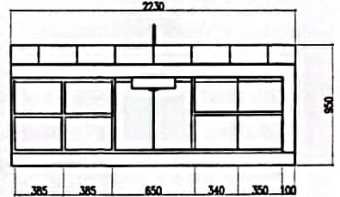

5 TOP VIEW
A32

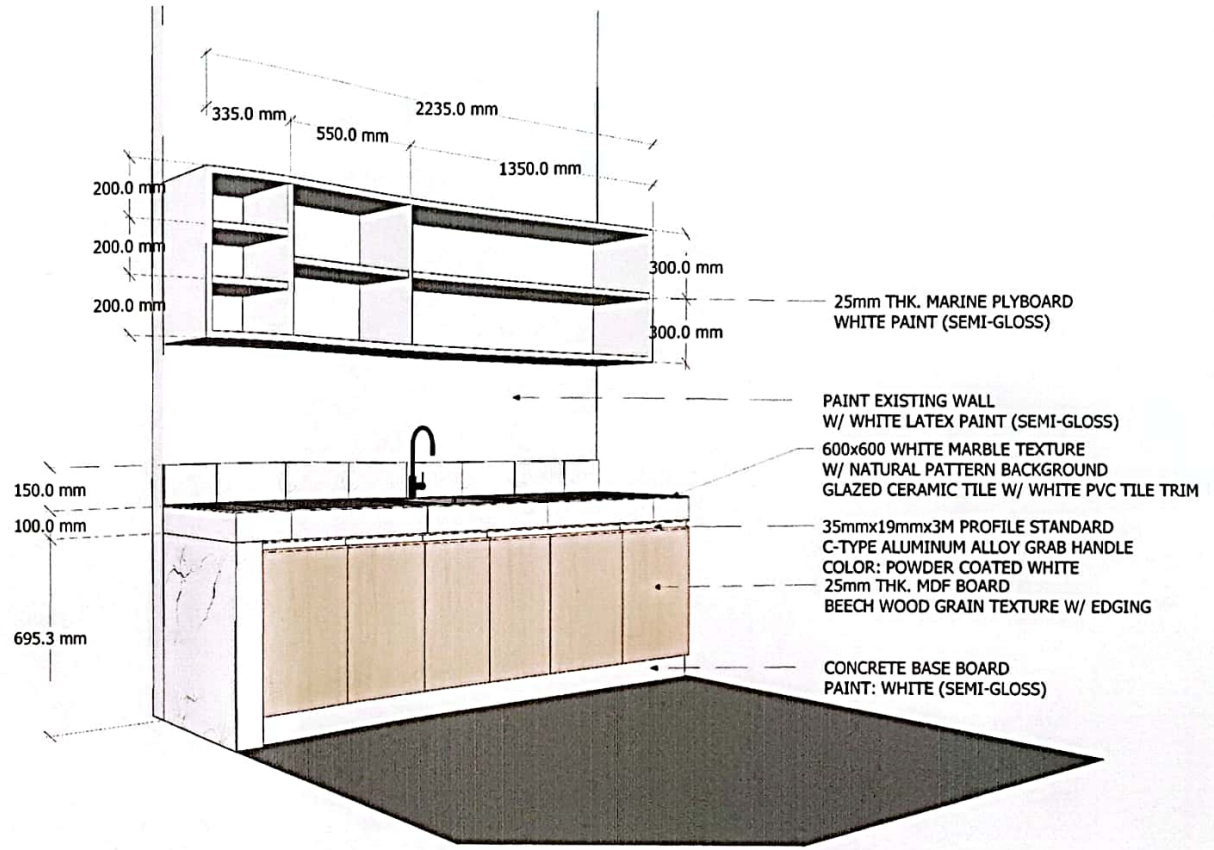 

6 PANTRY DETAIL (1 SET)
A33 SCALE:



REPUBLIC OF THE PHILIPPINES
UNIVERSITY OF SCIENCE & TECHNOLOGY OF SOUTHERN PHILIPPINES
CIVIL AND SANITARY WORKS UNIT
C.H. RECTO AVENUE, LAPANAN 9000 CAGAYAN DE ORO CITY
TEL. NOS. (08822) 72-60-65 / (0882) 856-1730 / 856-1734 TELS
FAX (088) 856-6496
WEB SITE: WWW.USTP.EDU.PH

PREPARED BY: *[Signature]*
ENGR. EDGEN MOYO S. BALABIS
ASSISTANT DIRECTOR APW

PROJECT: PROPOSED RENOVATION OF ITB (BLDG. 3) AS THE COLLEGE OF MEDICINE (PHASE 2)
LOCATION: C.H. RECTO AVE., LAPANAN HIGHWAY, CAGAYAN DE ORO CITY
OWNER: UNIVERSITY OF SCIENCE & TECHNOLOGY OF SOUTHERN PHILIPPINES

NOTED BY: *[Signature]*
DR. FERDINAND A. DEYRAN
DIRECTOR, HOSPITAL MANAGEMENT SERVICE


RECOMMENDING APPROVAL: *[Signature]*
ATTY. JONATHAN S. OCHE
VICE CHANCELLOR FOR FINANCE AND ADMINISTRATION

RECOMMENDING APPROVAL: *[Signature]*
ATTY. DENIEL O. ALBINA
CHANCELLOR, USTP-CDO CAMPUS

APPROVED: *[Signature]*
DR. AMBROSIO B. CULTURA II
UNIVERSITY PRESIDENT

SHEET TITLE: 1. PANTRY ELEVATIONS
2. PANTRY DETAILS
DRAWN BY: S.C.H.
DATE: 06-08-22
CAD BY: R.P.E.
DATE: 06-08-22


SHEET NO. A 33
33
44

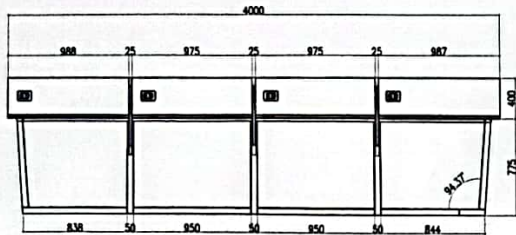


1 FRONT VIEW
A/34



2 LEFT SIDE VIEW
A/34

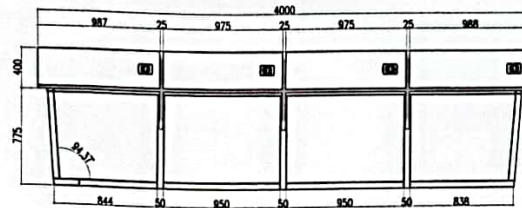

3 REAR VIEW
A/34

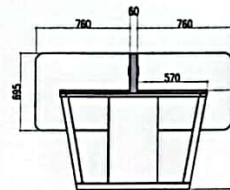

4 RIGHT SIDE VIEW
A/34

1 x 2 x 5mm RECTANGULAR G.I. STEEL TUBE
PRIMER: RED OXIDE
PAINT FINISH: WHITE (SEMI-GLOSS)
SCREWED TO MARINE PLYBOARD


25mm THK. MARINE PLYBOARD
WHITE PAINT (SEMI-GLOSS)
W/ BEECH WOOD DESIGN EDGING

DUPLEX CONVENIENCE OUTLET


25mm THK. MARINE PLYBOARD
WHITE PAINT (SEMI-GLOSS)

25mm THK. MARINE PLYBOARD
W/ BEECH WOOD DESIGN LAMINATE AND EDGING

1 x 2 x 3mm RECTANGULAR G.I. STEEL TUBE
PRIMER: RED OXIDE
PAINT FINISH: WHITE (SEMI-GLOSS)
25mm THK. MARINE PLYBOARD
W/ BEECH WOOD DESIGN LAMINATE AND EDGING

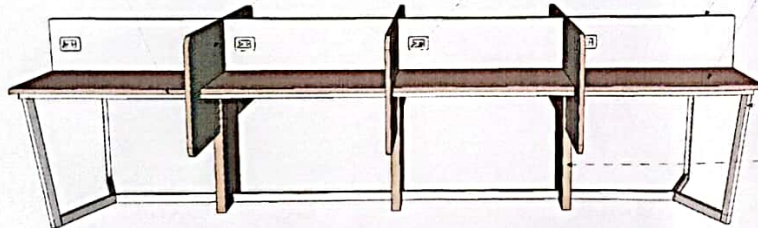

6 LIBRARY TABLE DETAIL (3 SETS)
A/34 SCALE:

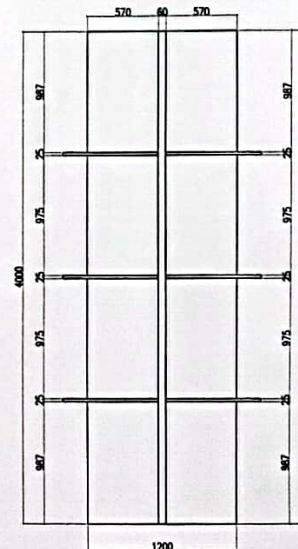

5 TOP VIEW
A/34



REPUBLIC OF THE PHILIPPINES
UNIVERSITY OF SCIENCE & TECHNOLOGY OF
SOUTHERN PHILIPPINES
CIVIL AND SANITARY WORKS UNIT

C. M. RECTO AVENUE, LAPASAN 9000 CAGAYAN DE ORO CITY
TEL. NO. (088) 227 72-80-85 / (088) 858-1738 / 858-1739 TRLX
FAX NO. (088) 858-1096
WEB SITE: WWW.USTIP.UMS.PH

PREPARED BY:
[Signature]
ENGR. EDGEN LLOYD S. BALABIS
ASST. CHIEF DIRECTOR, ASW

PROJECT: PROPOSED RENOVATION OF ITB
(BLDG. 3) AS THE COLLEGE OF
MEDICINE (PHASE 2)

LOCATION: C. M. RECTO AVE., LAPASAN HIGHWAY, CAGAYAN DE ORO CITY

OWNER: UNIVERSITY OF SCIENCE & TECHNOLOGY OF SOUTHERN PHILIPPINES

NOTED BY:
[Signature]
DR. FERNANDO B. DUMAGAN
DIRECTOR, ASST. CHIEF OF MANAGEMENT
DEVELOPMENT

RECOMMENDING APPROVAL:
[Signature]
ATTY. JONATHAN S. OCHE
VICE CHANCELLOR FOR FINANCE
AND ADMINISTRATION


RECOMMENDING APPROVAL:
ATTY. DIONEL O. ALBINA
CHANCELLOR, USTP-CAO CAMPUS

APPROVED:
[Signature]
DR. AMBRISIO B. CULTURA II
UNIVERSITY PRESIDENT


SHEET TITLE:
1. LIBRARY TABLE
ELEVATIONS
2. LIBRARY TABLE
DETAILS

DRAWN BY: G.C.H.
DATE: 08-0-22
CAD BY: R.P.E.
DATE: 08-0-22


SHEET NO.
A
34
34
44

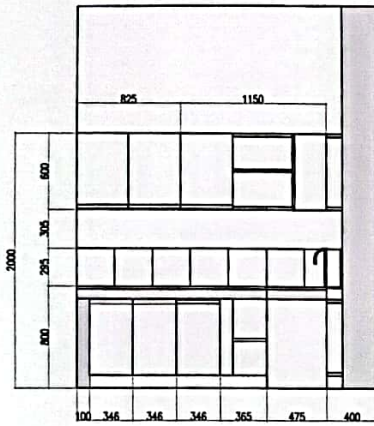


1 FRONT VIEW
A/32

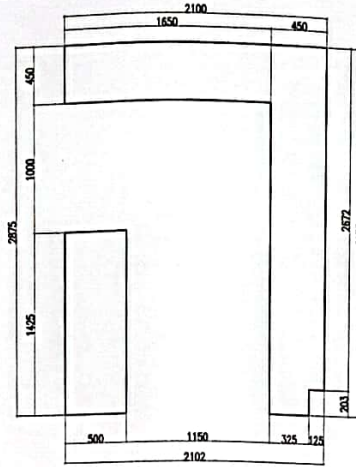


3 TOP VIEW
A/27

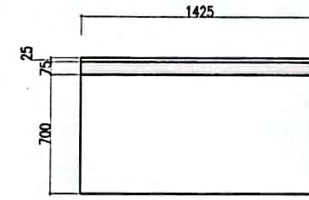


4 NOOK FRONT VIEW
A/32

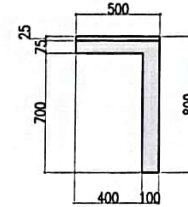

5 NOOK RIGHT SIDE VIEW
A/32

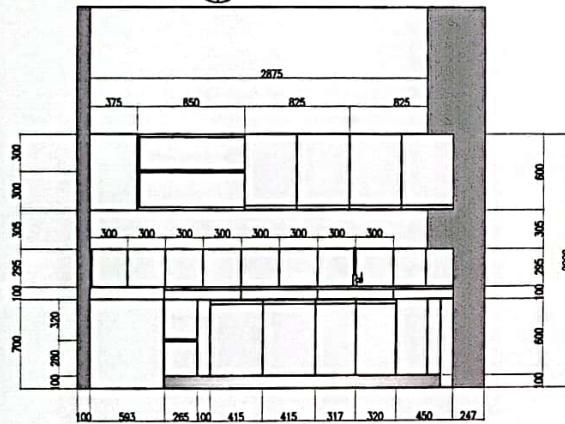

2 RIGHT SIDE VIEW
A/32

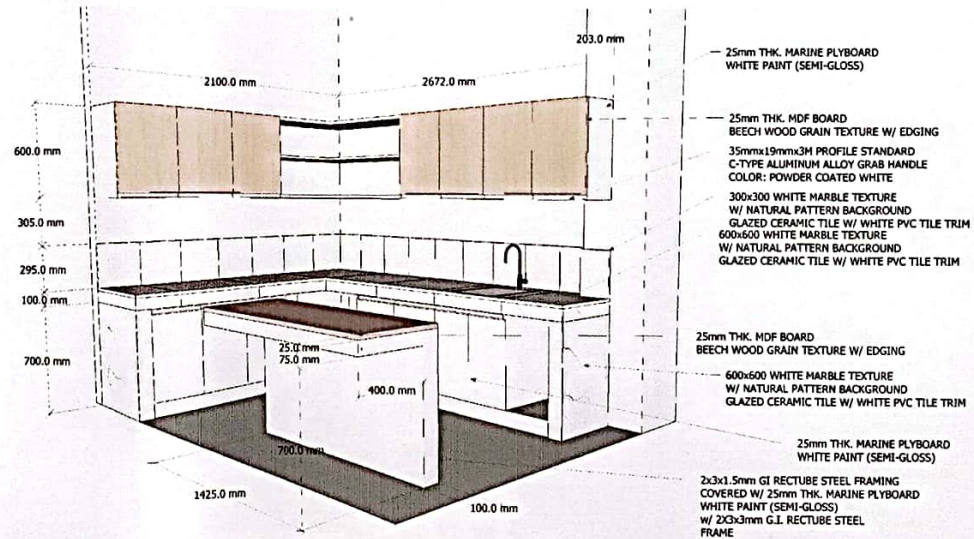

6 KITCHEN DETAIL (1 SET)
A/32 SCALE:



REPUBLIC OF THE PHILIPPINES
UNIVERSITY OF SCIENCE & TECHNOLOGY OF SOUTHERN PHILIPPINES
CIVIL AND SANITARY WORKS UNIT
C.H. RECTO AVENUE, LAPASAN 9000 CAGAYAN DE ORO CITY
TEL. NO. (08622) 71-66-65 / (086) 856-1734 / 856-1739 TELS
FAX (086) 856-4906
WEB SITE: WWW.USTIP.UMSU.PH

PREPARED BY: *[Signature]*
ENGR. EDGEMILLOYD S. BALABIS
ASSISTANT DIRECTOR, A/S
PROJECT: PROPOSED RENOVATION OF ITB (BLDG. 3) AS THE COLLEGE OF MEDICINE (PHASE 2)
PNC NO.:
TIM:
PTR NO.:
DATE ISSUED:

LOCATION: C.H. RECTO AVE., LAPASAN HIGHWAY, CAGAYAN DE ORO CITY
OWNER: UNIVERSITY OF SCIENCE & TECHNOLOGY OF SOUTHERN PHILIPPINES

NOTED BY: *[Signature]*
DR. FERDINAND A. LUNGA
DIRECTOR GENERAL MANAGEMENT SERVICES


RECOMMENDING APPROVAL: *[Signature]*
ATTY. JONATHAN S. OCHE
VICE CHANCELLOR FOR FINANCE AND ADMINISTRATION

RECOMMENDING APPROVAL: *[Signature]*
G. PTY. DIONEL O. ALBINA
CHANCELLOR, USTIP-CDO CAMPUS


APPROVED: *[Signature]*
DR. AMBROSIO S. CULTURA II
UNIVERSITY PRESIDENT

SHEET TITLE: SHEET CONTENTS:
1. KITCHEN VIEWS
2. KITCHEN DETAILS
DATE: 06-09-22
CAD BY: R.P.P.E.
DATE: 06-09-22

SHEET NO. A/32
35
44

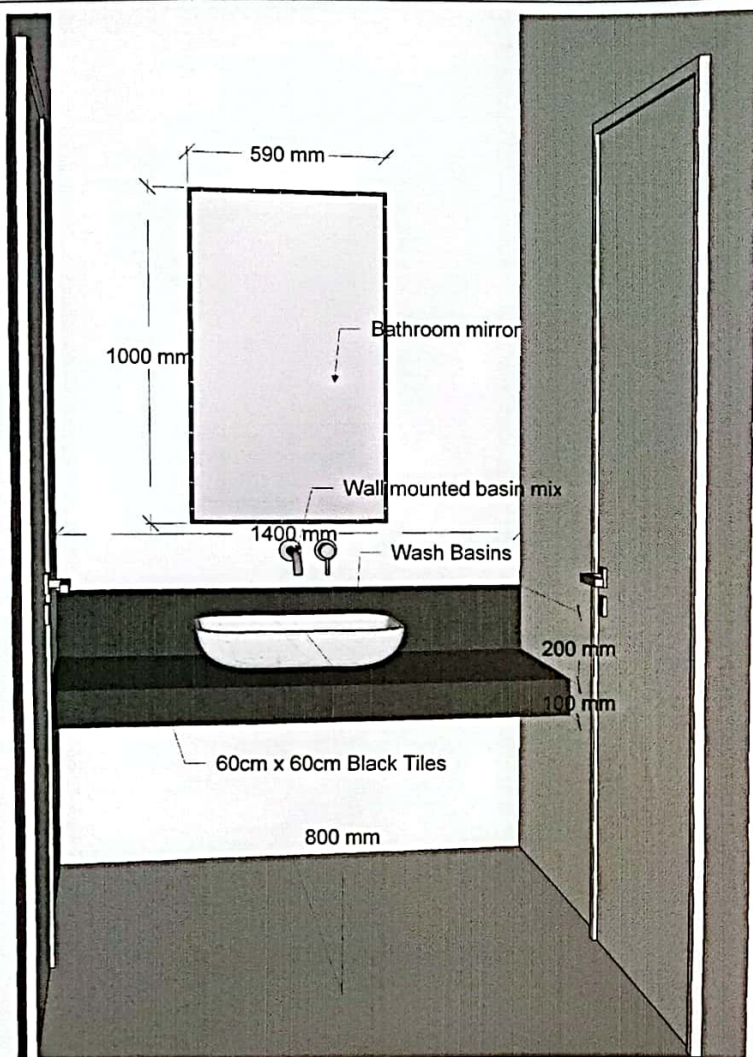

1 A.V.R. WASH AREA (1 SET)
A/36 SCALE:

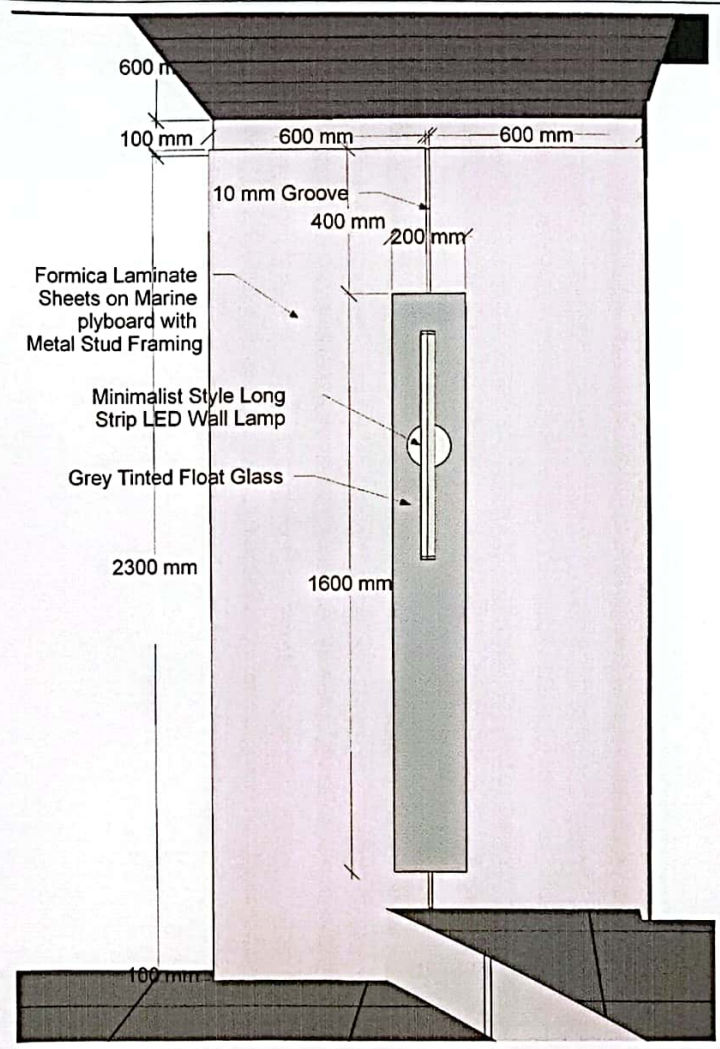

2 A.V.R LED ACCENT WALL (8 SETS)
A/36 SCALE:



REPUBLIC OF THE PHILIPPINES
UNIVERSITY OF SCIENCE & TECHNOLOGY OF SOUTHERN PHILIPPINES
CIVIL AND SANITARY WORKS UNIT
C.M. RECTO AVENUE, LAPASAN 9000 CAGAYAN DE ORO CITY
TEL. NOS. (08822) 72-60-65 / (0882) 836-1734 / 836-1739 TELE
FAX (0882) 836-1430
WEB SITE: WWW.USTP.PH

PREPARED BY:
ENGR. EDGEN LLOYD S. BALABIS
ASSISTANT DIRECTOR, CIVIL
PRC NO.: TIR: LOCATION: C.M. RECTO AVE., LAPASAN HIGHWAY, CAGAYAN DE ORO CITY
PTN NO.: DATE ISSUED: OWNER: UNIVERSITY OF SCIENCE & TECHNOLOGY OF SOUTHERN PHILIPPINES

PROJECT: PROPOSED RENOVATION OF ITB (BLDG. 3) AS THE COLLEGE OF MEDICINE (PHASE 2)
NOTED BY: AN FERDINAND S. DUMALA
DIRECTOR, AUXILIARY PLANNING & SURVEILLANCE


RECOMMENDING APPROVAL: ATTY. JONATHAN S. OCHE
VICE CHANCELLOR FOR FINANCE AND ADMINISTRATION

RECOMMENDING APPROVAL: ATTY. DIANEL O. ALBINA
CANCELLOR, USTP-CDO CAMPUS


APPROVED: DR. AMBRONIO A. CULTURA II
UNIVERSITY PRESIDENT

SHEET TITLE: 1. A.V.R. WASH AREA 2. A.V.R. LED ACCENT WALL
DRAWN BY: B.C.H. DATE: 08-11-22
CAD BY: R.P.E. DATE: 08-11-22

SHEET NO. A/36
44

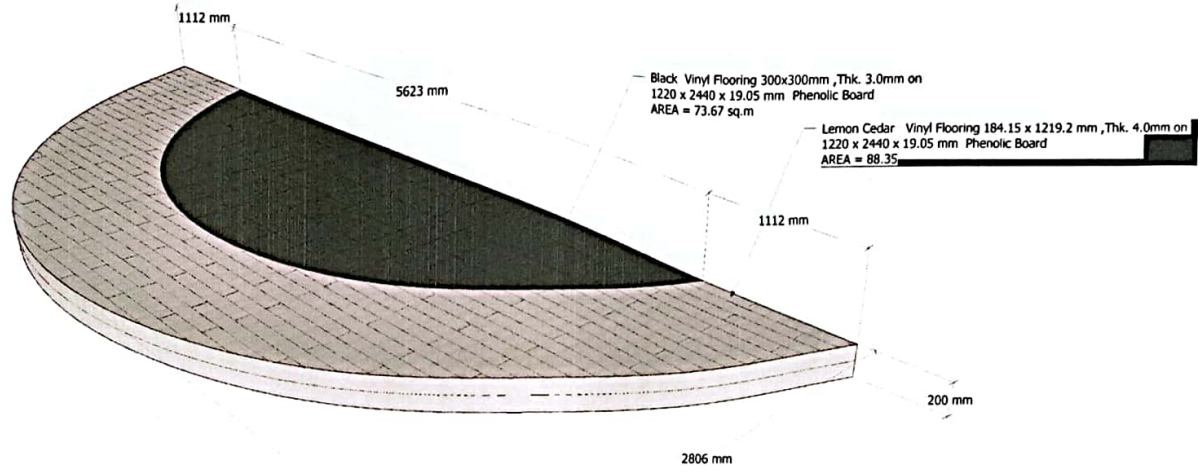


1 A.V.R. PLATFORM DETAIL
SCALE:

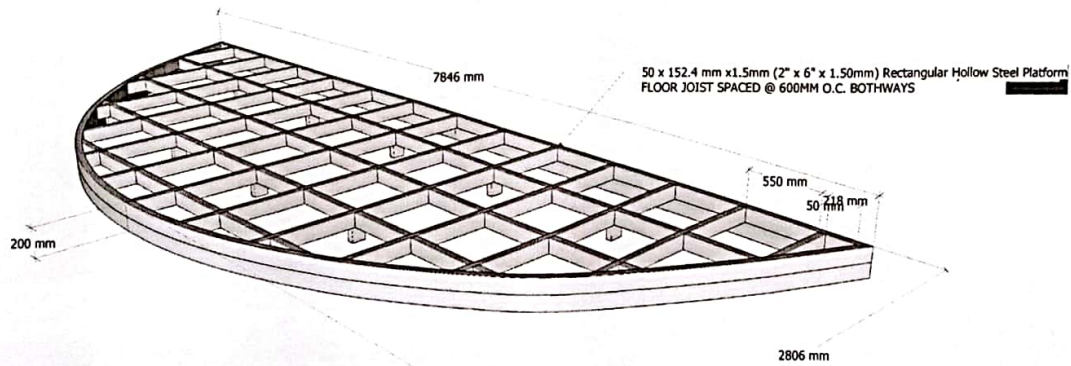


2 A.V.R. PLATFORM FRAMING DETAIL (1 SET)
SCALE:

<p>REPUBLIC OF THE PHILIPPINES UNIVERSITY OF SCIENCE & TECHNOLOGY OF SOUTHERN PHILIPPINES CIVIL AND SANITARY WORKS UNIT</p> <p>C. M. RECTO AVENUE, LAPASAN 9000 CAGAYAN DE ORO CITY TEL. NOS. (0862) 72-60-65 / (086) 856-1758 / 856-1759 TELS FAX (086) 856-6800 WWW SITE: WWW.USTIP.PH</p>	<p>PREPARED BY: <i>[Signature]</i> ENGR. EDGER LLOYD S. BALABIS ASSISTANT DIRECTOR, APS</p>	<p>PROJECT: PROPOSED RENOVATION OF ITB (BLDG. 3) AS THE COLLEGE OF MEDICINE (PHASE 2)</p>	<p>NOTED BY: <i>[Signature]</i> DR. FERDINAND A. DUMAS DIRECTOR, UNIVERSITY HEALTH SERVICES</p>	<p>RECOMMENDING APPROVAL: <i>[Signature]</i> ATTY. JONATHAN S. OCHE VICE CHANCELLOR FOR FINANCE AND ADMINISTRATION</p>	<p>RECOMMENDING APPROVAL: <i>[Signature]</i> ATTY. DIKREL O. ALBINA CHANCELLOR, USTP-CDO CAMPUS</p>	<p>APPROVED: <i>[Signature]</i> DR. AMBRISIO B. CULTURA II UNIVERSITY PRESIDENT</p>	<p>SHEET TITLE: SHEET CONTENTS: 1. A.V.R. PLATFORM DETAIL 2. A.V.R. PLATFORM FRAMING DETAIL</p>	<p>DRAWN BY: G.C.H. DATE: 06-11-22</p>	<p>CAD BY: R.P.E. DATE: 06-11-22</p>	<p>SHEET NO. A 37 44</p>
	<p>PRC NO.:</p>	<p>TIN:</p>	<p>LOCATION: C.M. RECTO AVE., LAPASAN HIGHWAY, CAGAYAN DE ORO CITY</p>	<p>OWNER: UNIVERSITY OF SCIENCE & TECHNOLOGY OF SOUTHERN PHILIPPINES</p>	<p>DATE ISSUED:</p>					

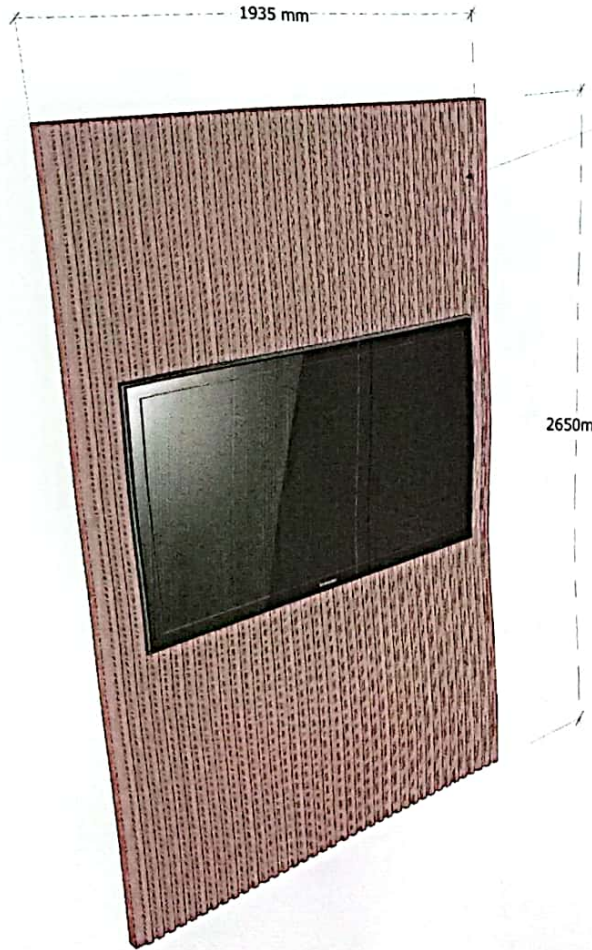

1 DEAN'S TV WALL ACCENT DETAIL
A/38 SCALE:

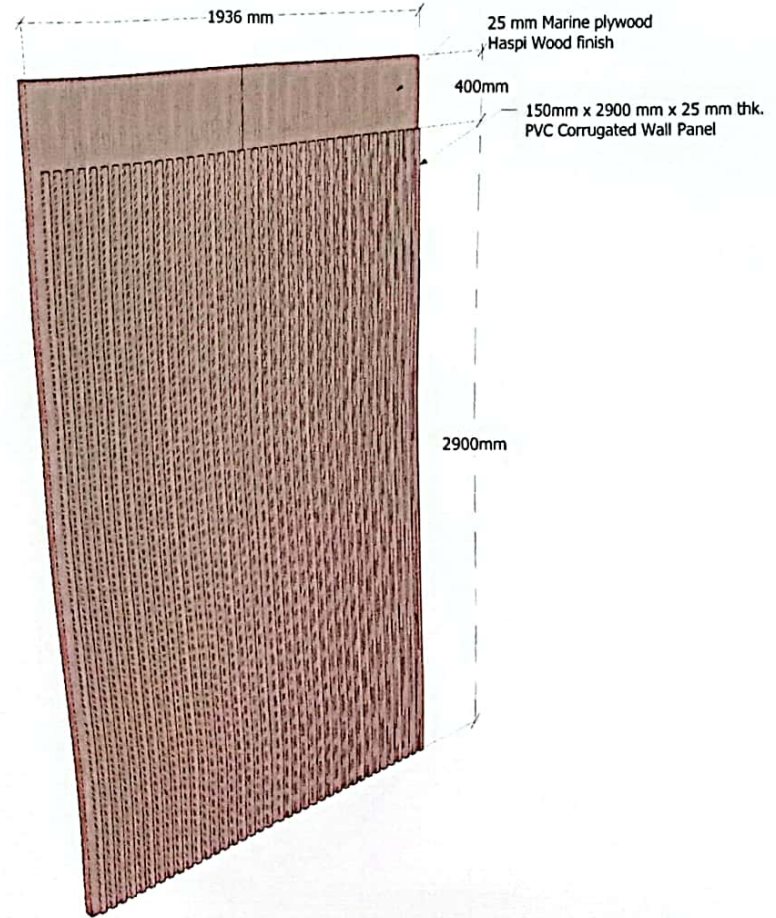

2 A.V.R. ACCENT WALL DETAIL (2 SETS)
A/38 SCALE:



REPUBLIC OF THE PHILIPPINES
UNIVERSITY OF SCIENCE & TECHNOLOGY OF SOUTHERN PHILIPPINES
CIVIL AND SANITARY WORKS UNIT
C. M. Recto Avenue, Lapasan 9000 Cagayan de Oro City
Tel. nos. (08622) 72-66-66 / (0862) 856-1738 / 856-4738 Tels.
Fax (086) 856-4696
Web Site: www.ustp.edu.ph

PREPARED BY:
ENR. EDGEN LLOYD S. BALABIS
ASSISTANT DIRECTOR, AHS
PROJECT NO. / DATE ISSUED

PROJECT:
PROPOSED RENOVATION OF ITB (BLDG. 3) AS THE COLLEGE OF MEDICINE (PHASE 2)
LOCATION: C.M. RECTO AVE., LAPASAN HIGHWAY, CAGAYAN DE ORO CITY
OWNER: UNIVERSITY OF SCIENCE & TECHNOLOGY OF SOUTHERN PHILIPPINES

NOTED BY:
DR. FERDINAND A. DUMPA
DIRECTOR GENERAL, MANAGEMENT SERVICE

RECOMMENDING APPROVAL:
ATTY. JONATHAN S. OCHE
VICE CHANCELLOR FOR FINANCE AND ADMINISTRATION



RECOMMENDING APPROVAL:
ATTY. RICHMEL O. ALBINA
CHANCELLOR, USTP-CDO CAMPUS

APPROVED:
DR. AMBROSIO S. CULTURA II
UNIVERSITY PRESIDENT

SHEET TITLE:
SHEET CONTENTS:
1. DEAN'S TV ACCENT WALL DETAIL
2. A.V.R. ACCENT WALL DETAIL
DRAWN BY: R.P.E.
DATE: 08-02-22

DRAWN BY: R.C.H.
DATE: 08-02-22
SHEET NO. 38
44

5 sets
Small Group Discussion Room

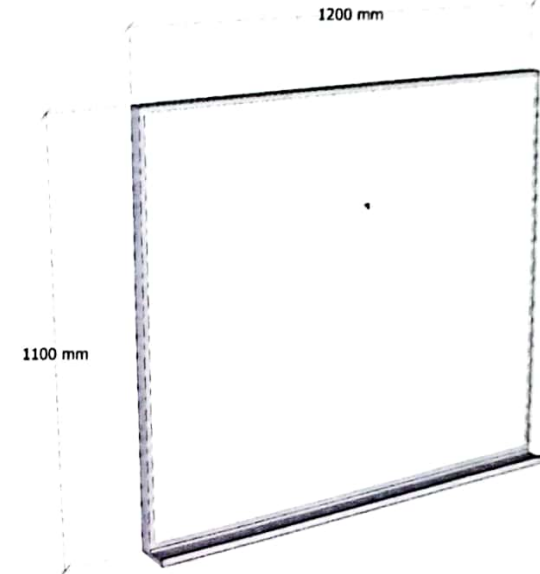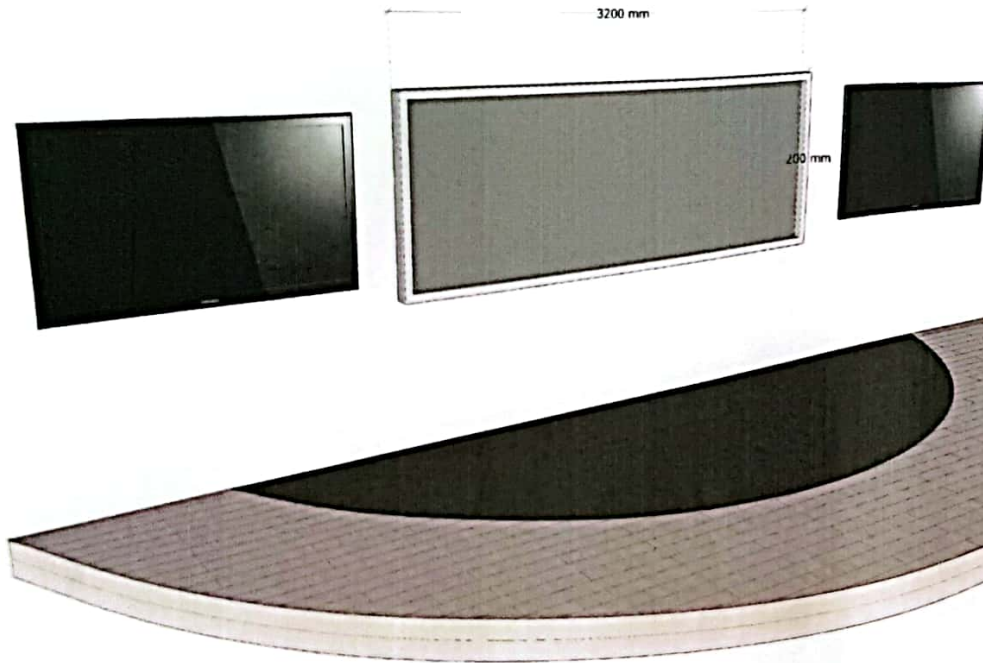

1 A.V.R. WHITEBOARD DETAIL (1 SET)
SCALE

2 S.G. ROOM WHITE BOARD (5 SETS)
SCALE



REPUBLIC OF THE PHILIPPINES
UNIVERSITY OF SCIENCE & TECHNOLOGY OF
SOUTHERN PHILIPPINES
CIVIL AND SANITARY WORKS UNIT
C. M. ROXAS AVENUE, LAGUNA, 4000 CALABANG DE ORTIGUEZ
TEL. AND FAX: (052) 510-1000 / (052) 510-1100 / (052) 510-1101
FAX: (052) 510-1000
WWW.USTP.EDU.PH

DESIGNED BY
[Signature]
ENGR. EDGEN LLOYD S. BALABIS
REGISTERED ARCHITECT

PROJECT
PROPOSED RENOVATION OF ITB
(BLDG. 3) AS THE COLLEGE OF
MEDICINE (PHASE 2)
LOCATION
C.M. ROXAS AVE., LAGUNA HIGHWAY, CALABANG DE ORTIGUEZ
OWNER
UNIVERSITY OF SCIENCE & TECHNOLOGY OF SOUTHERN PHILIPPINES

NOTED BY
[Signature]
AS FERDINANDA DUMPA
DIRECTOR, BLDG. MAINTENANCE
DIVISION

RECOMMENDING APPROVAL
[Signature]
ATTY. JONATHAN S. DOBE
VICE CHANCELLOR FOR FINANCE
AND ADMINISTRATION


RECOMMENDING APPROVAL
[Signature]
ATTY. DIANELO O. ALBINA
CHANCELLOR, USTP-CALABANG
CAMPUS

APPROVED
[Signature]
DR. AMBRADOR CLAYTON II
PRESIDENT


SHEET TITLE
SHEET CONTENTS
1. A.V.R. WHITEBOARD
DETAIL

DRAWN BY: S.C.H.
DATE: 08-10-22
CAD BY: R.P.E.
DATE: 08-10-22

SHEET NO.
A
39
39
44

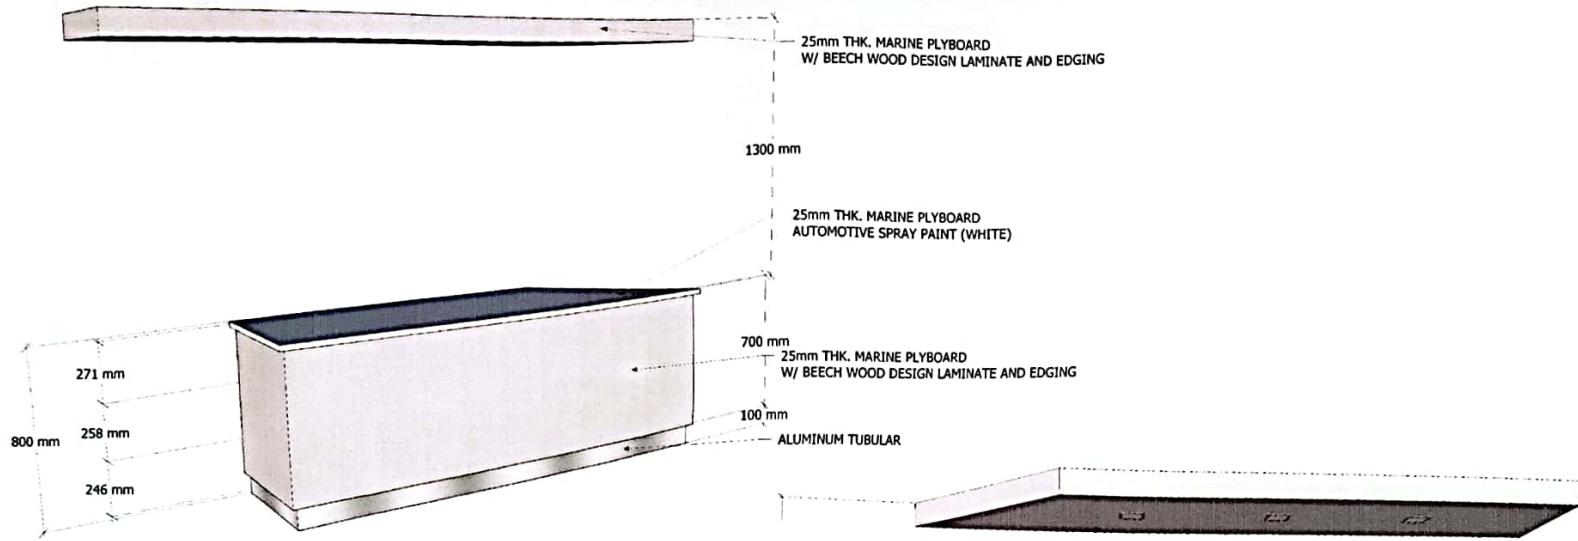


1 A.V.R. COUNTER DETAIL 1 (1 SET)
 A 41 SCALE:

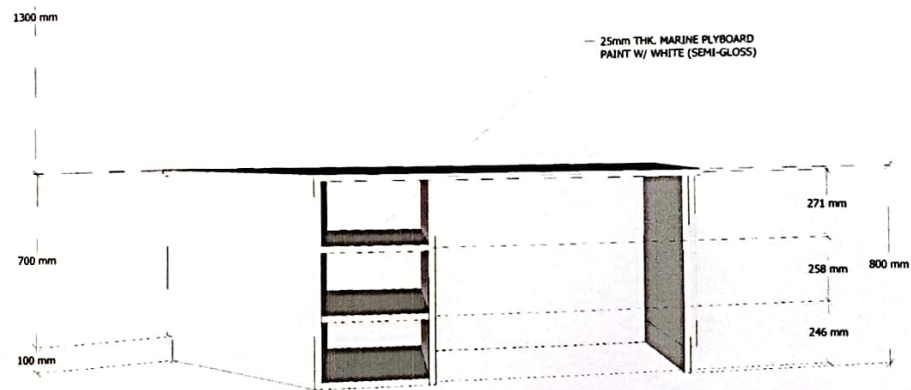


2 A.V.R. COUNTER DETAIL 2 (1 SET)
 A 41 SCALE:

<p>REPUBLIC OF THE PHILIPPINES UNIVERSITY OF SCIENCE & TECHNOLOGY OF SOUTHERN PHILIPPINES CIVIL AND SANITARY WORKS UNIT</p> <p>C.M. RECTO AVENUE, LAPASAN 9000 CAGAYAN DE ORO CITY TEL. NOS. (08622) 72-00-00 / (086) 866-1726 / 866-1739 TELE FAX (086) 866-6630 WEB SITE WWW.USTP.EDU.PH</p>	PREPARED BY: ENGR. EDEGM LLOYD S. BALANIS <small>ASST. DIR. DIRECTOR, SWU</small>	PROJECT: PROPOSED RENOVATION OF ITB (BLDG. 3) AS THE COLLEGE OF MEDICINE (PHASE 2)	NOTED BY: DR. FERDINAND A. DUMPA <small>DIRECTOR, ALUMNUS MANAGEMENT</small>	RECOMMENDING APPROVAL: ATTY. JONATHAN S. OCHE <small>VICE CHANCELLOR FOR FINANCE AND ADMINISTRATION</small>	RECOMMENDING APPROVAL: ATTY. DIONEL O. ALBINA <small>CHANCELLOR, USTP-CAO CAMPUS</small>	APPROVED: DR. AMBRACIO S. CULTRERA II <small>UNIVERSITY PRESIDENT</small>	SHEET TITLE: SHEET CONTENTS: 1. A.V.R. COUNTER DETAIL	DRAWN BY: G.C.H. DATE: 06-02-22 CAD BY: R.P.E. DATE: 06-02-22	SHEET NO. A 41 44
	PRC NO. TRN PTR NO.	DATE ISSUED	LOCATION: C.M. RECTO AVE., LAPASAN HIGHWAY, CAGAYAN DE ORO CITY	OWNER: UNIVERSITY OF SCIENCE & TECHNOLOGY OF SOUTHERN PHILIPPINES					

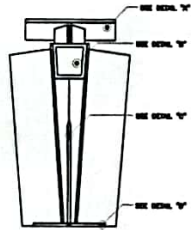


1 FRONT ELEVATION
SCALE: 1:400

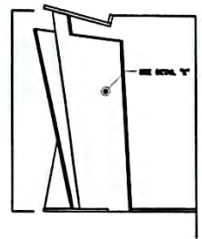


2 LEFT-SIDE ELEVATION
SCALE: 1:400




3 RIGHT-SIDE ELEVATION
SCALE: 1:400

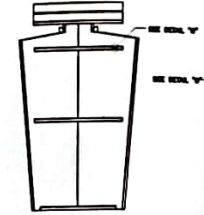


4 REAR ELEVATION
SCALE: 1:400

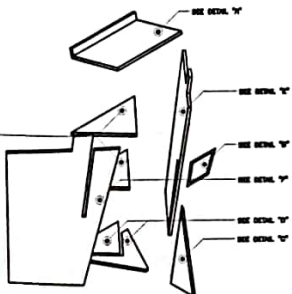


5 ISOMETRIC VIEW
SCALE: 1:400

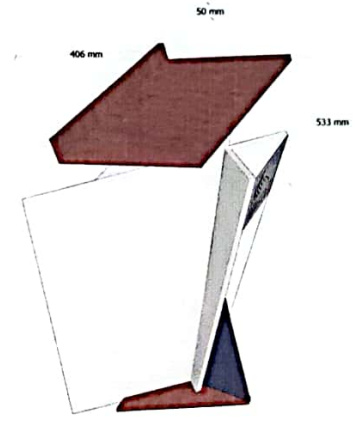


13 PODIUM DETAIL 2 (1 SET)
SCALE:

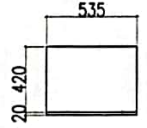


6 DETAIL "A"
SCALE: 1:400

 


7 DETAIL "B"
SCALE: 1:400

 


8 DETAIL "C"
SCALE: 1:400

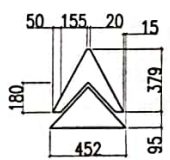

9 DETAIL "D"
SCALE: 1:400

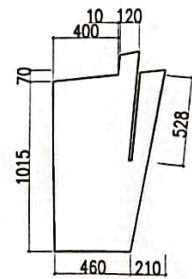


10 DETAIL "E"
SCALE: 1:400

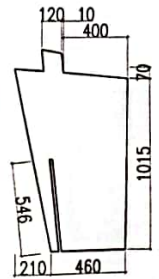

11 DETAIL "F"
SCALE: 1:400



12 DETAIL "G"
SCALE: 1:400

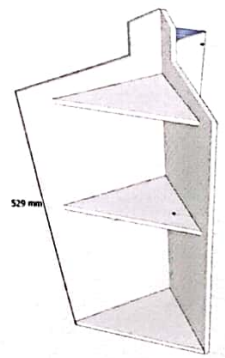

14 PODIUM DETAIL 4 (1 SET)
SCALE:



REPUBLIC OF THE PHILIPPINES
UNIVERSITY OF SCIENCE & TECHNOLOGY OF SOUTHERN PHILIPPINES
CIVIL AND SANITARY WORKS UNIT
C. H. RECTO AVENUE, LAPASAN 9000 CAGAYAN DE ORO CITY
TEL. NO. (08822) 72-00-05 / (088) 806-1736 / 856-1739 TOLL
FAX (088) 856-1696
WWW.USTP.EDU.PH

PREPARED BY:
ENGR. EUGEN LLOYD S. BALABIS
ASSISTANT DIRECTOR, APS

PROJECT:
PROPOSED RENOVATION OF ITB (BLDG. 3) AS THE COLLEGE OF MEDICINE (PHASE 2)
LOCATION: C.H. RECTO AVE., LAPASAN HIGHWAY, CAGAYAN DE ORO CITY
OWNER: UNIVERSITY OF SCIENCE & TECHNOLOGY OF SOUTHERN PHILIPPINES

NOTED BY:
ATY. FERNANDO A. DUMPA
DIRECTOR, ADMINISTRATION SERVICES

RECOMMENDING APPROVAL:
ATTY. JONATHAN S. OCHE
VICE CHANCELLOR FOR FINANCE AND ADMINISTRATION


RECOMMENDING APPROVAL:
ATTY. DONEL O. ALBINA
CHANCELLOR, USTP-CDO CAMPUS

APPROVED:
DR. AMBROSIO S. CULTURA II
UNIVERSITY PRESIDENT


SHEET TITLE:
SHEET CONTENTS:
1. PODIUM DETAIL

DRAWN BY: G.C.H.
DATE: 08-0-02
CAD BY: R.P.P.
DATE: 08-0-02

SHEET NO.:
A
42
44

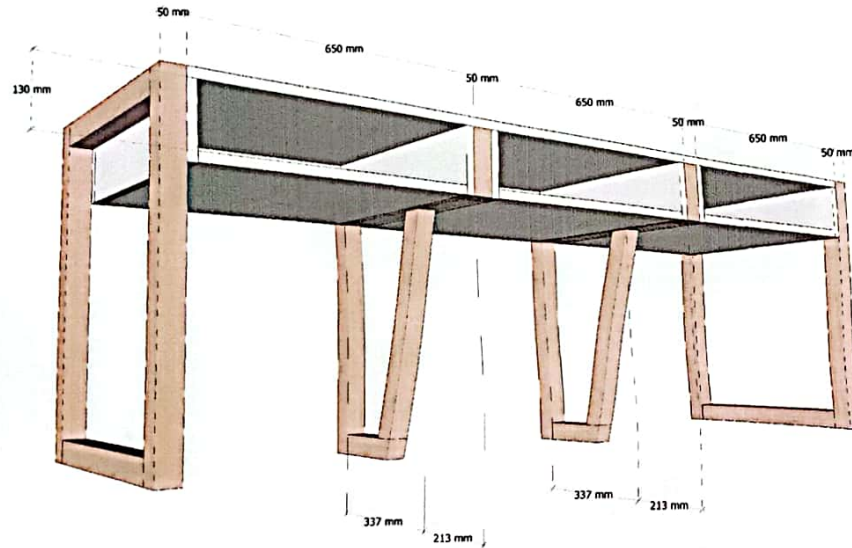

1 CLASSROOM 2 TABLE DETAIL 1
SCALE:

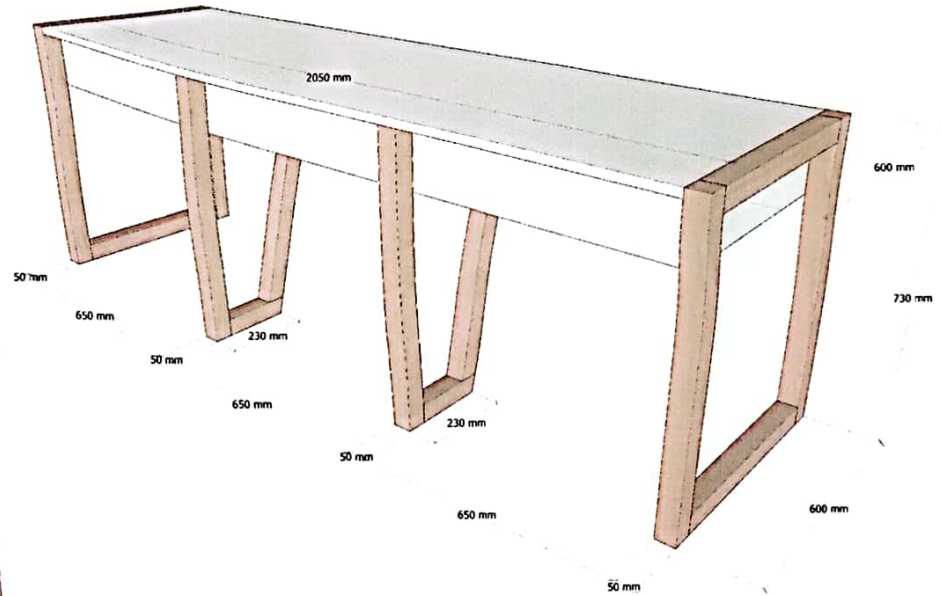

2 CLASSROOM 2 TABLE DETAIL 2
SCALE:



REPUBLIC OF THE PHILIPPINES
UNIVERSITY OF SCIENCE & TECHNOLOGY OF
SOUTHERN PHILIPPINES
CIVIL AND SANITARY WORKS UNIT

C. H. RECTO AVENUE, LAPASAN 9000 CAGAYAN DE ORO CITY
TEL. NOS. (0862) 72-66-65 / (0862) 866-1736 / 866-1739 TOLL
FAX (0862) 858-1076
WWW.USTP.EDU.PH

PREPARED BY:
[Signature]
ENGR. EDGER LLOYD S. BALABIS
ASSISTANT DIRECTOR, AVE

PROJECT:
PROPOSED RENOVATION OF ITB
(BLDG. 3) AS THE COLLEGE OF
MEDICINE (PHASE 2)

LOCATION: C. H. RECTO AVE., LAPASAN HIGHWAY, CAGAYAN DE ORO CITY
OWNER: UNIVERSITY OF SCIENCE & TECHNOLOGY OF SOUTHERN PHILIPPINES

NOTED BY:
[Signature]
DR. FERDINANDIA BUMPA
DIRECTOR, QUALITY MANAGEMENT
OFFICE

RECOMMENDING APPROVAL:
[Signature]
ATTY. JONATHAN S. OCHE
VICE CHANCELLOR FOR FINANCE
AND ADMINISTRATION


RECOMMENDING APPROVAL:
[Signature]
ATTY. DIONEL O. ALBINA
CHANCELLOR, USTP-CDO CAMPUS

APPROVED:
[Signature]
DR. AMBRASIO B. CULTURA II
UNIVERSITY PRESIDENT


SHEET TITLE
SHEET CONTENTS:
1. CLASSROOM 2 TABLE
DETAIL

DRAWN BY: S.C.H.
DATE: 08-10-22
CAD BY: R.P.E.
DATE: 08-10-22


SHEET NO.
A
43
44

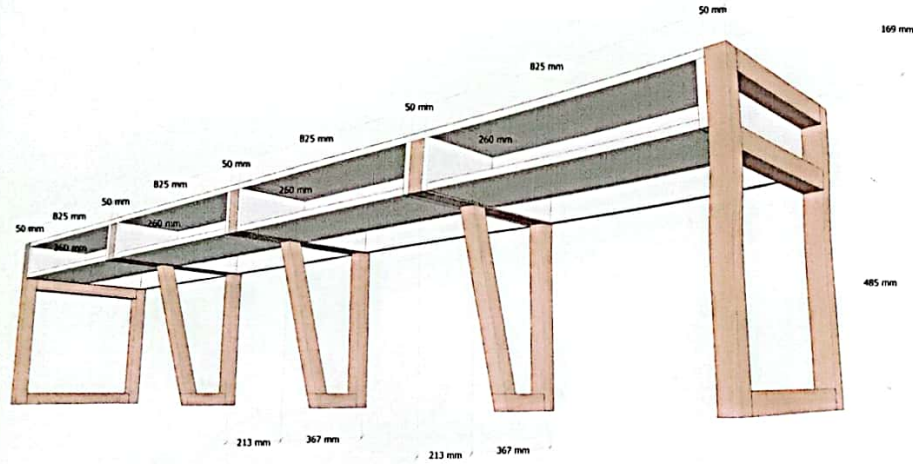

1 CLASSROOM TABLE 1 DETAIL 1 (14 SETS)
SCALE: A/44

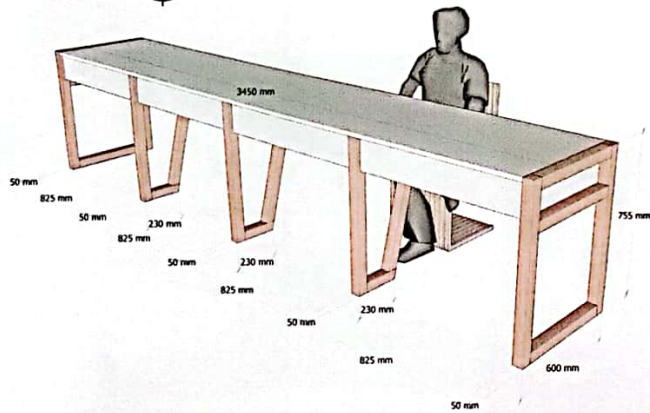

2 CLASSROOM TABLE 1 DETAIL 2 (14 SETS)
SCALE: A/44

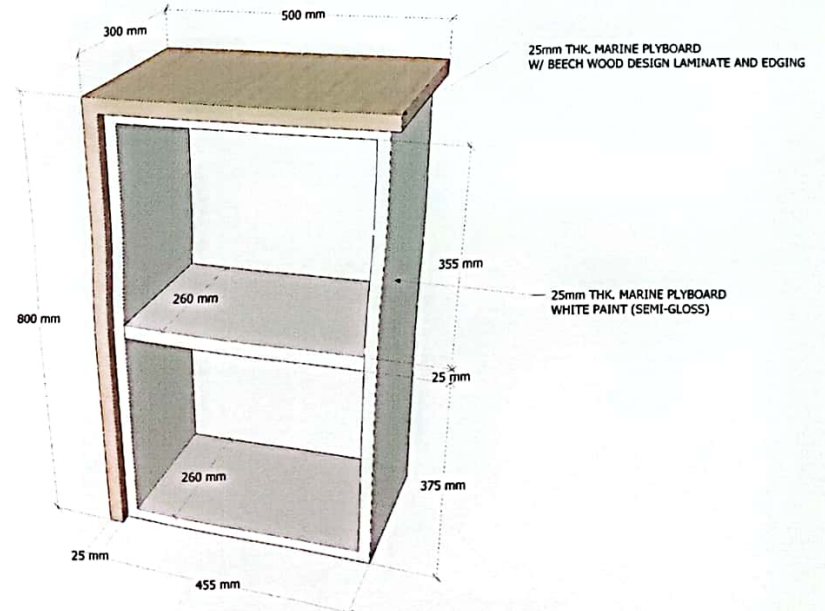

3 SIDE TABLE DETAIL (40 SETS)
SCALE: A/44



REPUBLIC OF THE PHILIPPINES
UNIVERSITY OF SCIENCE & TECHNOLOGY OF SOUTHERN PHILIPPINES
CIVIL AND SANITARY WORKS UNIT
C.M. RECTO AVENUE, LAPASAN 9000 CAGAYAN DE ORO CITY
TEL. NO. (0862) 72-60-63 / (0862) 858-1730 / 856-1739 TOLL
FAX NO. 0862-856-0290
WEB SITE: WWW.USTP.UMU.PH

PREPARED BY:
[Signature]
ENGR. EDGER LLOYD S. BALABIS
ASSISTANT DIRECTOR, AHS
PRC NO.: ITN
PTR NO.:
DATE ISSUED:

PROJECT:
PROPOSED RENOVATION OF ITB (BLDG. 3) AS THE COLLEGE OF MEDICINE (PHASE 2)
LOCATION: C.M. RECTO AVE., LAPASAN HIGHWAY, CAGAYAN DE ORO CITY
OWNER: UNIVERSITY OF SCIENCE & TECHNOLOGY OF SOUTHERN PHILIPPINES

NOTED BY:
[Signature]
DR. FERDINAND L. DUMAPA
DIRECTOR, ALUMNI DEVELOPMENT SERVICES


RECOMMENDING APPROVAL:
[Signature]
ATTY. JONATHAN S. OCHE
VICE CHANCELLOR FOR FINANCE AND ADMINISTRATION

RECOMMENDING APPROVAL:
[Signature]
ATTY. DIANEL O. ALBINA
CHANCELLOR, USTP-CDO CAMPUS

APPROVED:
[Signature]
DR. AMBROSIO B. CULTURA II
UNIVERSITY PRESIDENT

SHEET TITLE:
1. CLASSROOM TABLE 1 DETAIL
DRAWN BY: E.C.H.
DATE: 06-08-22
CAD BY: R.P.E.
DATE: 06-08-22

SHEET NO.
A
44
44

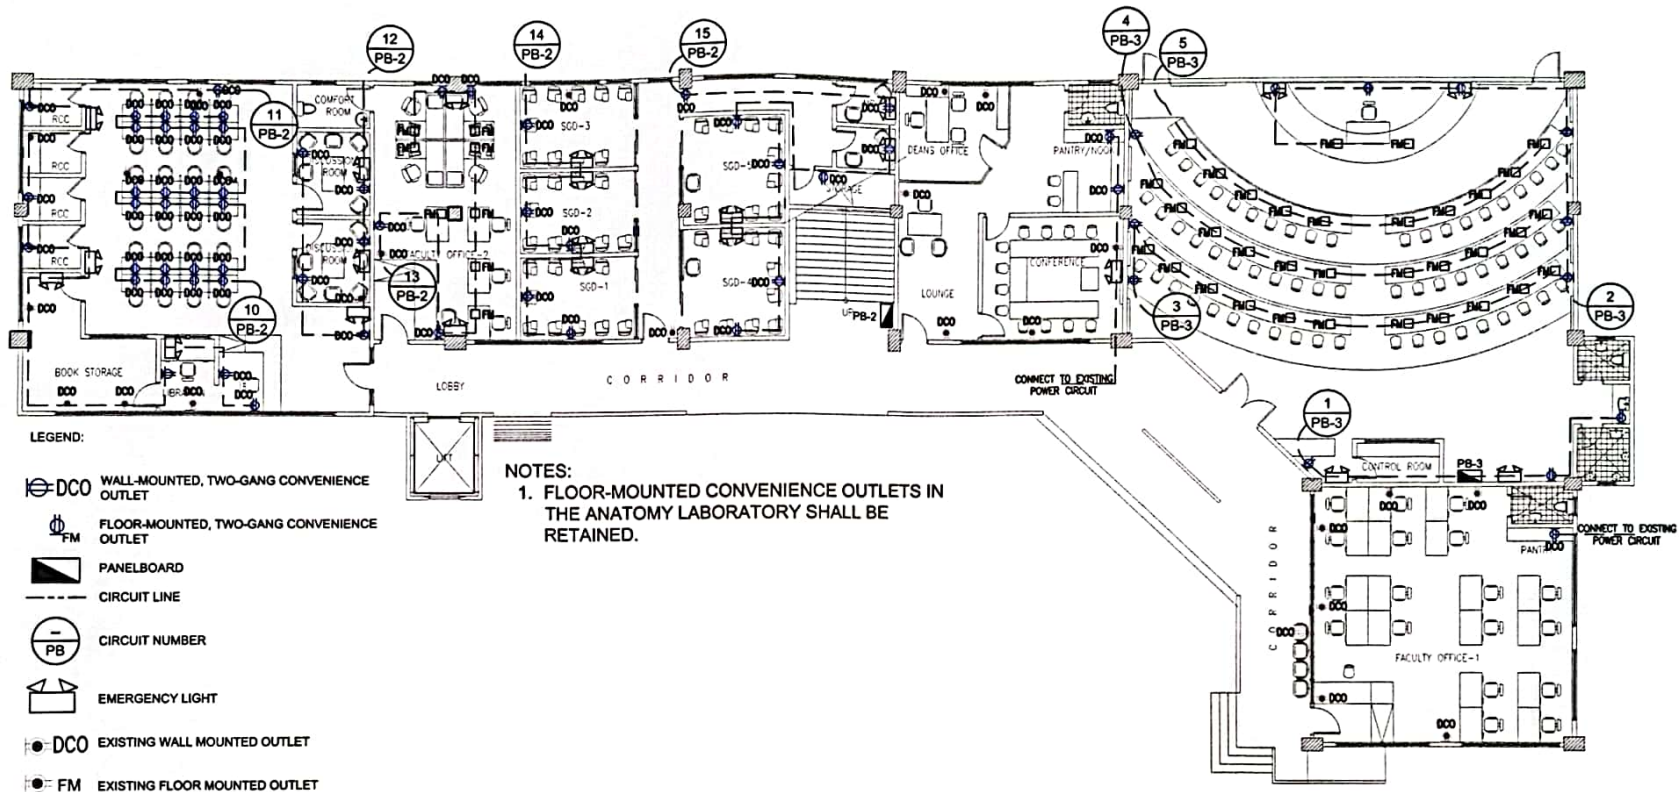

LEGEND:

- DCO WALL-MOUNTED, TWO-GANG CONVENIENCE OUTLET
- FM FLOOR-MOUNTED, TWO-GANG CONVENIENCE OUTLET
- PANELBOARD
- CIRCUIT LINE
- CIRCUIT NUMBER
- EMERGENCY LIGHT
- DCO EXISTING WALL MOUNTED OUTLET
- FM EXISTING FLOOR MOUNTED OUTLET

NOTES:
 1. FLOOR-MOUNTED CONVENIENCE OUTLETS IN THE ANATOMY LABORATORY SHALL BE RETAINED.

1
E 1 **GROUND FLOOR POWER LAYOUT**
 SCALE: 1:175M



REPUBLIC OF THE PHILIPPINES
 UNIVERSITY OF SCIENCE & TECHNOLOGY OF SOUTHERN PHILIPPINES
 CIVIL AND SANITARY WORKS UNIT
 C-16 RECTO AVENUE, LAPASAN 9000 CAGAYAN DE ORO CITY
 TEL. Nos. (08822) 72-00-05 / (088) 856-1756 / 856-1759 TDD
 FAX (088) 856-6400
 WEB SITE: www.ustp.edu.ph

PREPARED BY:

 ENGR. EDGARDO LLOYD S. BALABIS
 ASSISTANT DIRECTOR, UWS

PROJECT:
PROPOSED RENOVATION OF ITB (BLDG. 3) AS THE COLLEGE OF MEDICINE (PHASE 2)
 LOCATION: C.H. RECTO AVE., LAPASAN HIGHWAY, CAGAYAN DE ORO CITY
 OWNER: UNIVERSITY OF SCIENCE & TECHNOLOGY OF SOUTHERN PHILIPPINES

NOTED BY:

 AR. FERRNANDO ALUMBA
 DIRECTOR, LIBRARY MANAGEMENT SERVICE

RECOMMENDING APPROVAL:

 ATTY. JONATHAN S. OCHE
 VICE CHANCELLOR FOR FINANCE AND ADMINISTRATION

RECOMMENDING APPROVAL:


 ATTY. DIGNEL O. ALBINA
 CHANCELLOR, USTP-CDO CAMPUS

APPROVED:

 DR. AMADOR B. CULTURA II
 UNIVERSITY PRESIDENT

SHEET TITLE:
1. GROUND FLOOR POWER LAYOUT
 DRAWN BY: S.C.H.
 DATE: 08-08-22
 CAD BY: R.P.E.
 DATE: 08-08-22

SHEET NO.
E 1
1
6

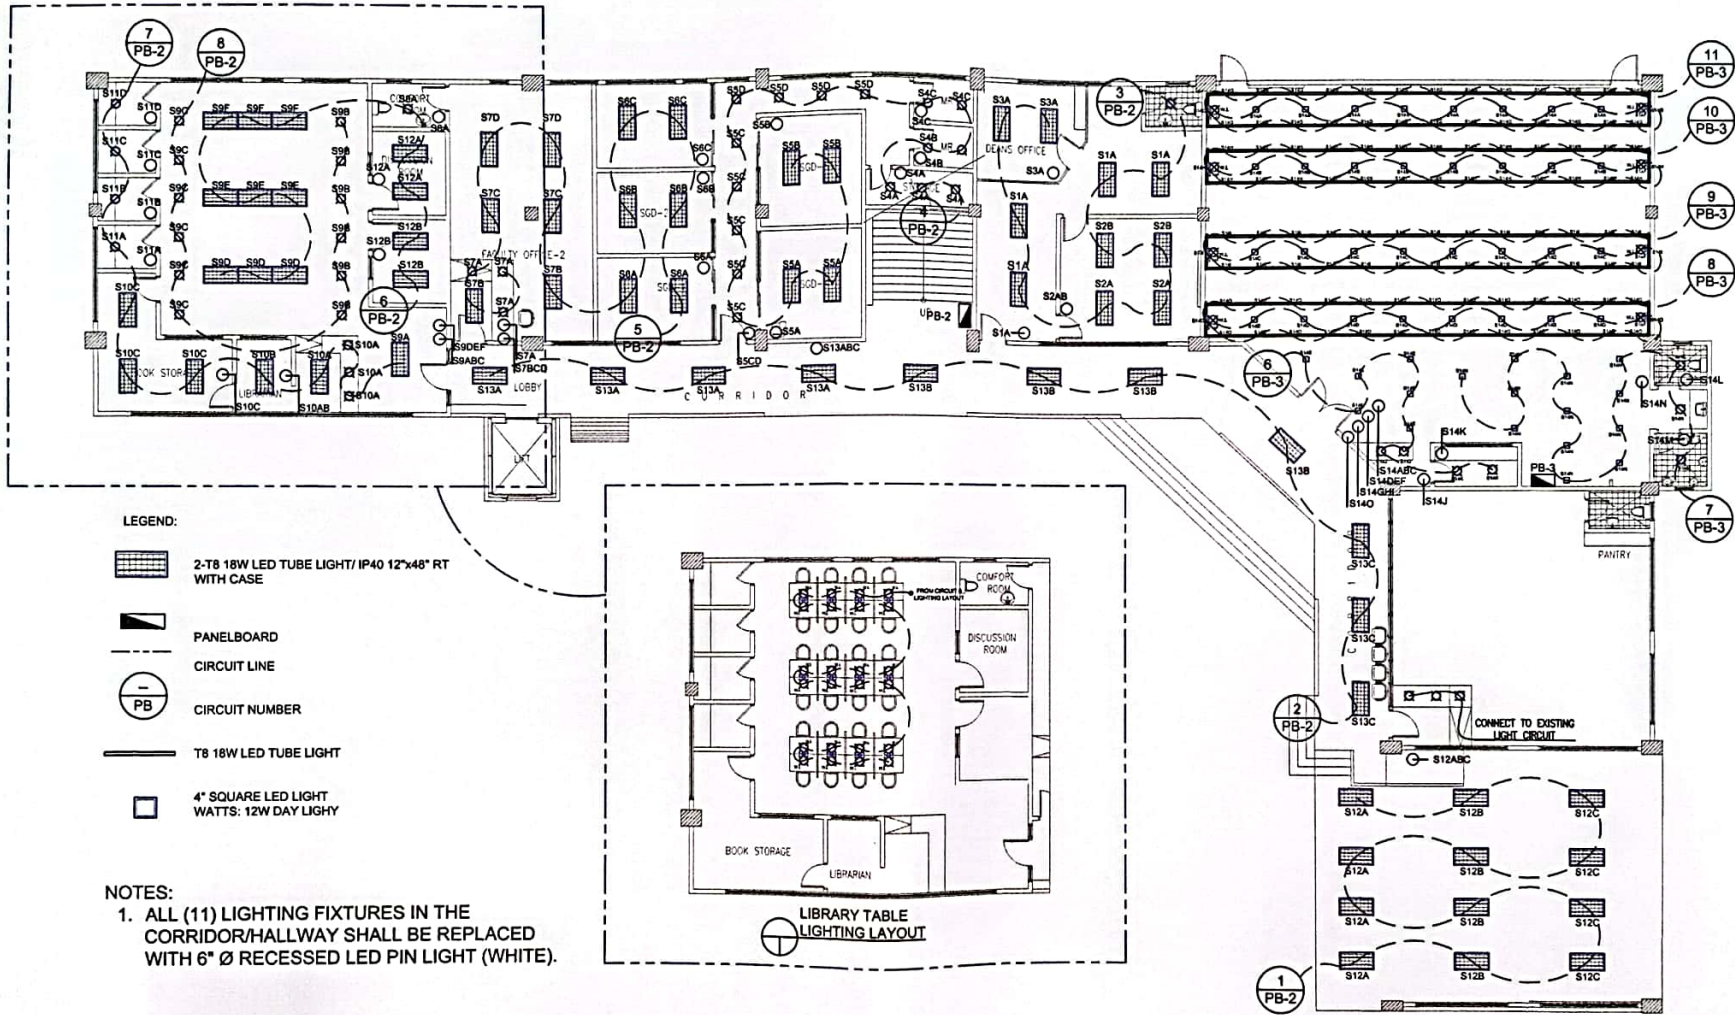

LEGEND:

- 2-T8 18W LED TUBE LIGHT/ IP40 12"x48" RT WITH CASE
- PANELBOARD
- CIRCUIT LINE
- CIRCUIT NUMBER
- T8 18W LED TUBE LIGHT
- 4" SQUARE LED LIGHT WATTS: 12W DAY LIGHT

NOTES:

1. ALL (11) LIGHTING FIXTURES IN THE CORRIDOR/HALLWAY SHALL BE REPLACED WITH 6" Ø RECESSED LED PIN LIGHT (WHITE).

1
E 2 **GROUND FLOOR LIGHTING LAYOUT**
SCALE: 1:175M



REPUBLIC OF THE PHILIPPINES
UNIVERSITY OF SCIENCE & TECHNOLOGY OF SOUTHERN PHILIPPINES
CIVIL AND SANITARY WORKS UNIT
C.M. RECTO AVENUE, LAPASAN 9000 CAGAYAN DE ORO CITY
TEL. NO. (08822) 72-00-05 / (088) 856-4738 / 856-4739 TELE
FAX (088) 856-4676
WEB SITE : WWW.USTIP.USDJ.PH

PREPARED BY:
[Signature]
ENGR. EDGAR M. LLOYD S. BALABIS
ASSISTANT DIRECTOR, UWS

PROJECT:
PROPOSED RENOVATION OF ITB (BLDG. 3) AS THE COLLEGE OF MEDICINE (PHASE 2)

LOCATION:
C.M. RECTO AVE., LAPASAN HIGHWAY, CAGAYAN DE ORO CITY

OWNER:
UNIVERSITY OF SCIENCE & TECHNOLOGY OF SOUTHERN PHILIPPINES

NOTED BY:
[Signature]
DR. FERDINANDA DUMPA
DIRECTOR, ASSET MANAGEMENT SERVICES

RECOMMENDING APPROVAL:
[Signature]
ATTY. JONATHAN S. OCHE
VICE CHANCELLOR FOR FINANCE AND ADMINISTRATION

RECOMMENDING APPROVAL:
[Signature]
ATTY. DIONEL O. ALBINA
CHANCELLOR, USTP-CDO CAMPUS


APPROVED:
[Signature]
DR. AMBROSE B. CULTURA II
UNIVERSITY PRESIDENT

 



SHEET TITLE:
1. GROUND FLOOR LIGHTING LAYOUT

DRAWN BY: S.C.H.
DATE: 06-02-22

CAD BY: R.P.E.
DATE: 06-02-22

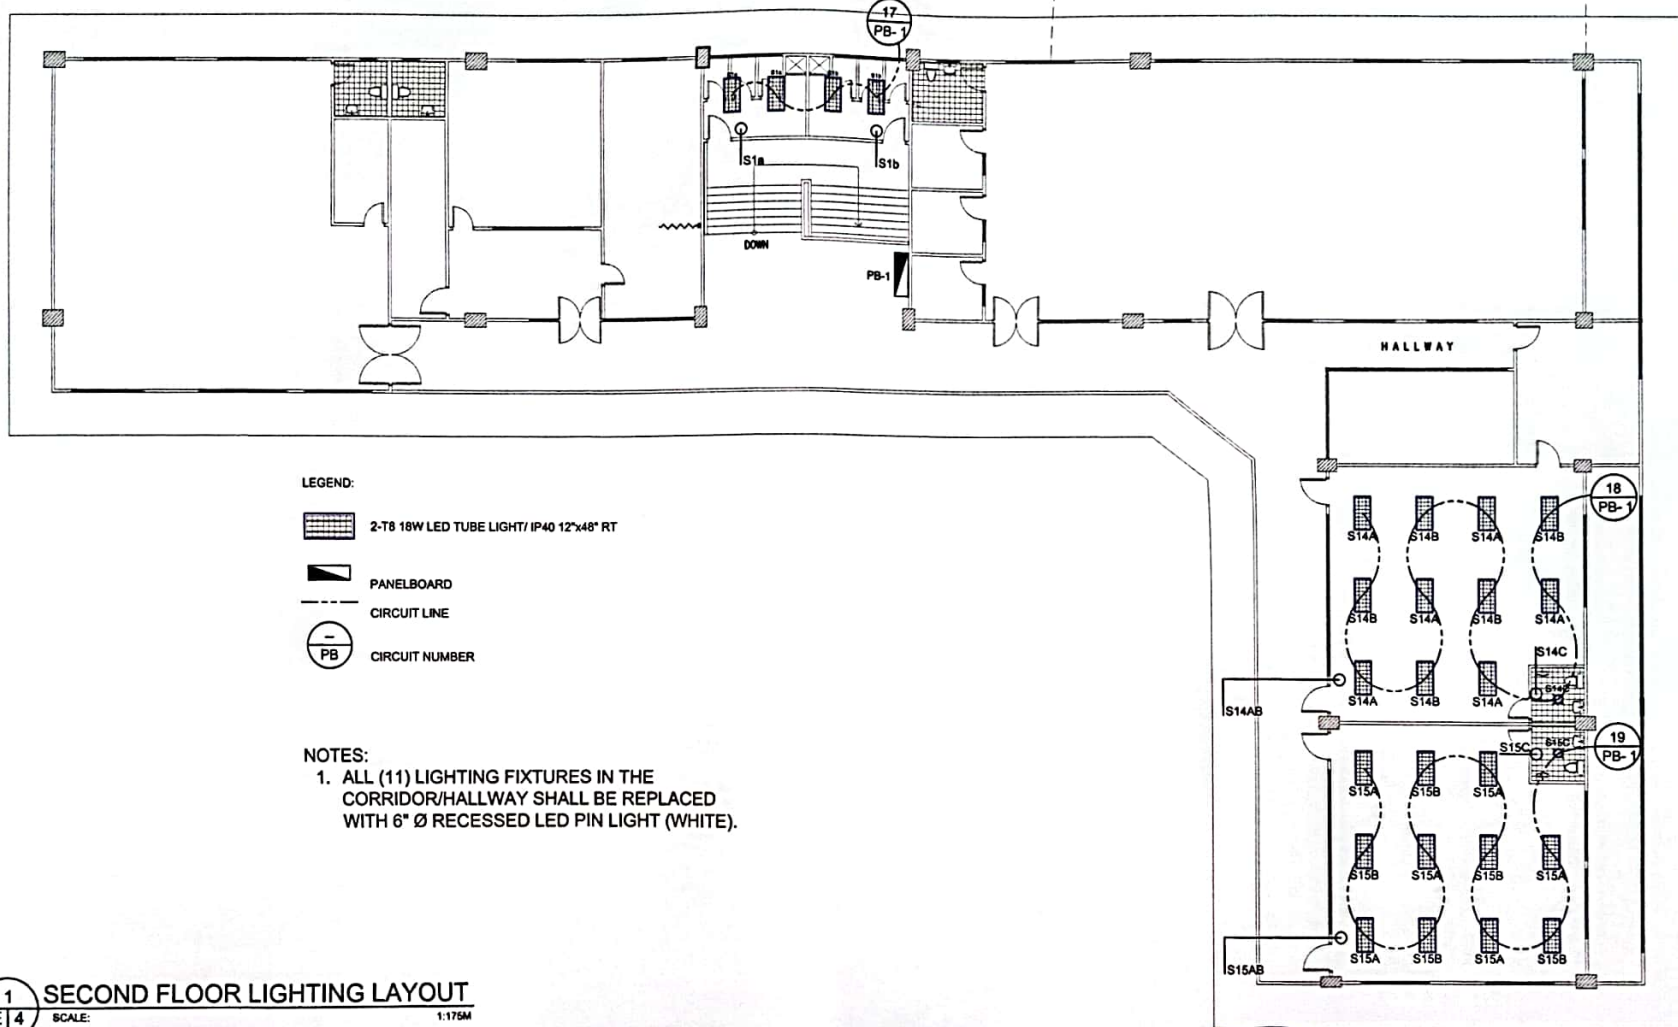
 

 


SHEET NO.	E
	2
	6



- LEGEND:
-  2-T8 18W LED TUBE LIGHT/ IP40 12"x48" RT
 -  PANELBOARD
 -  CIRCUIT LINE
 -  CIRCUIT NUMBER

NOTES:
 1. ALL (11) LIGHTING FIXTURES IN THE CORRIDOR/HALLWAY SHALL BE REPLACED WITH 6" Ø RECESSED LED PIN LIGHT (WHITE).

1
E 4 SECOND FLOOR LIGHTING LAYOUT
 SCALE: 1:175M

 <p>REPUBLIC OF THE PHILIPPINES UNIVERSITY OF SCIENCE & TECHNOLOGY OF SOUTHERN PHILIPPINES CIVIL AND SANITARY WORKS UNIT</p> <p>C. M. RECTO AVENUE, LAPASAN 9000 CAGAYAN DE ORO CITY TEL. NOS. (886)222 72-00-05 / (088) 854-1756 / 856-1759 TELE FAX (088) 854-14950 WEB SITE: WWW.USTP.EDU.PH</p>	PREPARED BY:  ENGR. EDGEMA L. BALABIS ASST. DIR. DIRECTOR, A/E	PROJECT: PROPOSED RENOVATION OF ITB (BLDG. 3) AS THE COLLEGE OF MEDICINE (PHASE 2)	NOTED BY:  DR. FERDINAND A. DIMPAY DIRECTOR, ADMINISTRATION & MANAGEMENT SERVICES	RECOMMENDING APPROVAL:  ATTY. JONATHAN S. OCBE VICE CHANCELLOR FOR FINANCE AND ADMINISTRATION	RECOMMENDING APPROVAL:  ATTY. DIONEL O. ALBINA CHANCELLOR, USTP-CDO CAMPUS	APPROVED:  DR. AMBROSIO S. ALATURA II UNIVERSITY PRESIDENT	SHEET TITLE: 1. SECOND FLOOR LIGHTING LAYOUT	DRAWN BY: E. C. H. DATE: 08-08-22 CAD BY: R.P.E. DATE: 08-08-22	SHEET NO. E 4 4 6
	PREPARED BY: ENGR. EDGEMA L. BALABIS ASST. DIR. DIRECTOR, A/E	PROJECT: PROPOSED RENOVATION OF ITB (BLDG. 3) AS THE COLLEGE OF MEDICINE (PHASE 2)	NOTED BY: DR. FERDINAND A. DIMPAY DIRECTOR, ADMINISTRATION & MANAGEMENT SERVICES	RECOMMENDING APPROVAL: ATTY. JONATHAN S. OCBE VICE CHANCELLOR FOR FINANCE AND ADMINISTRATION	RECOMMENDING APPROVAL: ATTY. DIONEL O. ALBINA CHANCELLOR, USTP-CDO CAMPUS	APPROVED: DR. AMBROSIO S. ALATURA II UNIVERSITY PRESIDENT	SHEET TITLE: 1. SECOND FLOOR LIGHTING LAYOUT	DRAWN BY: E. C. H. DATE: 08-08-22 CAD BY: R.P.E. DATE: 08-08-22	SHEET NO. E 4 4 6

SPECIFICATIONS:

A. CODE AND REGULATIONS:
 THE ELECTRICAL WORK SHALL BE DONE IN ACCORDANCE WITH ALL THE REQUIREMENTS OF THE LATEST ISSUE OF THE PHILIPPINE ELECTRICAL CODE, WITH RULES AND REGULATIONS AND ORDINANCES OF THE LOCAL ENFORCING AUTHORITIES AND REQUIREMENTS OF THE LOCAL COMPANY.

1. SCOPE OF WORK:

1-1. THE WORK CONSIST OF FURNISHING OF ALL MATERIALS AND LABOR, TOOLS AND EQUIPMENT AND ALL NECESSARY.

1-2. SERVICES TO COMPLETE THE ELECTRICAL WORK READY FOR OPERATION AS SHOWN IN THE DRAWING AND SPECIFIED AS FOLLOWS.



1-3. SUPPLY AND INSTALLATION OF ELECTRICAL PANEL BOARDS, GUTTERS, PULLBOX AND ACCESSORIES BOX AS REQUIRED.

1-4. SUPPLY OF WIRING DEVICE PORCELAIN RECEPTACLES, OUTLETS, SWITCHES, ETC. COMPLETE WITH SUITABLE COVER PLATES AS PER SPECIFICATIONS.

1-5. SUPPLY AND INSTALLATION OF ALL OWNERS FURNISHED MATERIALS SUCH AS LIGHTING FIXTURES AND ELECTRICAL CONTROL.

1-6. SUPPLY OF INSTALLATION FOR ALL BRANCH FEEDERS CIRCUITS FROM PANEL BOARD UP TO ALL OUTLETS, SWITCHES CONTROL OR OTHER LOADS; OTHER WIRING AS SHOWN IN PLAN.


1-7. GROUNDING SYSTEM AS PER IEC REQUIREMENTS.

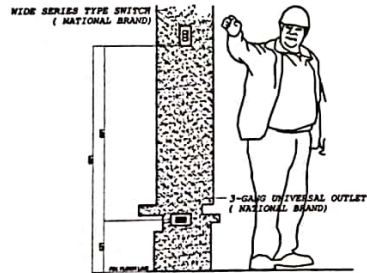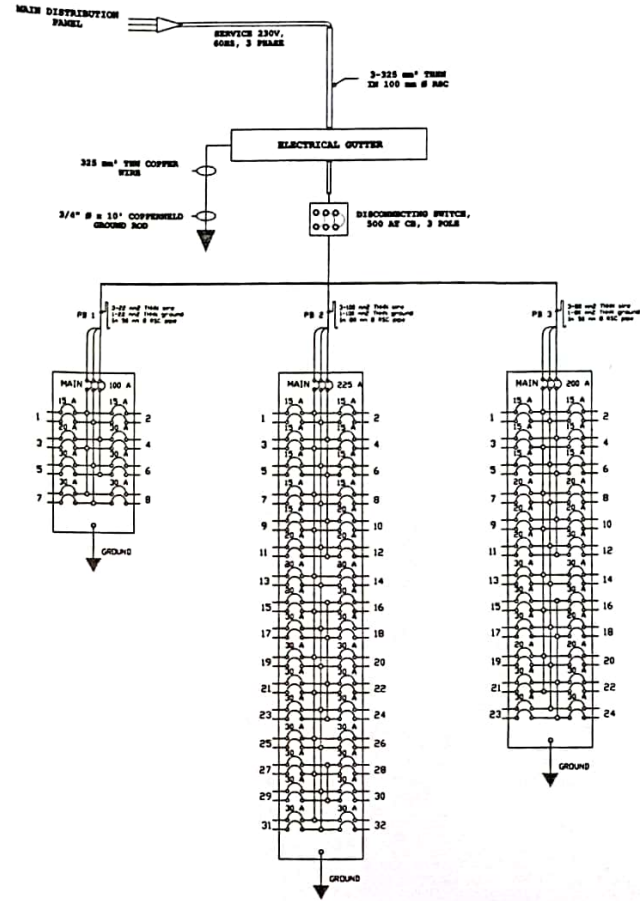

CONVENIENCE & SWITCH OUTLET
 SCALE: NTS

RISER DIAGRAM / SINGLE LINE DIAGRAM
 SCALE: NTS


<p>REPUBLIC OF THE PHILIPPINES UNIVERSITY OF SCIENCE & TECHNOLOGY OF SOUTHERN PHILIPPINES CIVIL AND SANITARY WORKS UNIT</p> <p>C.M. RECTO AVENUE, LAPASAN 9000 CAGAYAN DE ORO CITY TEL. NO. (08622) 72-40-45 / (0862) 854-4734 / 854-4729 TOLL FAX (0862) 854-4890 WWW SITE : WWW.USTP.EDU.PH</p>	PREPARED BY: ENGR. EDGEM LLOYD S. BALABIS ASSISTANT DIRECTOR, APS	PROJECT: PROPOSED RENOVATION OF ITB (BLDG. 3) AS THE COLLEGE OF MEDICINE (PHASE 2)	NOTED BY: DR. AMBROSIO S. CULTURA II DIRECTOR, UNIVERSITY MANAGEMENT SERVICES	RECOMMENDING APPROVAL: ATTY. JONATHAN S. OCHE VICE CHANCELLOR FOR FINANCE AND ADMINISTRATION	RECOMMENDING APPROVAL: ATTY. DIONEL O. ALBINA CHANCELLOR, USTP-CAG CAMPUS	APPROVED: DR. AMBROSIO S. CULTURA II UNIVERSITY PRESIDENT	SHEET TITLE: 1. SECOND FLOOR LIGHTING LAYOUT	DRAWN BY: E.C.H. DATE: 06-11-22	SHEET NO. E 6 6 6	
	PRC NO.: DTN: PTH NO.:		DATE ISSUED:	LOCATION: C.M. RECTO AVE., LAPASAN HIGHWAY, CAGAYAN DE ORO CITY	OWNER: UNIVERSITY OF SCIENCE & TECHNOLOGY OF SOUTHERN PHILIPPINES	CAD BY: R.P.E. DATE: 06-11-22				

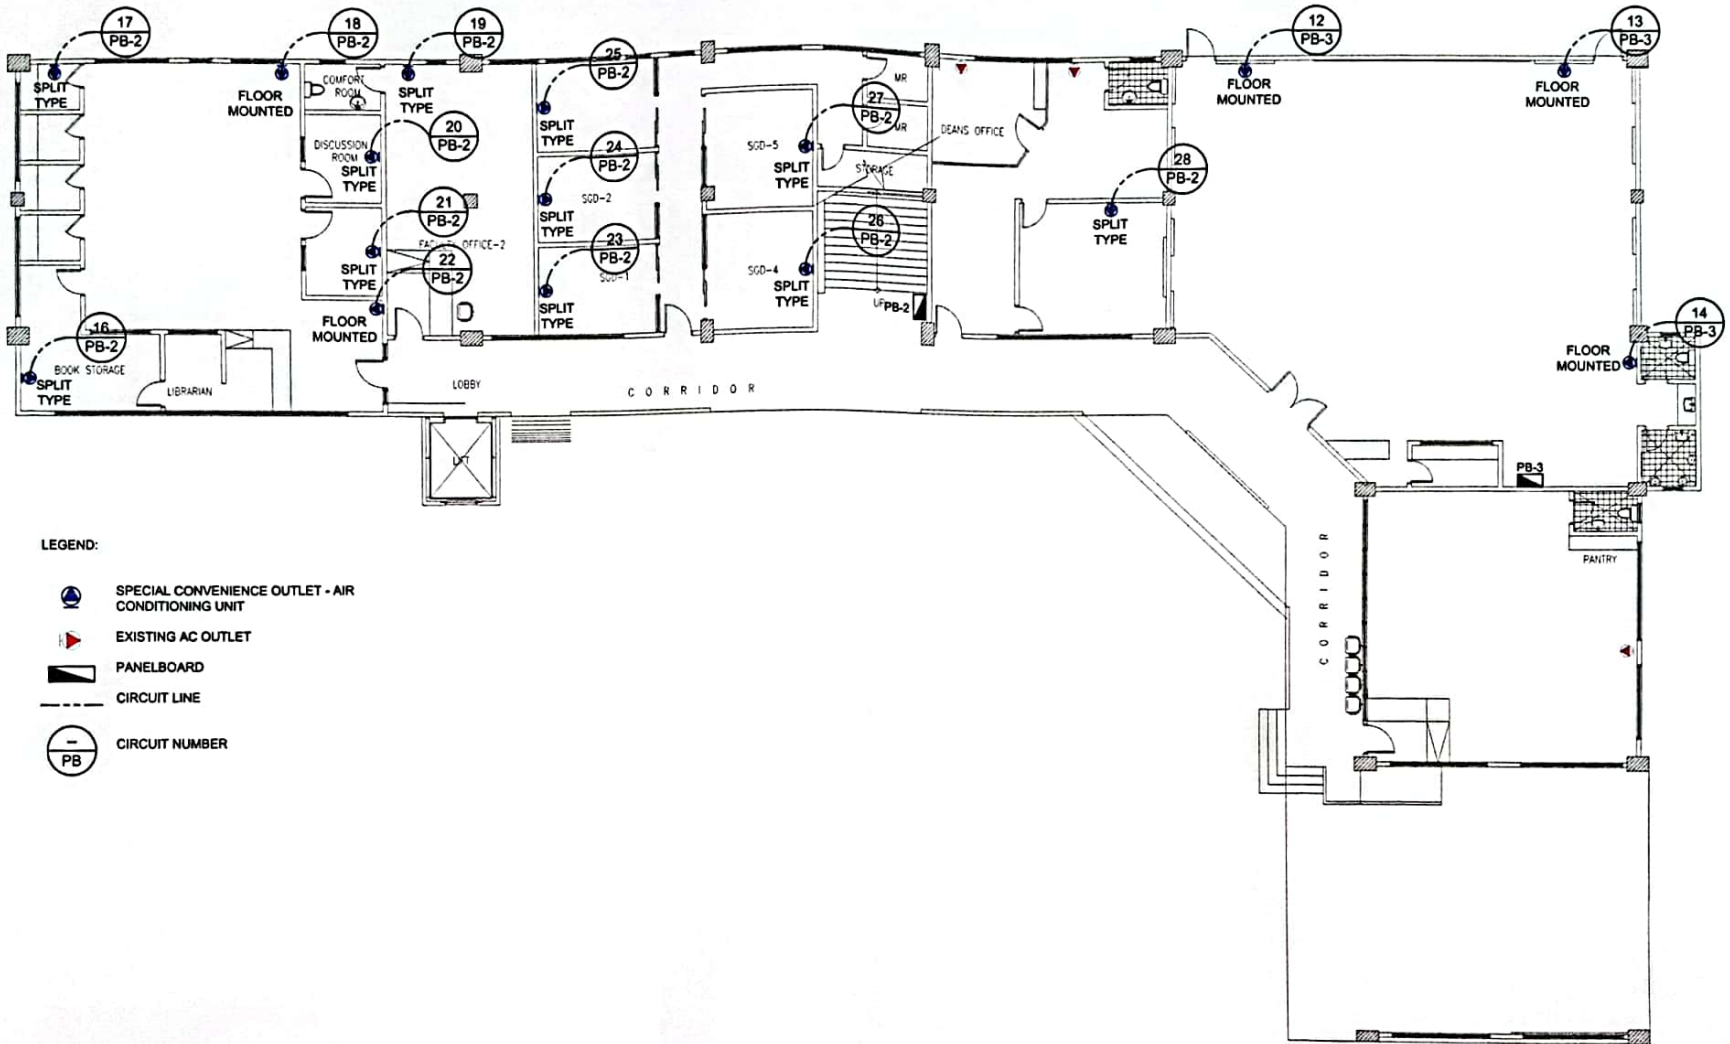





- LEGEND:**
- SPECIAL CONVENIENCE OUTLET - AIR CONDITIONING UNIT
 - EXISTING AC OUTLET
 - PANELBOARD
 - CIRCUIT LINE
 - CIRCUIT NUMBER

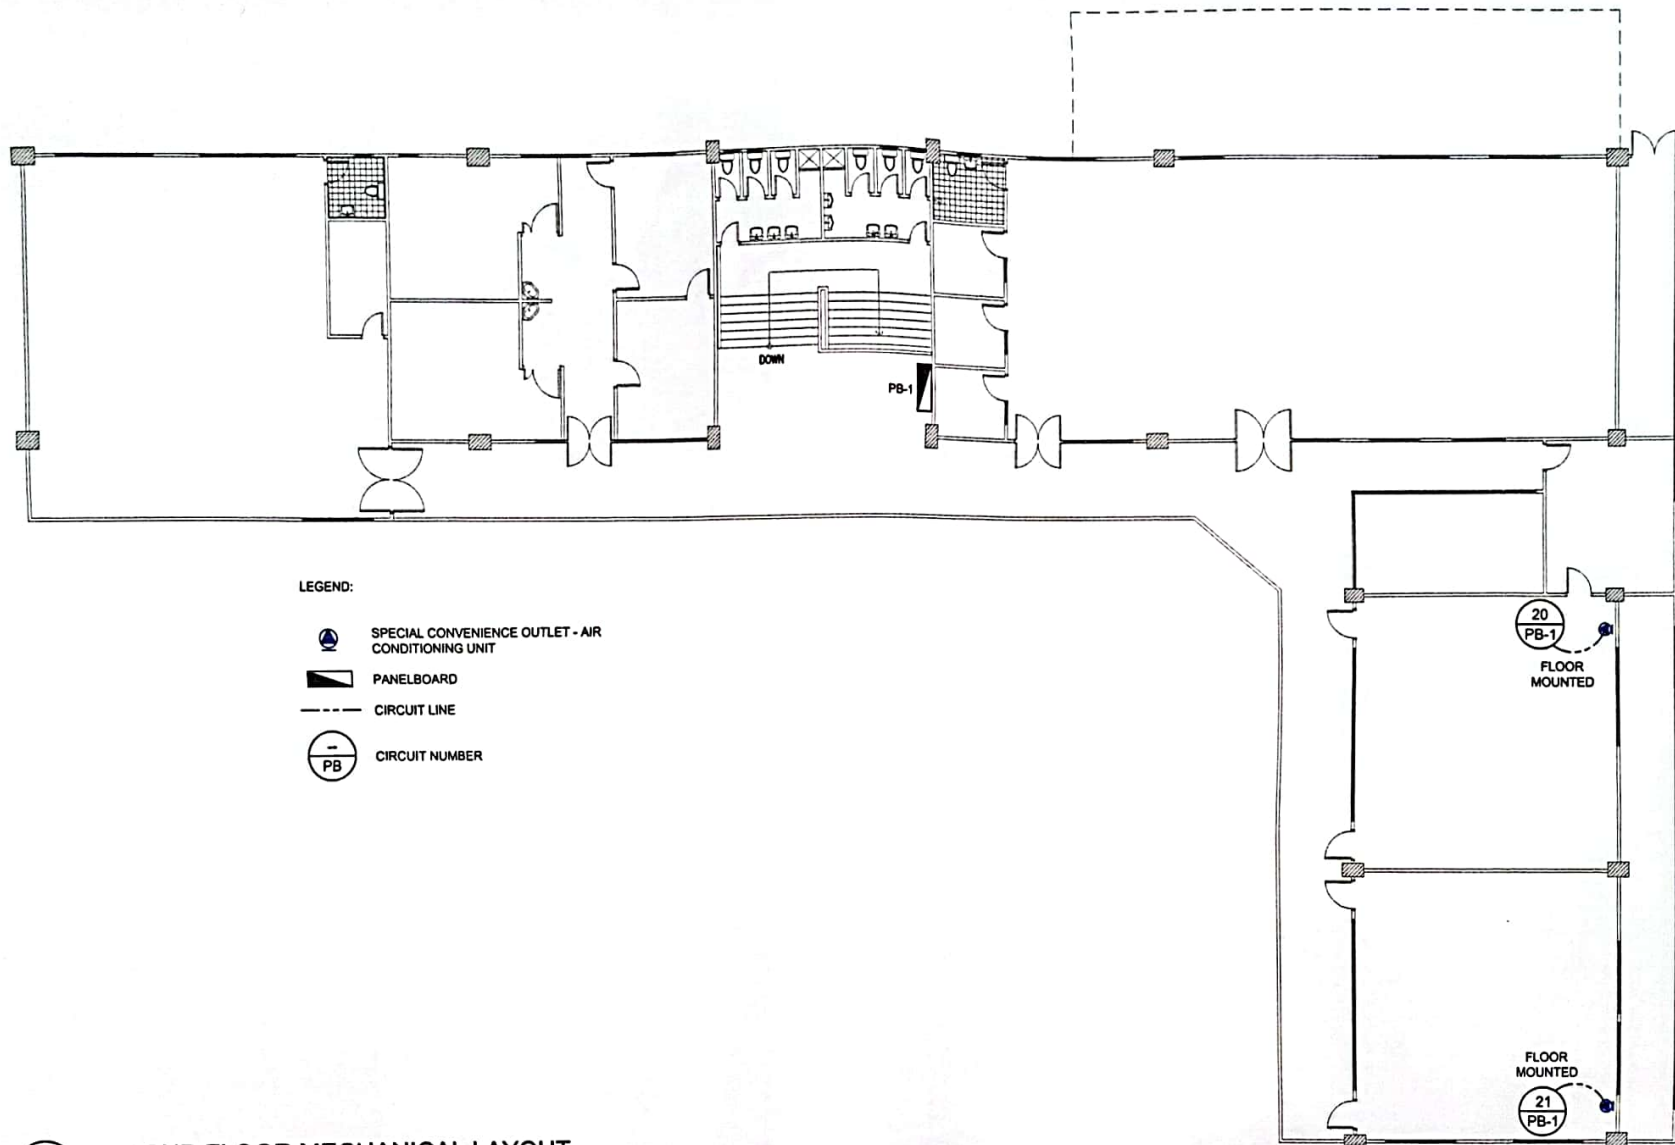1
M 1
GROUND FLOOR MECHANICAL LAYOUT
SCALE: 1:175M

<p>REPUBLIC OF THE PHILIPPINES UNIVERSITY OF SCIENCE & TECHNOLOGY OF SOUTHERN PHILIPPINES CIVIL AND SANITARY WORKS UNIT</p> <p>C. N. RECTO AVENUE, LAPASAN 9000 CAGAYAN DE ORO CITY TEL. NOS. (0882) 72-00-65 / (088) 850-1736 / 850-1730 TELS. FAX (088) 850-4698 WEB SITE: www.ustp.edu.ph</p>	<p>PREPARED BY: <i>[Signature]</i> ENGR. EDGERM LLOYD S. BALARIS ASSISTANT DIRECTOR, A/S</p>	<p>PROJECT: PROPOSED RENOVATION OF ITB (BLDG. 3) AS THE COLLEGE OF MEDICINE (PHASE 2)</p>	<p>NOTED BY: <i>[Signature]</i> DR. FERDINAND B. ALMORA DIRECTOR, UNIVERSITY MANAGEMENT SERVICES</p>	<p>RECOMMENDING APPROVAL: <i>[Signature]</i> ATTY. JONATHAN S. OCHE VICE CHANCELLOR FOR FINANCE AND ADMINISTRATION</p>	<p>RECOMMENDING APPROVAL: <i>[Signature]</i> ATTY. DIONEL O. ALBINA CHANCELLOR, USTP-CAG CAMPUS</p>	<p>APPROVED: <i>[Signature]</i> DR. AMBROSIO CULTURA II UNIVERSITY PRESIDENT</p>	<p>SHEET TITLE: 1. GROUND FLOOR MECHANICAL LAYOUT</p>	<p>DRAWN BY: G.C.H. DATE: 08-08-22</p>	<p>SHEET NO. M 1 1 2</p>
	<p>PHC NO. _____</p> <p>PTD NO. _____</p>	<p>DATE ISSUED: _____</p>	<p>LOCATION: C. N. RECTO AVE., LAPASAN HIGHWAY, CAGAYAN DE ORO CITY</p> <p>OWNER: UNIVERSITY OF SCIENCE & TECHNOLOGY OF SOUTHERN PHILIPPINES</p>	<p>DATE: _____</p>	<p>DATE: _____</p>	<p>DATE: _____</p>	<p>CAD BY: R.P.E. DATE: 08-08-22</p>		



LEGEND:

-  SPECIAL CONVENIENCE OUTLET - AIR CONDITIONING UNIT
-  PANELBOARD
-  CIRCUIT LINE
-  CIRCUIT NUMBER

1
M 2

 
SECOND FLOOR MECHANICAL LAYOUT

SCALE:

1:175M




REPUBLIC OF THE PHILIPPINES
UNIVERSITY OF SCIENCE & TECHNOLOGY OF SOUTHERN PHILIPPINES
 CIVIL AND SANITARY WORKS UNIT
 C.M. RECTO AVENUE, LAPASAN 9000 CAGAYAN DE ORO CITY
 TEL. NO. (088) 223 72-66-65 / (088) 856-4758 / 856-4759 TELE
 FAX (088) 856-4800
 WEB SITE: WWW.USTP.EDU.PH


PREPARED BY:

ENGR. EDEGM LLOYD S. BALANIS
 ASSISTANT DIRECTOR, ASB
 PRC NO.:
 PTR NO.:
 DATE ISSUED:


PROJECT:
PROPOSED RENOVATION OF ITB (BLDG. 3) AS THE COLLEGE OF MEDICINE (PHASE 2)
 LOCATION: C.M. RECTO AVE., LAPASAN HIGHWAY, CAGAYAN DE ORO CITY
 OWNER: UNIVERSITY OF SCIENCE & TECHNOLOGY OF SOUTHERN PHILIPPINES

 NOTED BY:

 DR. FERDINAND R. DUMPR
 DIRECTOR, AUXILIARY MANAGEMENT SERVICE

RECOMMENDING APPROVAL:

ATTY. JONATHAN S. OCHE
 VICE CHANCELLOR FOR FINANCE AND ADMINISTRATION

RECOMMENDING APPROVAL:

ATTY. DOREL O. ALBINA
 CHANCELLOR, USTP-CDO CAMPUS

APPROVED:

DR. AMBROSIO B. MURтура II
 UNIVERSITY PRESIDENT

SHEET TITLE:
 SHEET CONTENTS:
 1. SECOND FLOOR MECHANICAL LAYOUT


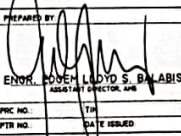
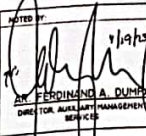
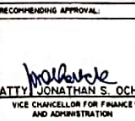

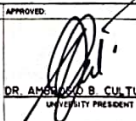
DRAWN BY: E.C.H.
 DATE: 08-02-22
 CAD BY: R.P.E.
 DATE: 08-02-22

SHEET NO.
 M
 2
 2
 2

- Ⓢ Smoke Detector
- Ⓜ Heat Detector
- Ⓜ Manual call point/Sounder
- FACP Fire Alarm Control Panel
- ▶ Data/Voice/TV
- Ⓜ Access Point
- 📹 CCTV




 
 
 
 
 
1
A
GROUND FLOOR SMOKE DETECTOR PLAN
SCALE: 1:200M


 <p>REPUBLIC OF THE PHILIPPINES UNIVERSITY OF SCIENCE & TECHNOLOGY OF SOUTHERN PHILIPPINES CIVIL AND SANITARY WORKS UNIT C.M. RECTO AVENUE LAPANAN 9000 CAGAYAN DE ORO CITY TEL. Nos. (08822) 72-60-65 / (0881) 856-1734 / 856-1734 Tels FAX (0881) 856-1696 Web Site: www.ustp.edu.ph</p>	PREPARED BY:  ENGR. LUDO S. BALABIS <small>ASSISTANT DIRECTOR, C&S</small>	PROJECT: UNIVERSITY OF SCIENCE & TECHNOLOGY OF SOUTHERN PHILIPPINES	NOTED BY:  ENR. FERDINAND A. DUMARAOG <small>DIRECTOR, AGENCIAMT MANAGEMENT SERVICE</small>	RECOMMENDING APPROVAL:  ATTY. JONATHAN S. OCBE <small>VICE CHANCELLOR FOR FINANCE AND ADMINISTRATION</small>	RECOMMENDING APPROVAL:  ATTY. DIONEL O. ALBINA <small>CHANCELLOR, USTP-CDO CAMPUS</small>	APPROVED:  DR. AMELOSIO B. CULTURA II <small>UNIVERSITY PRESIDENT</small>	SHEET TITLE: SHEET CONTENTS:	DRAWN BY: G.C.H. DATE: 08-11-22	SHEET NO.:	
	PTR NO.: 711 DATE ISSUED:	LOCATION: C.M. RECTO AVE., LAPANAN HIGHWAY, CAGAYAN DE ORO CITY OWNER: UNIVERSITY OF SCIENCE & TECHNOLOGY OF SOUTHERN PHILIPPINES	CAD BY: R.P.E. DATE: 08-11-22							

- Ⓢ Smoke Detector
- Ⓜ Heat Detector
- Ⓜ Manual call point/Sounder
- Ⓜ FACP Fire Alarm Control Panel
- ▶ Data/Voice/TV
- Ⓜ AP Access Point
- 📷 CCTV




1 GROUND FLOOR CCTV PLAN
 SCALE: 1:2000

	REPUBLIC OF THE PHILIPPINES UNIVERSITY OF SCIENCE & TECHNOLOGY OF SOUTHERN PHILIPPINES CIVIL AND SANITARY WORKS UNIT C. N. RECTO AVENUE, LAPANAN 9000 CAGAYAN DE ORO CITY TEL. (08622) 72-60-65 / (0862) 856-1756 / 856-1758 TELE FAX (086) 856-6699 WWW SITE : WWW.USTP.EDU.PH	PREPARED BY:  ENGR. EDEL LLOYD S. BALABIS ASST. CHIEF ENGINEER, CIVIL	PROJECT: PROPOSED RENOVATION OF ITB (BLDG. 3) AS THE COLLEGE OF MEDICINE (PHASE 2)	NOTED BY:  AR FERDINAND A. RUMPA DIRECTOR, QUALITY MANAGEMENT SERVICES	RECOMMENDING APPROVAL:  ATTY JONATHAN S. OCHE VICE CHANCELLOR FOR FINANCE AND ADMINISTRATION	RECOMMENDING APPROVAL:  ATTY DIONEL O. ALBINA CHANCELLOR, USTP-CDO CAMPUS	APPROVED:  DR. AMBROSIO M. CULTURA II UNIVERSITY PRESIDENT	SHEET TITLE: 1. GROUND FLOOR CCTV SYSTEM	DRAWN BY: G.C.H. DATE: 08-12-22	SHEET NO.
	PRC NO. TRM PTR NO.	DATE ISSUED	LOCATION: C. N. RECTO AVE., LAPANAN HIGHWAY, CASAYAN DE ORO CITY OWNER: UNIVERSITY OF SCIENCE & TECHNOLOGY OF SOUTHERN PHILIPPINES	SHEET CONTENTS:	CAD BY: R.P.E. DATE: 08-12-22					

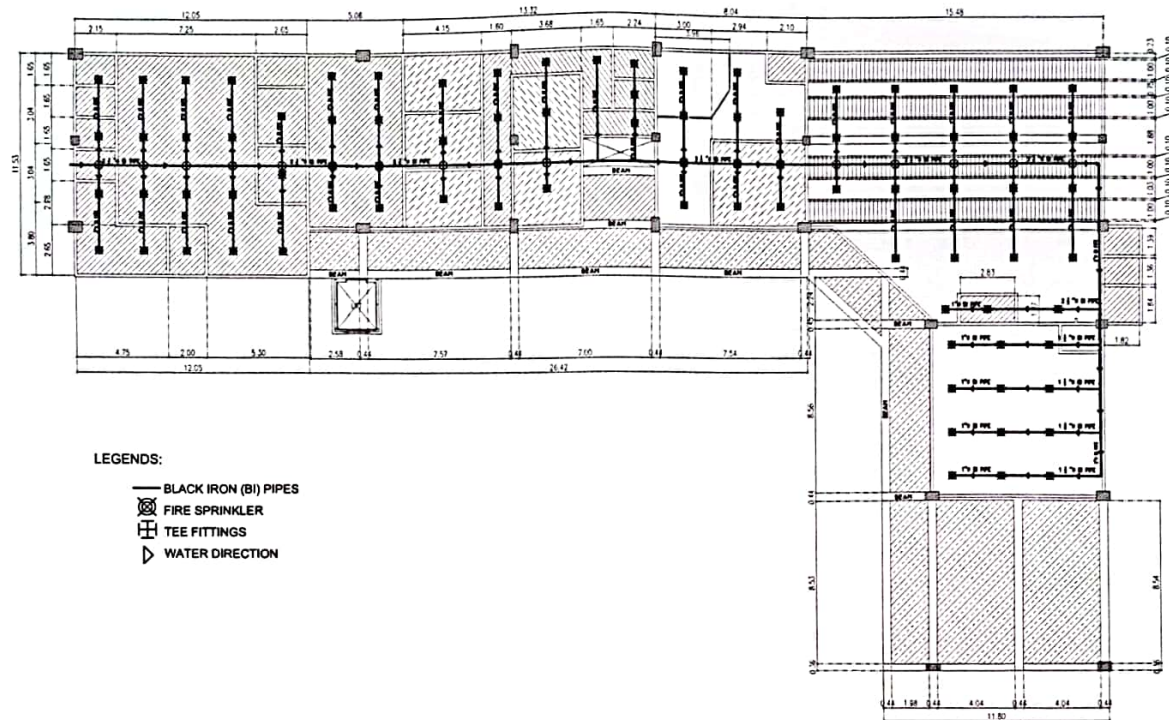

LEGENDS:

- BLACK IRON (BI) PIPES
- ☒ FIRE SPRINKLER
- ⊕ TEE FITTINGS
- ▷ WATER DIRECTION

 <p>REPUBLIC OF THE PHILIPPINES UNIVERSITY OF SCIENCE & TECHNOLOGY OF SOUTHERN PHILIPPINES CIVIL AND SANITARY WORKS UNIT</p> <p>C. P. RECTO AVENUE, LAPASAN 9000 CAGAYAN DE ORO CITY TEL. NO. (08422) 71-66-66 / (084) 856-1738 / 856-1739 TOLL FAX (088) 856-6696 WWW.USTP.EDU.PH</p>	<p>PREPARED BY: <i>[Signature]</i> ENGR. EDSEB LLOYD S. BALABIS ASSISTANT DIRECTOR, C&SW</p>	<p>PROJECT: PROPOSED RENOVATION OF ITB (BLDG. 3) AS THE COLLEGE OF MEDICINE (PHASE 2)</p>	<p>NO. BY: <i>[Signature]</i> 4/14/13 DR. FERDINAND A. DUMPA DIRECTOR, FACILITY MANAGEMENT SERVICES</p>	<p>RECOMMENDING APPROVAL: <i>[Signature]</i> ATTY. JONATHAN S. OCHE VICE CHANCELLOR FOR FINANCE AND ADMINISTRATION</p>	<p>RECOMMENDING APPROVAL: <i>[Signature]</i> ATTY. GEMEZ O. ALBINA CHANCELLOR, USTP-CAG CAMPUS</p>	<p>APPROVED: <i>[Signature]</i> DR. AMBROSIO M. CULTURA II UNIVERSITY PRESIDENT</p>	<p>SHEET TITLE: SHEET CONTENTS</p>	<p>DRAWN BY: G.C.H. DATE: 08-6-22</p>	<p>SHEET NO.</p>
	<p>DATE ISSUED</p>	<p>LOCATION: C. N. RECTO AVE., LAPASAN HIGHWAY, CAGAYAN DE ORO CITY</p> <p>OWNER: UNIVERSITY OF SCIENCE & TECHNOLOGY OF SOUTHERN PHILIPPINES</p>	<p>DATE: 08-6-22</p>	<p>CAD BY: R.P.E.</p>					