





1-4 PERSPECTIVES
A3 NTS

 <p>REPUBLIC OF THE PHILIPPINES UNIVERSITY OF SCIENCE & TECHNOLOGY OF SOUTHERN PHILIPPINES CIVIL AND SANITARY WORKS UNIT C/O. BAYVIEW MANSION, 15th FLOOR, UNIVERSITY OF SCIENCE & TECHNOLOGY OF SOUTHERN PHILIPPINES DUPONT DRIVE, CANTONMENT, CAGAYAN DE ORO CITY TEL: (088) 888-8888 FAX: (088) 888-8888 WWW.USTP.EDU.PH</p>		<p>PREPARED BY ENGR. ANGELIZ C. NERI, JR. HEAD CIVIL AND SANITARY WORKS SECTION</p> <p>PROJ. NO. PRJ. NO.</p>	<p>PROJECT PROPOSED CAREER CENTER INTERIOR RENOVATION</p> <p>LOCATION: C. CALISTO AVE., LAPANAN HIGHLAND, CAGAYAN DE ORO CITY</p> <p>DRAWN: UNIVERSITY OF SCIENCE & TECHNOLOGY OF SOUTHERN PHILIPPINES</p>	<p>RECOMMENDING APPROVAL: [Signature]</p> <p>RECOMMENDING APPROVAL: [Signature]</p> <p>RECOMMENDING APPROVAL: [Signature]</p> <p>RECOMMENDING APPROVAL: [Signature]</p> <p>RECOMMENDING APPROVAL: [Signature]</p>	<p>SHEET TITLE SHEET CONTENTS</p> <p>DRAWN BY DATE</p> <p>CHECK BY DATE</p>	<p>SHEET NO. A 3 3 22</p>
--	--	---	--	---	---	---

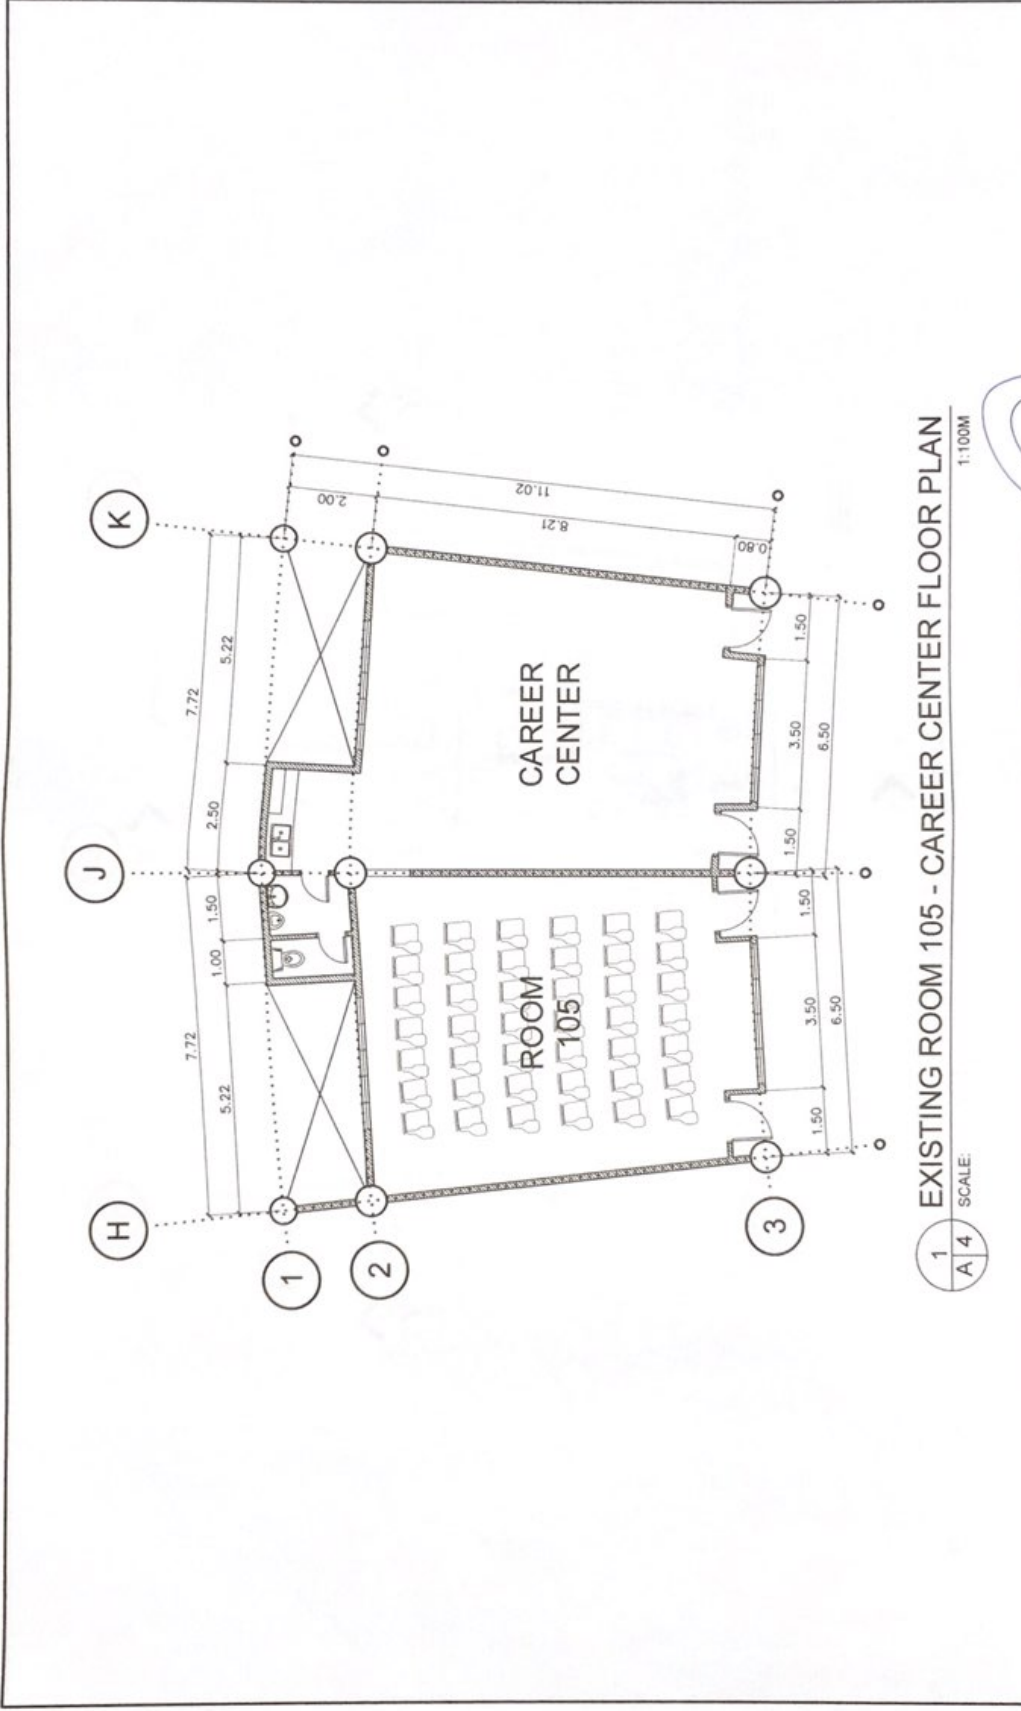


 REPUBLIC OF THE PHILIPPINES UNIVERSITY OF SCIENCE & TECHNOLOGY OF CAGAYAN DE ORO CIVIL AND SANITARY WORKS UNIT C. M. REYES AVENUE, LAMPARAN, 9505 CAGAYAN DE ORO CITY TEL. NOS. (0882) 79-68-65 / (0882) 854-078 / 855-079 TOLL FREE HOTLINE: 0999-7447-84-74 FAX NO. 0999-7447-84-74	PREPARED BY: ENGR. ANSELMO C. NERIL, JR. HEAD, CIVIL AND SANITARY WORKS SECTION	PROJECT: PROPOSED CAREER CENTER INTERIOR RENOVATION	LOCATION: C. M. REYES AVE., LAMPARAN, CAGAYAN DE ORO CITY	SHEET NO. A 4	SHEET NO. A 4
	DATE ISSUED: DATE	CHECKED BY: DATE	REVISIONS: NO. DESCRIPTION DATE	APPROVED BY: DATE	DRAWN BY: DATE


1 | 4 | SCALE: 1:100M
 EXISTING ROOM 105 - CAREER CENTER FLOOR PLAN

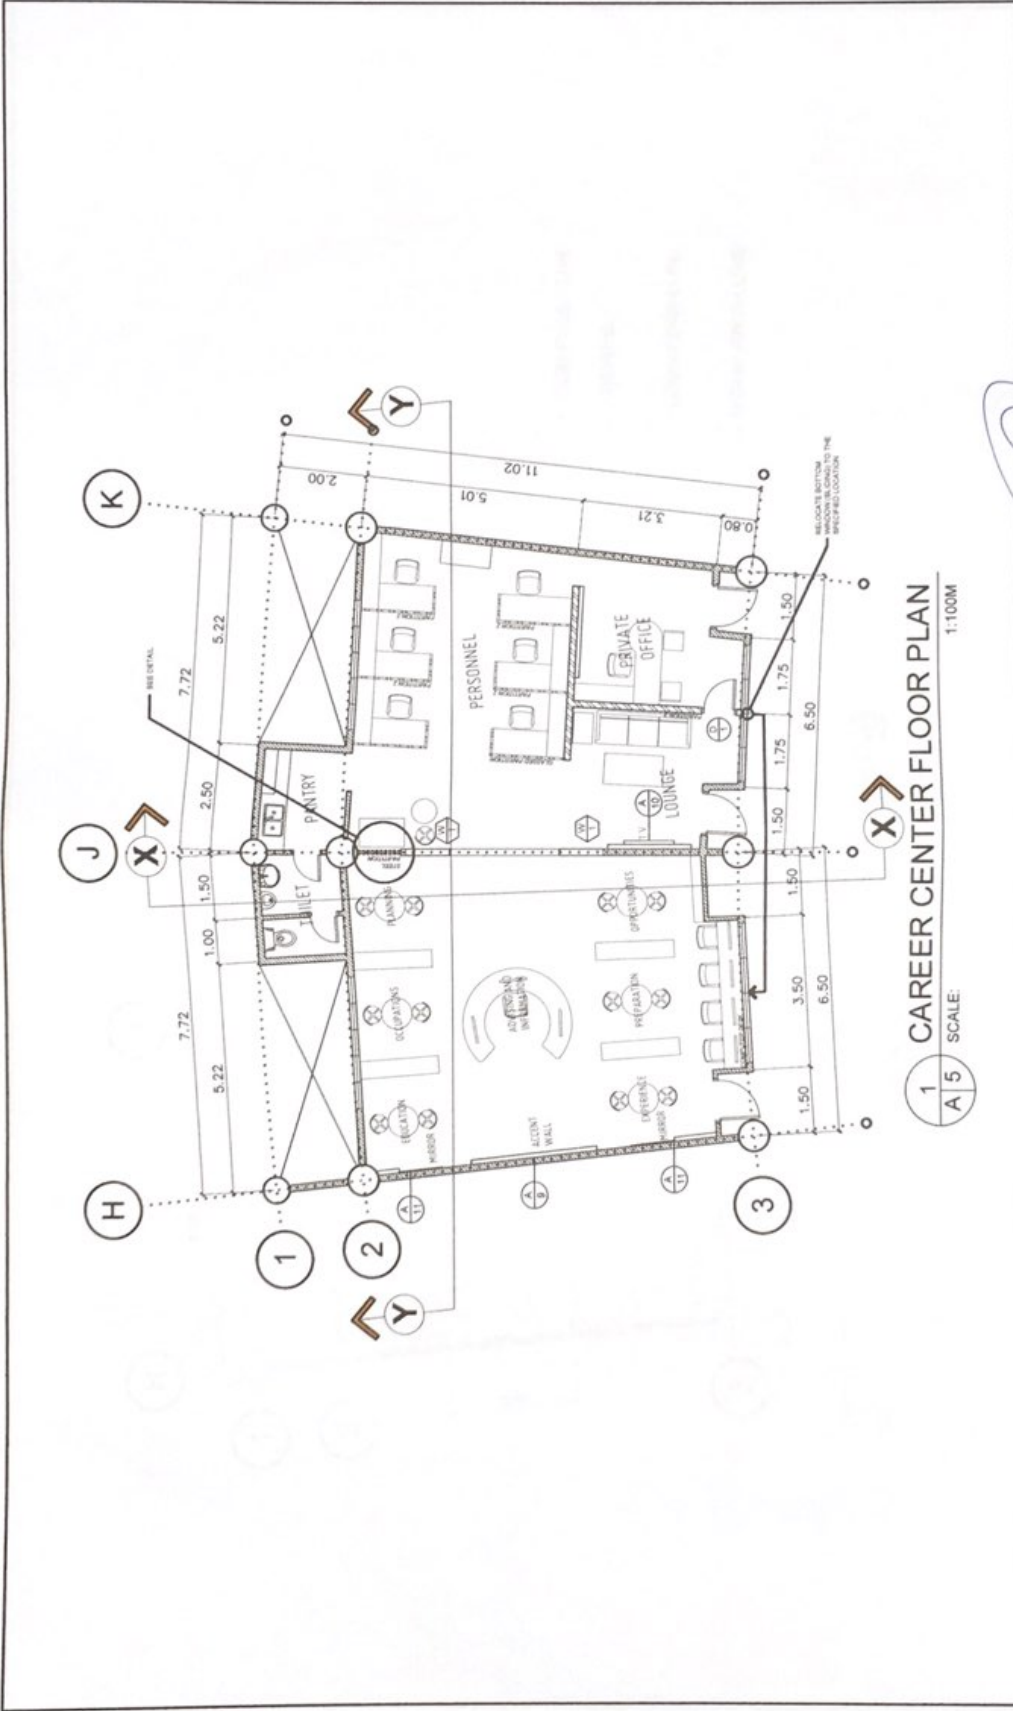

 REPUBLIC OF THE PHILIPPINES UNIVERSITY OF SCIENCE & TECHNOLOGY OF SOUTHERN PHILIPPINES CIVIL AND SANITARY WORKS UNIT C.A. MINTO AVENUE, LAMPANAN 9000 CAGAYAN DE ORO CITY TEL. (088) 884-1518 FAX (088) 884-1518 9000 CAGAYAN DE ORO CITY	PREPARED BY ENGR. ANSELMO C. MARIAS ARCH. CIVIL AND SANITARY WORKS DIVISION PROJECT NO. 1 DATE 11/11/2018	PROJECT PROPOSED CAREER CENTER INTERIOR RENOVATION	SHEET NO. A 5 5 22
	CHECKED BY ENGR. JUAN C. MARIAS ARCHITECT DATE 11/11/2018	APPROVED BY ENGR. JUAN C. MARIAS ARCHITECT DATE 11/11/2018	SHEET TITLE CAREER CENTER INTERIOR RENOVATION

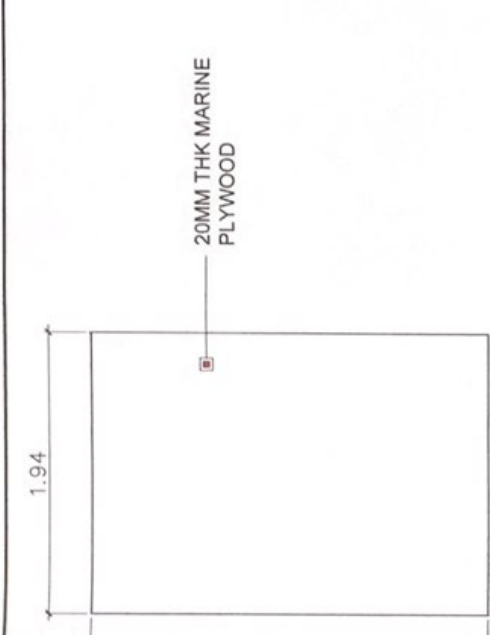


1 TV ACCENT WALL FRONT DETAIL
A/10 SCALE 1:30M

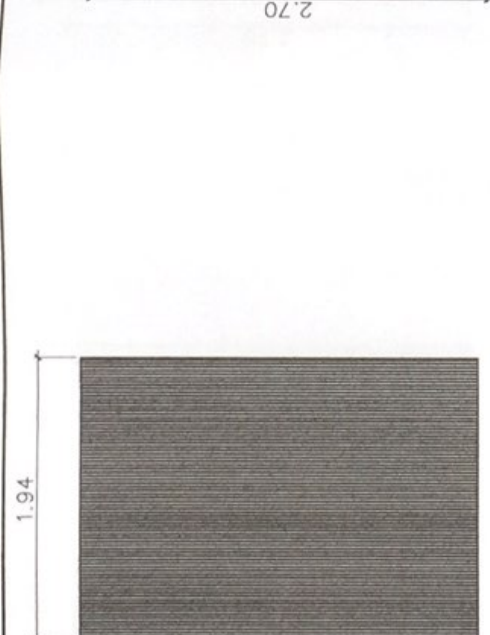

2 TV ACCENT WALL REAR DETAIL
A/10 SCALE 1:30M


20MM THK MARINE PLYWOOD

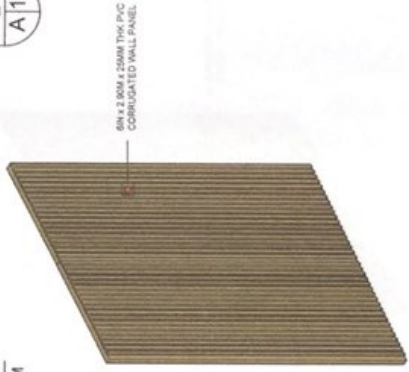


6MM x 2.80M x 2.80M THK PVC CORRUGATED WALL PANEL

3 TV ACCENT WALL ISOMETRIC VIEW
A/10 NTS


 REPUBLIC OF THE PHILIPPINES UNIVERSITY OF SCIENCE & TECHNOLOGY OF SOUTHERN PHILIPPINES COLLEGE OF ARCHITECTURE C-4, RIZAL AVENUE, LAMPARAQUE, SORSOGON PROVINCE, SOUTHERN PHILIPPINES TEL. NO. (083) 72-0543 / 7205118 / 720-079 Fax FAX NO. 720-079	PREPARED BY ENGR. ANGELO C. JARILLER HEAD CIVIL AND STRUCTURAL ENGINEERING SECTION	PROJECT PROPOSED CAREER CENTER INTERIOR RENOVATION	SHEET NO. A/10	SHEET TOTAL 10	DRAWN BY DATE	CHECKED BY DATE	10 22
	RECOMMENDING OFFICIAL RECOMMENDING OFFICIAL RECOMMENDING OFFICIAL RECOMMENDING OFFICIAL 	REVISIONS NO. DATE DESCRIPTION	PROJECT NO. DATE ISSUED	SHEET NO. A/10	SHEET TOTAL 10	DRAWN BY DATE	CHECKED BY DATE

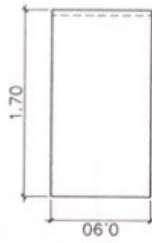


1 PARTITION 2 FRONT DETAIL
A13 SCALE: 1:40M

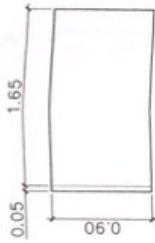


2 PARTITION 2 REAR DETAIL
A13 SCALE: 1:40M

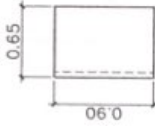

3 PARTITION 2 RIGHT DETAIL
A13 SCALE: 1:40M

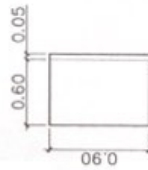


4 PARTITION 2 LEFT DETAIL
A13 SCALE: 1:40M

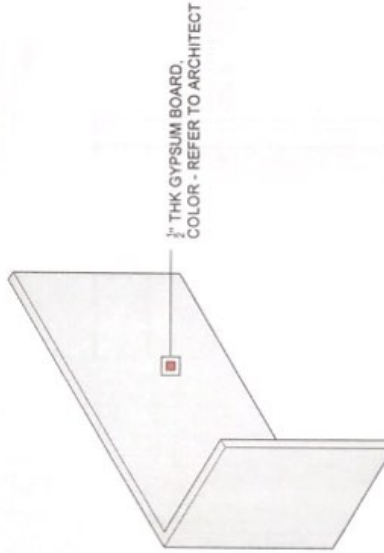


5 PARTITION 2 ISOMETRIC VIEW
A13 NTS


	UNIVERSITY OF SCIENCE & TECHNOLOGY OF THE PHILIPPINES CIVIL AND SANITARY ENGINEERING DEPARTMENT 640 N. ALEXANDER DRIVE, MANILA TEL. NO. (02) 863-1000 FAX NO. (02) 863-1000 WWW.USTIP.UPH.EDU	PROJECT: PROPOSED CAREER CENTER INTERIOR RENOVATION LOCATION: UNIVERSITY OF SCIENCE & TECHNOLOGY OF THE PHILIPPINES	DRAWN BY: DATE: CHECKED BY: DATE:	SHEET NO. A13 TOTAL SHEETS: 22
	REGISTERED PROFESSIONAL ENGINEER REGISTERED PROFESSIONAL ARCHITECT REGISTERED PROFESSIONAL ELECTRICAL ENGINEER REGISTERED PROFESSIONAL MECHANICAL ENGINEER REGISTERED PROFESSIONAL CIVIL ENGINEER REGISTERED PROFESSIONAL SANITARY ENGINEER REGISTERED PROFESSIONAL LAND SURVEYOR REGISTERED PROFESSIONAL AGRICULTURAL ENGINEER REGISTERED PROFESSIONAL CHEMICAL ENGINEER REGISTERED PROFESSIONAL INDUSTRIAL ENGINEER REGISTERED PROFESSIONAL METALLURGICAL ENGINEER REGISTERED PROFESSIONAL MINING ENGINEER REGISTERED PROFESSIONAL PETROLEUM ENGINEER REGISTERED PROFESSIONAL POWER ENGINEER REGISTERED PROFESSIONAL RAILROAD ENGINEER REGISTERED PROFESSIONAL SURVEYING ENGINEER REGISTERED PROFESSIONAL WATER RESOURCES ENGINEER REGISTERED PROFESSIONAL WASTE MANAGEMENT ENGINEER	REGISTERED PROFESSIONAL ARCHITECT REGISTERED PROFESSIONAL ELECTRICAL ENGINEER REGISTERED PROFESSIONAL MECHANICAL ENGINEER REGISTERED PROFESSIONAL CIVIL ENGINEER REGISTERED PROFESSIONAL SANITARY ENGINEER REGISTERED PROFESSIONAL LAND SURVEYOR REGISTERED PROFESSIONAL AGRICULTURAL ENGINEER REGISTERED PROFESSIONAL CHEMICAL ENGINEER REGISTERED PROFESSIONAL INDUSTRIAL ENGINEER REGISTERED PROFESSIONAL METALLURGICAL ENGINEER REGISTERED PROFESSIONAL MINING ENGINEER REGISTERED PROFESSIONAL PETROLEUM ENGINEER REGISTERED PROFESSIONAL POWER ENGINEER REGISTERED PROFESSIONAL RAILROAD ENGINEER REGISTERED PROFESSIONAL SURVEYING ENGINEER REGISTERED PROFESSIONAL WATER RESOURCES ENGINEER REGISTERED PROFESSIONAL WASTE MANAGEMENT ENGINEER	REGISTERED PROFESSIONAL ARCHITECT REGISTERED PROFESSIONAL ELECTRICAL ENGINEER REGISTERED PROFESSIONAL MECHANICAL ENGINEER REGISTERED PROFESSIONAL CIVIL ENGINEER REGISTERED PROFESSIONAL SANITARY ENGINEER REGISTERED PROFESSIONAL LAND SURVEYOR REGISTERED PROFESSIONAL AGRICULTURAL ENGINEER REGISTERED PROFESSIONAL CHEMICAL ENGINEER REGISTERED PROFESSIONAL INDUSTRIAL ENGINEER REGISTERED PROFESSIONAL METALLURGICAL ENGINEER REGISTERED PROFESSIONAL MINING ENGINEER REGISTERED PROFESSIONAL PETROLEUM ENGINEER REGISTERED PROFESSIONAL POWER ENGINEER REGISTERED PROFESSIONAL RAILROAD ENGINEER REGISTERED PROFESSIONAL SURVEYING ENGINEER REGISTERED PROFESSIONAL WATER RESOURCES ENGINEER REGISTERED PROFESSIONAL WASTE MANAGEMENT ENGINEER	REGISTERED PROFESSIONAL ARCHITECT REGISTERED PROFESSIONAL ELECTRICAL ENGINEER REGISTERED PROFESSIONAL MECHANICAL ENGINEER REGISTERED PROFESSIONAL CIVIL ENGINEER REGISTERED PROFESSIONAL SANITARY ENGINEER REGISTERED PROFESSIONAL LAND SURVEYOR REGISTERED PROFESSIONAL AGRICULTURAL ENGINEER REGISTERED PROFESSIONAL CHEMICAL ENGINEER REGISTERED PROFESSIONAL INDUSTRIAL ENGINEER REGISTERED PROFESSIONAL METALLURGICAL ENGINEER REGISTERED PROFESSIONAL MINING ENGINEER REGISTERED PROFESSIONAL PETROLEUM ENGINEER REGISTERED PROFESSIONAL POWER ENGINEER REGISTERED PROFESSIONAL RAILROAD ENGINEER REGISTERED PROFESSIONAL SURVEYING ENGINEER REGISTERED PROFESSIONAL WATER RESOURCES ENGINEER REGISTERED PROFESSIONAL WASTE MANAGEMENT ENGINEER

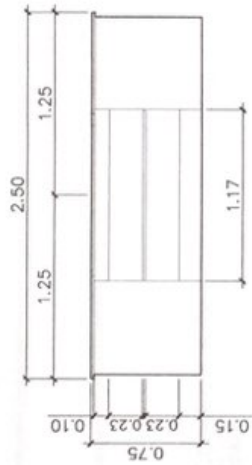

1 CIRCULAR DESK FRONT DETAIL
A 15 SCALE: 1:30M

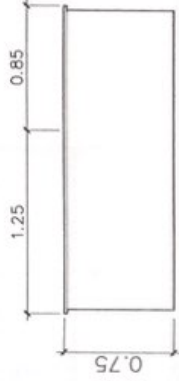


2 CIRCULAR DESK SIDE DETAIL
A 15 SCALE: 1:30M

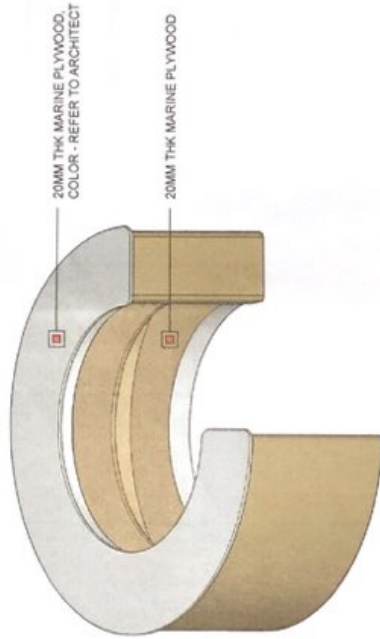


3 CIRCULAR DESK ISOMETRIC VIEW
A 15 NTS


	REPUBLIC OF THE PHILIPPINES UNIVERSITY OF SCIENCE & TECHNOLOGY OF SOUTHERN PHILIPPINES CIVIL AND SANITARY WORKS UNIT C/O NORTH AVENUE, LAMARAN WEST CAMPUS W/ 2ND CITY DAVAO DEL NORTE / DAVAO CITY / DAVAO DEL NORTE PHILIPPINES TEL NO. 083 824 1115 FAX NO. 083 824 1115	PROJECT ENGR. ALBERTO C. JENI, JR. HEAD CIVIL AND SANITARY WORKS SECTION DATE: 08/15/2015	PROPOSED CAREER CENTER INTERIOR RENOVATION LOCATION: 2nd FLOOR EAST - LAMARAN UNIVERSITY - CAMPUS DEL NORTE CITY OWNER: UNIVERSITY OF SCIENCE & TECHNOLOGY OF SOUTHERN PHILIPPINES	REGISTERED ARCHITECT 	REGISTERED ARCHITECT 	REGISTERED ARCHITECT 	REGISTERED ARCHITECT 	REGISTERED ARCHITECT 	SHEET TITLE SHEET CONTENTS	DRAWN BY DATE	CHECKED BY DATE	SHEET NO. A 15 15 22
	UNIVERSITY OF SCIENCE & TECHNOLOGY OF SOUTHERN PHILIPPINES											

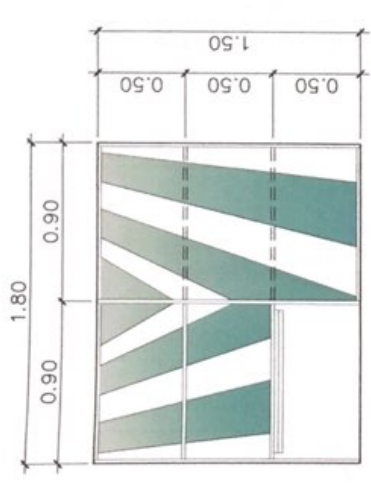


1
A18
SCALE: 1:25M
SHELVES WITH DRAWERS
SIDE VIEW

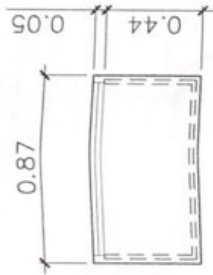


3
A18
SCALE: 1:20M
DRAWER FRONT VIEW
DETAIL

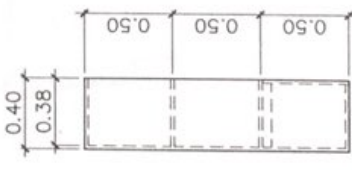

2
A18
SCALE: 1:25M
SHELVES WITH DRAWERS
SIDE VIEW

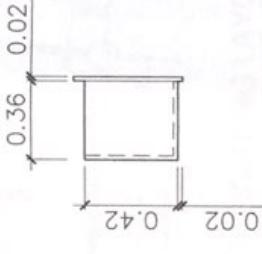


4
A18
SCALE: 1:20M
DRAWER SIDE VIEW
DETAIL

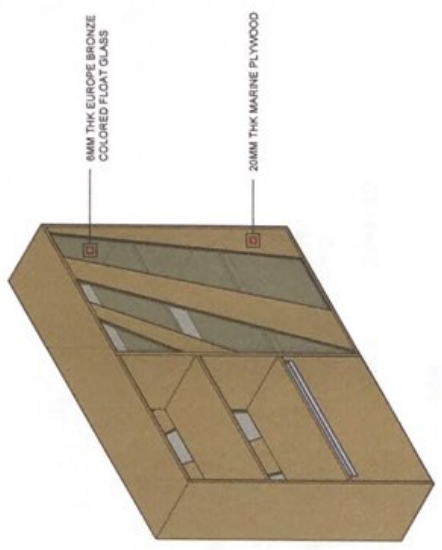

5
A18
NTS
SHELVES WITH DRAWERS
ISOMETRIC VIEW

	PREPARED BY: ENGR. ANSELMO C. MELI, JR. HEAD CIVIL AND SANITARY WORKS SECTION PRC NO. _____ PYS NO. _____	PROJECT: PROPOSED CAREER CENTER INTERIOR RENOVATION LOCATION: C.P. ARCTO AVE., LAPANAN HIGHWAY, CALABANG CITY OWNER: UNIVERSITY OF SCIENCE & TECHNOLOGY OF SOUTHERN PHILIPPINES	RECOMMENDING APPROVAL: 	RECOMMENDING APPROVAL: 	RECOMMENDING APPROVAL: 	RECOMMENDING APPROVAL: 	SHEET TITLE: SHEET CONTENTS: DRAWN BY: DATE: CHECK BY: DATE:	SHEET NO. A18 18 22
	REPUBLIC OF THE PHILIPPINES UNIVERSITY OF SCIENCE & TECHNOLOGY OF CIVIL AND SANITARY WORKS UNIT C.P. ARCTO AVE., LAPANAN HIGHWAY, CALABANG CITY TEL. NO. (8082) 77-60-85 / (8082) 85-0735 / 784 FAX NO. (8082) 77-60-85 / (8082) 85-0735 / 784 WEB SITE: www.ustp.edu.ph							

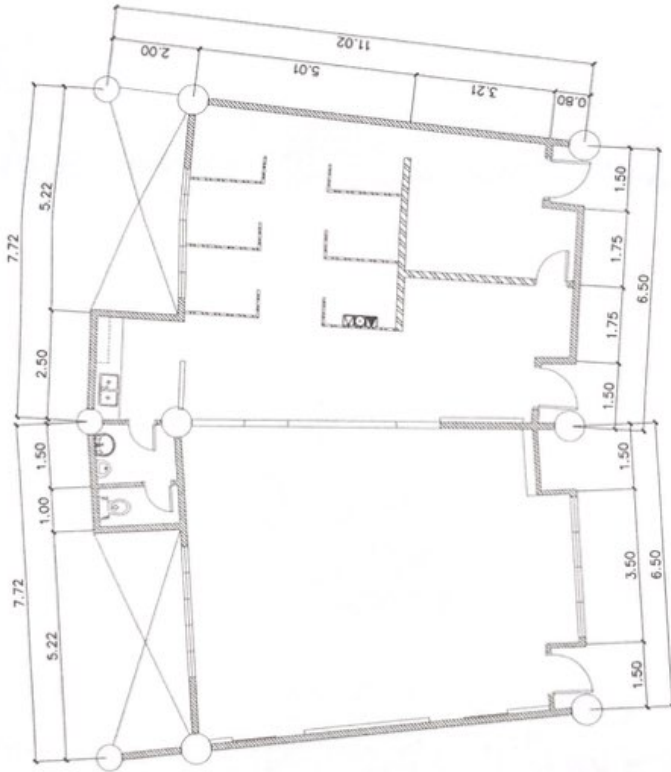

LEGEND:

- ▲ SINGLE PORT TELEPHONE OUTLET
- SINGLE PORT CATV OUTLET
- ▽ SINGLE PORT DATA OUTLET

1 ELECTRONICS OUTLET LAYOUT
E 2 SCALE: 1:100M

 REPUBLIC OF THE PHILIPPINES UNIVERSITY OF SCIENCE & TECHNOLOGY OF SOUTHERN PHILIPPINES CIVIL AND SANITARY WORKS UNIT C-4 North Landa, Landaan West Campus at the City Zamboanga City, Zamboanga del Sur Tel. (092) 241-4111 Fax (092) 241-4112 www.ustp.edu.ph	DEPARTMENT BY EGGIE J. ANCIANO, C.E., M.S., L.P. ENGINEER IN CHARGE DATE: 05/10/2018 DRAW NO: 001 SHEET NO: 001	PROJECT PROPOSED CAREER CENTER INTERIOR RENOVATION LOCATION: 1.4 M. BELLE SALE, (SARAWAN) HIGHWAY, (SARAWAN) DISTRICT, CITY, ZAMBOANGA DEL SUR, PROVINCE OF SOUTHERN PHILIPPINES	RECOMMENDING APPROVAL ATTY. JOSE S. ALARCON ATTORNEY AT LAW	RECOMMENDING APPROVAL ENGR. R. CALDEIRA REGISTERED PROFESSIONAL ENGINEER	CHECKED BY ENGR. R. CALDEIRA REGISTERED PROFESSIONAL ENGINEER	DRAWN BY DATE: DATE: DATE:	SHEET NO. ECE 1 22 22
	DATE: 05/10/2018						